

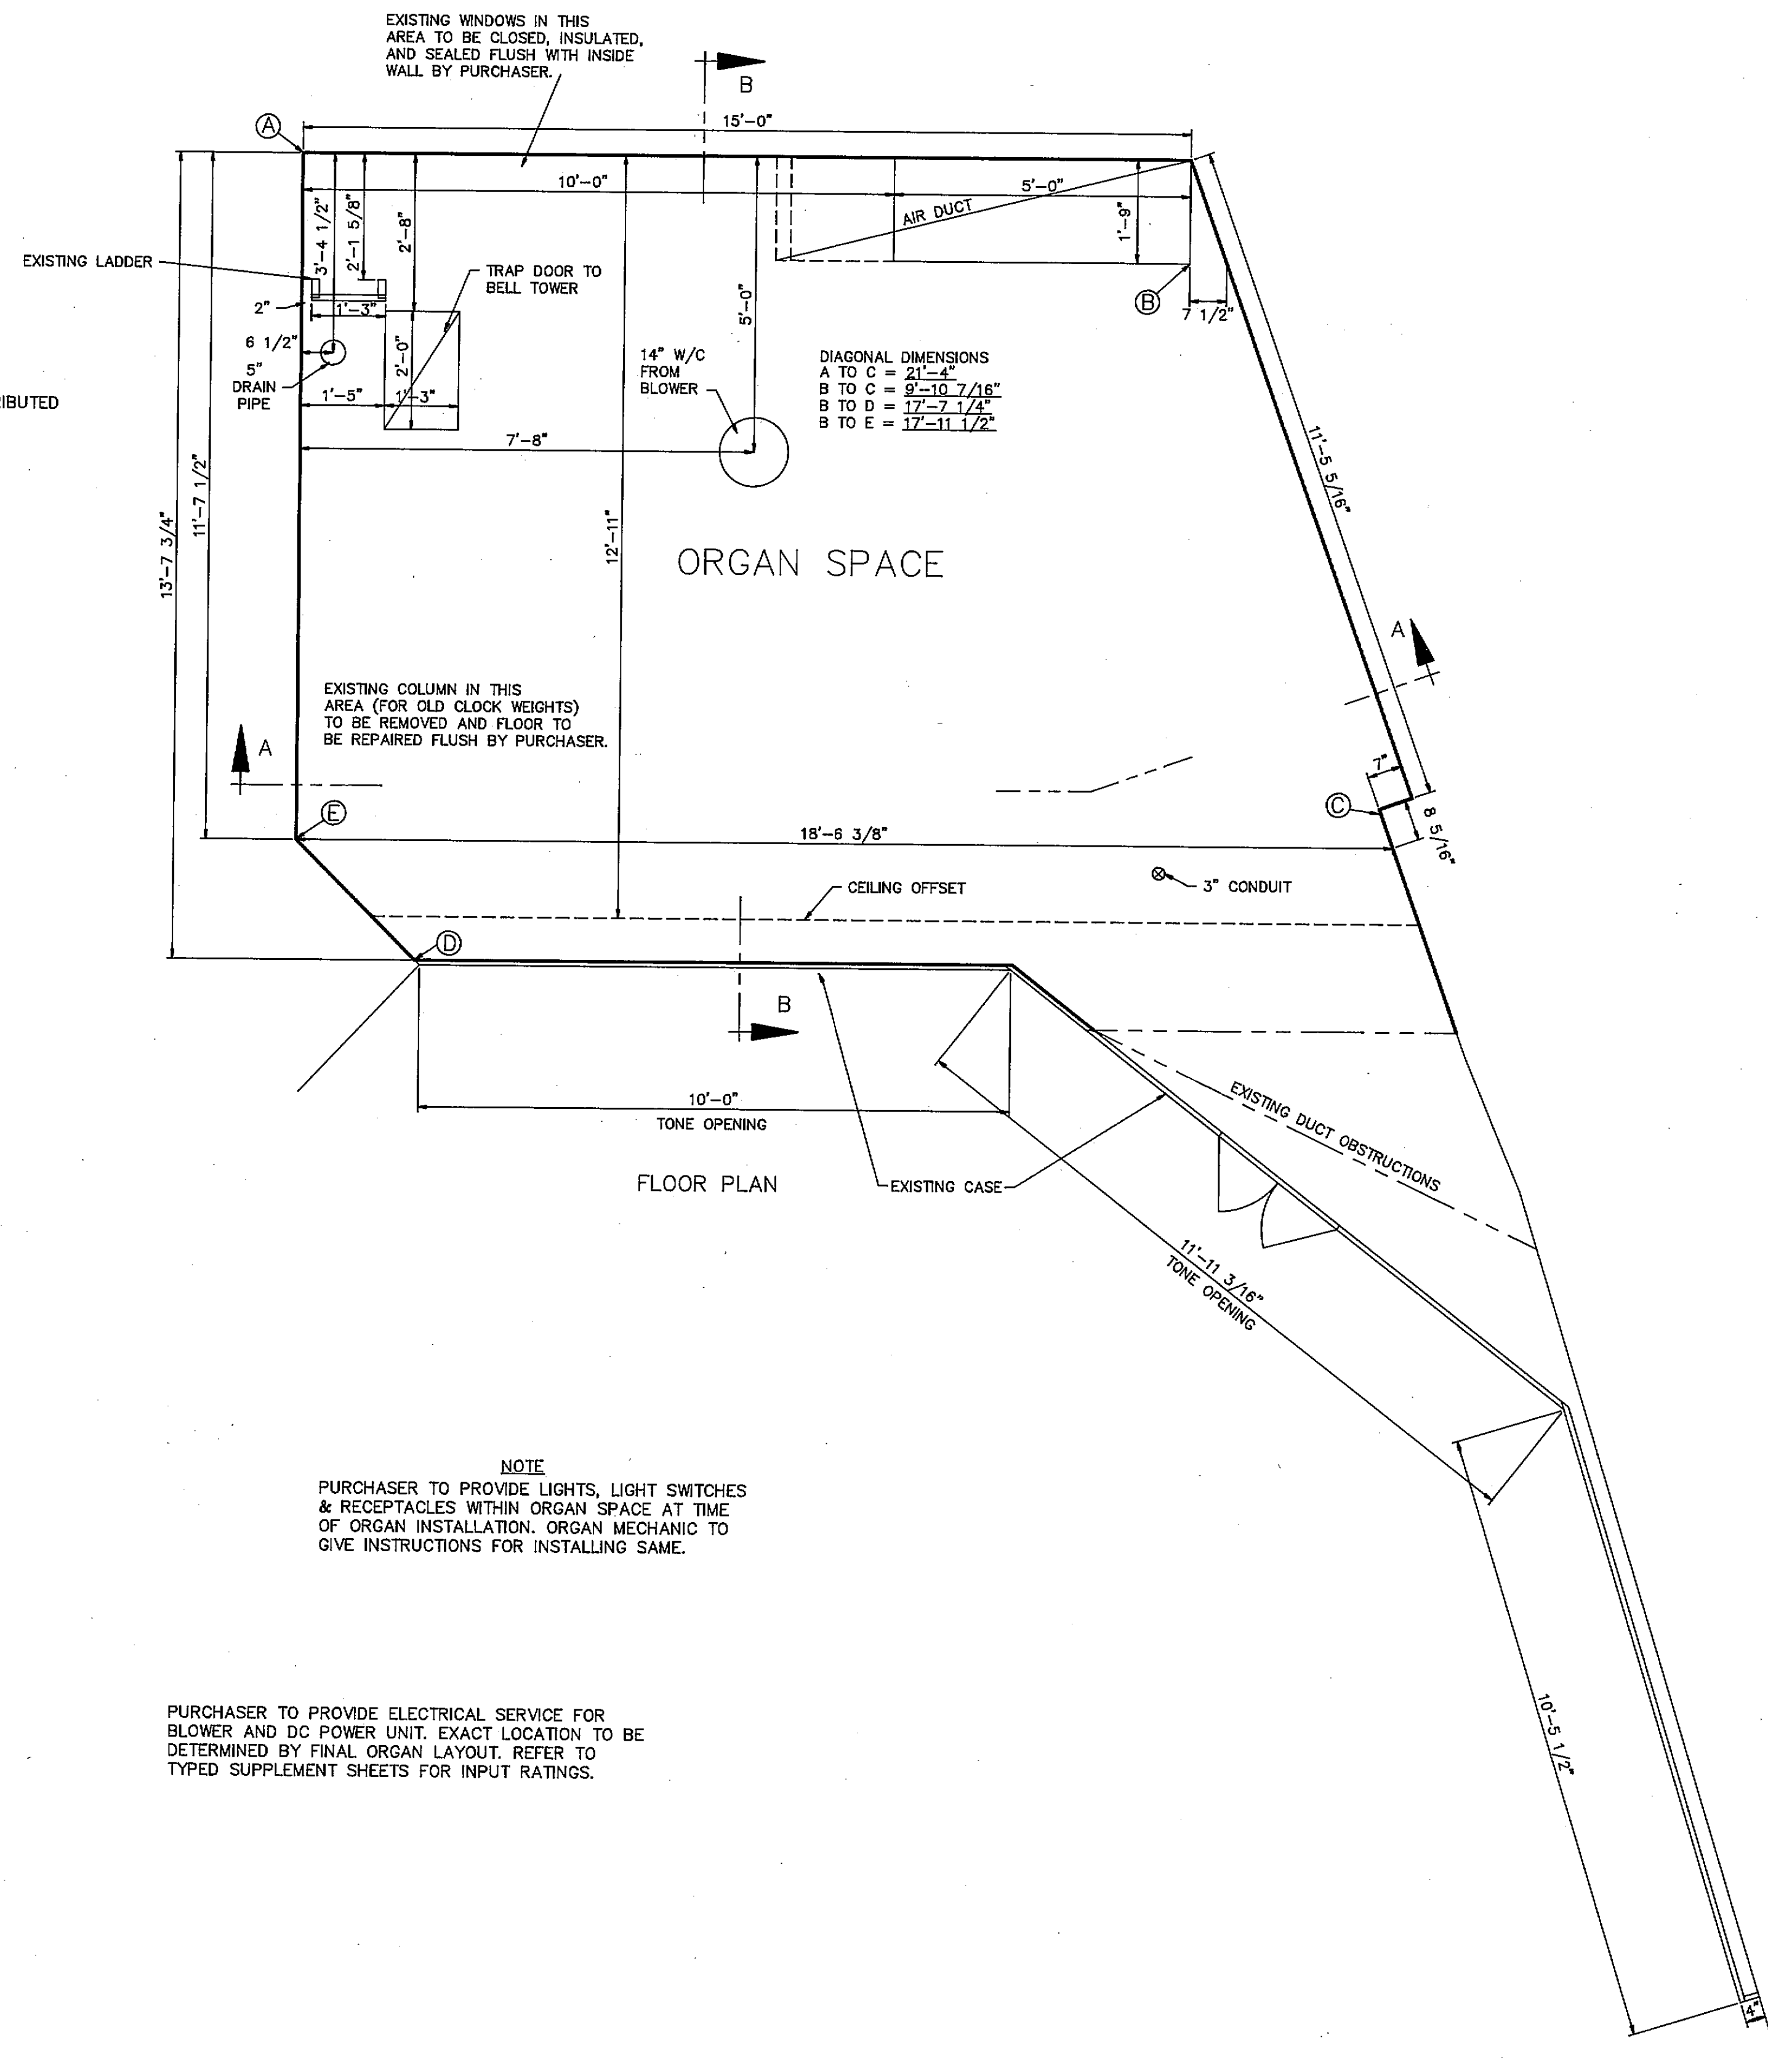


ORGAN WEIGHT  
APPROX. 38,000 LBS. DISTRIBUTED  
OVER ORGAN FLOOR

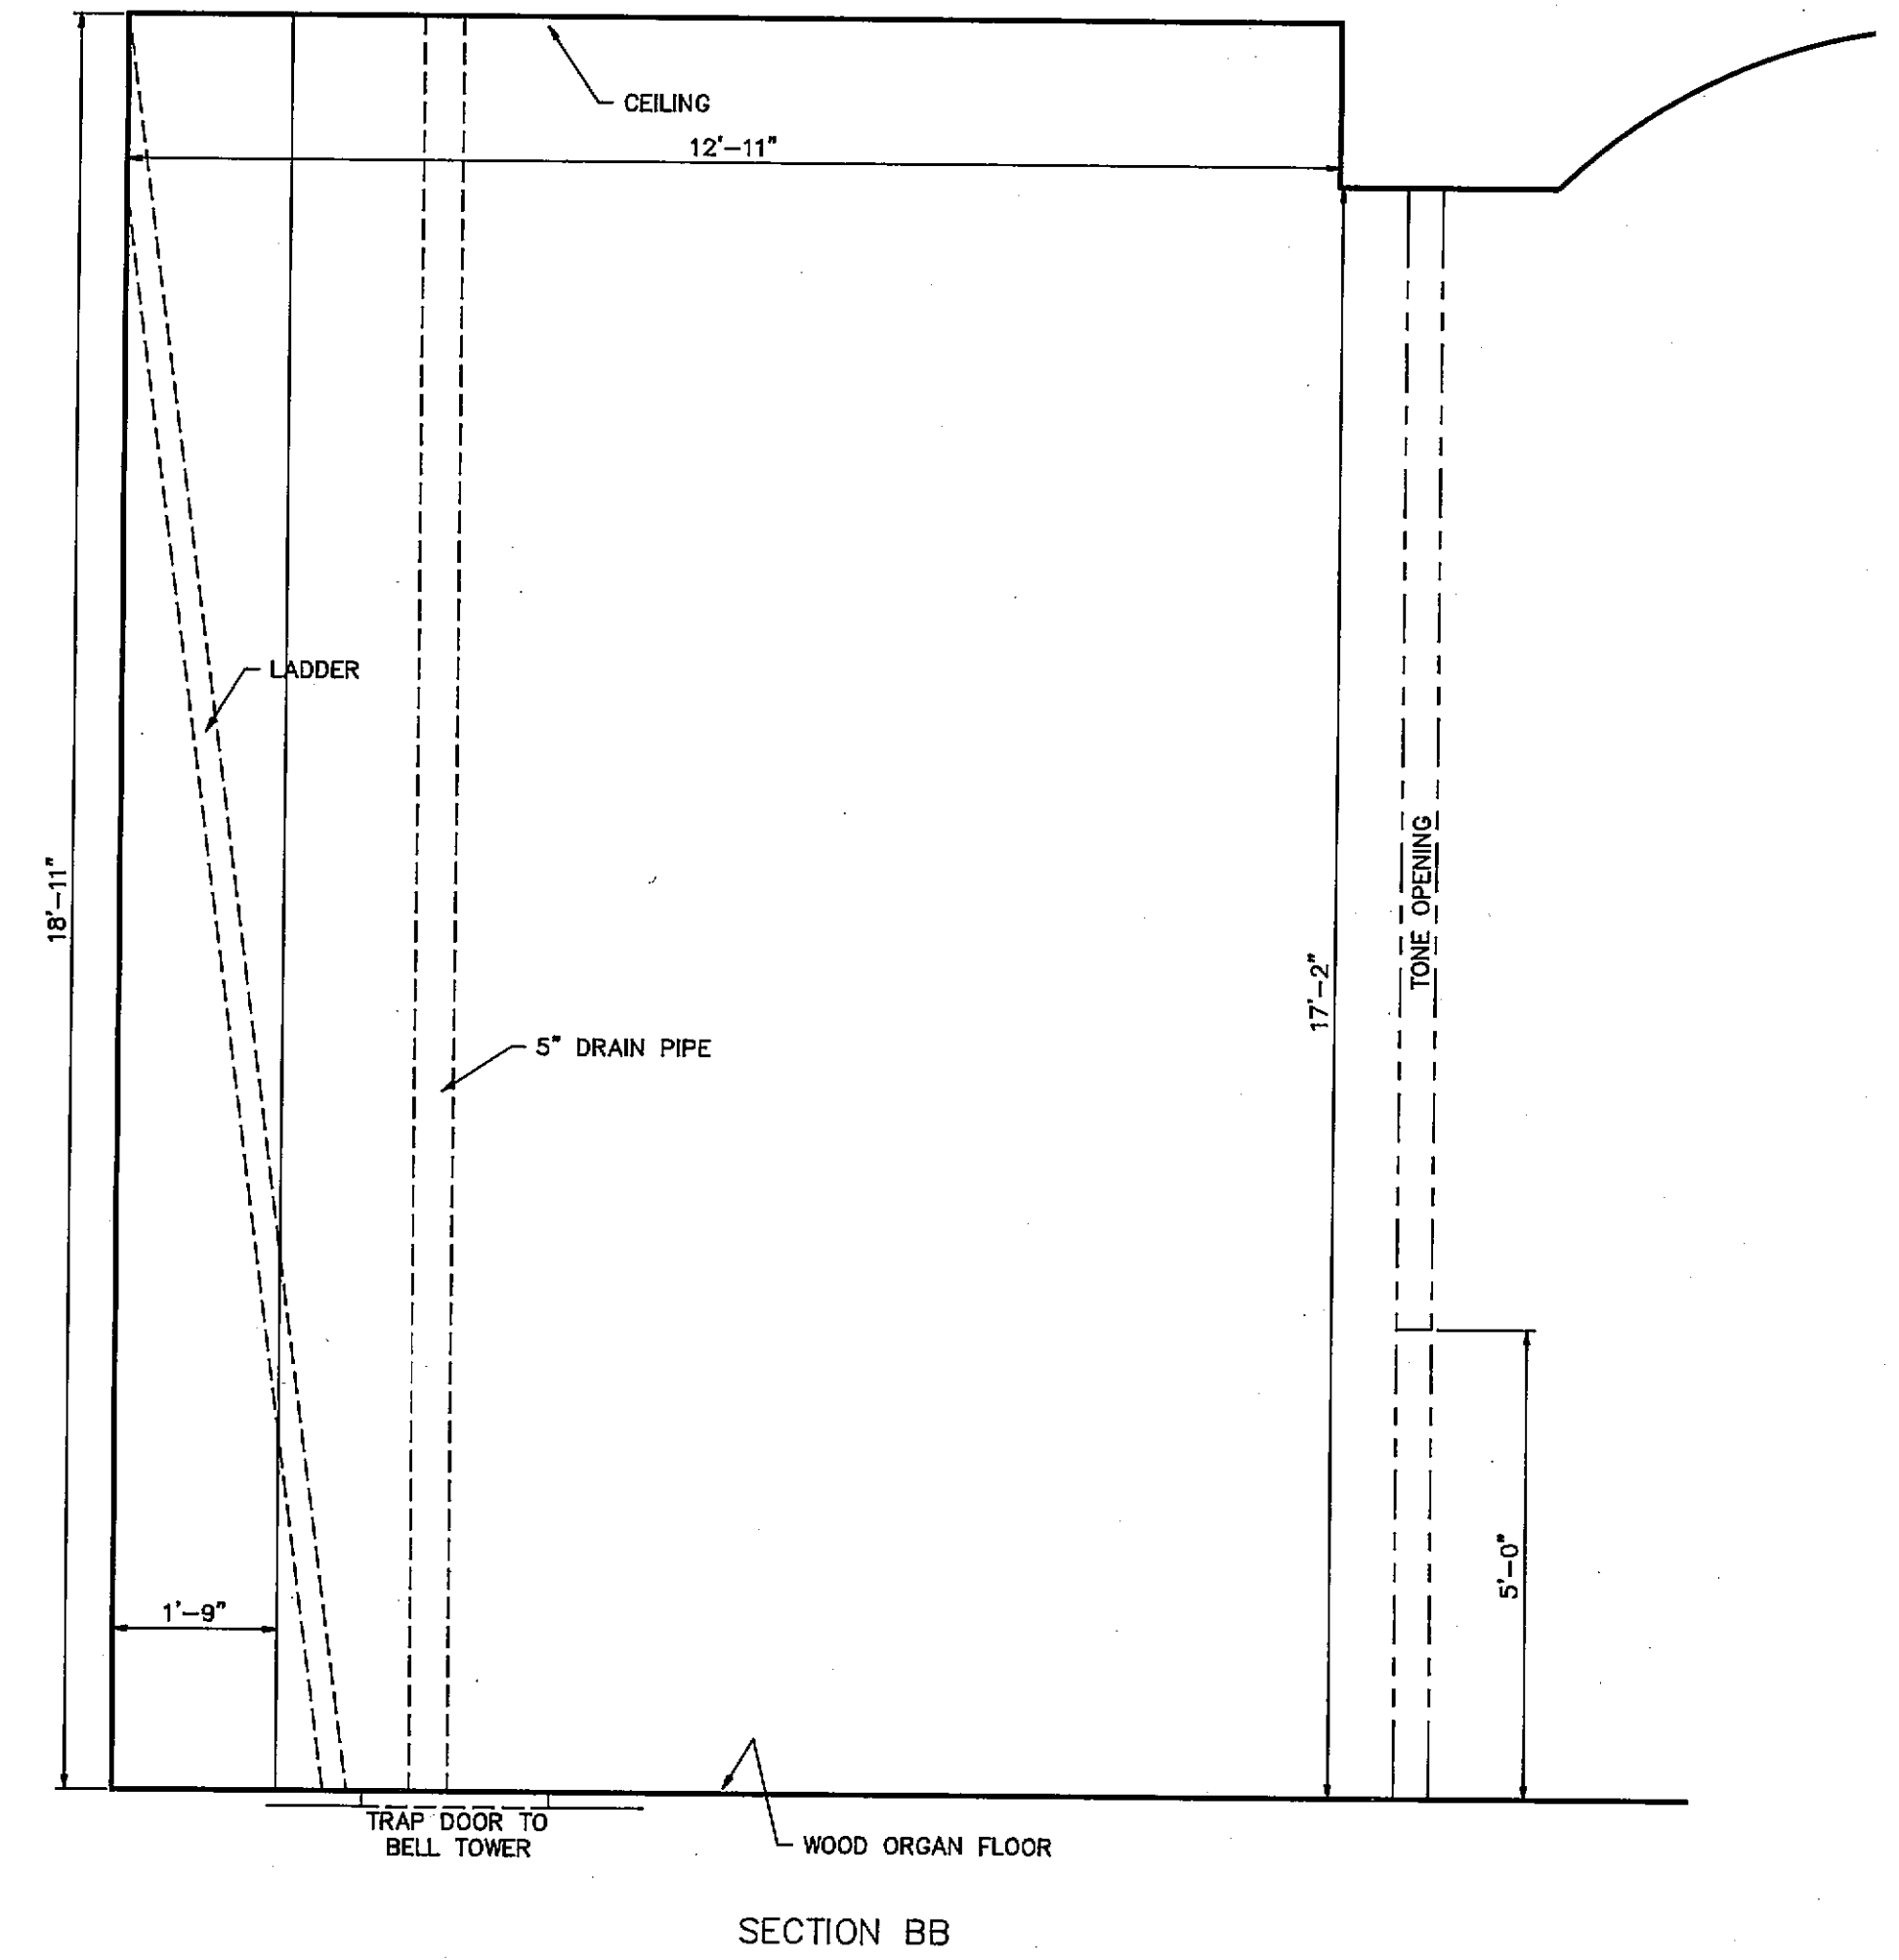

NOTE  
PURCHASER TO PROVIDE LIGHTS, LIGHT SWITCHES & RECEPTACLES WITHIN ORGAN SPACE AT TIME OF ORGAN INSTALLATION. ORGAN MECHANIC TO GIVE INSTRUCTIONS FOR INSTALLING SAME.

PURCHASER TO PROVIDE ELECTRICAL SERVICE FOR BLOWER AND DC POWER UNIT. EXACT LOCATION TO BE DETERMINED BY FINAL ORGAN LAYOUT. REFER TO TYPED SUPPLEMENT SHEETS FOR INPUT RATINGS.

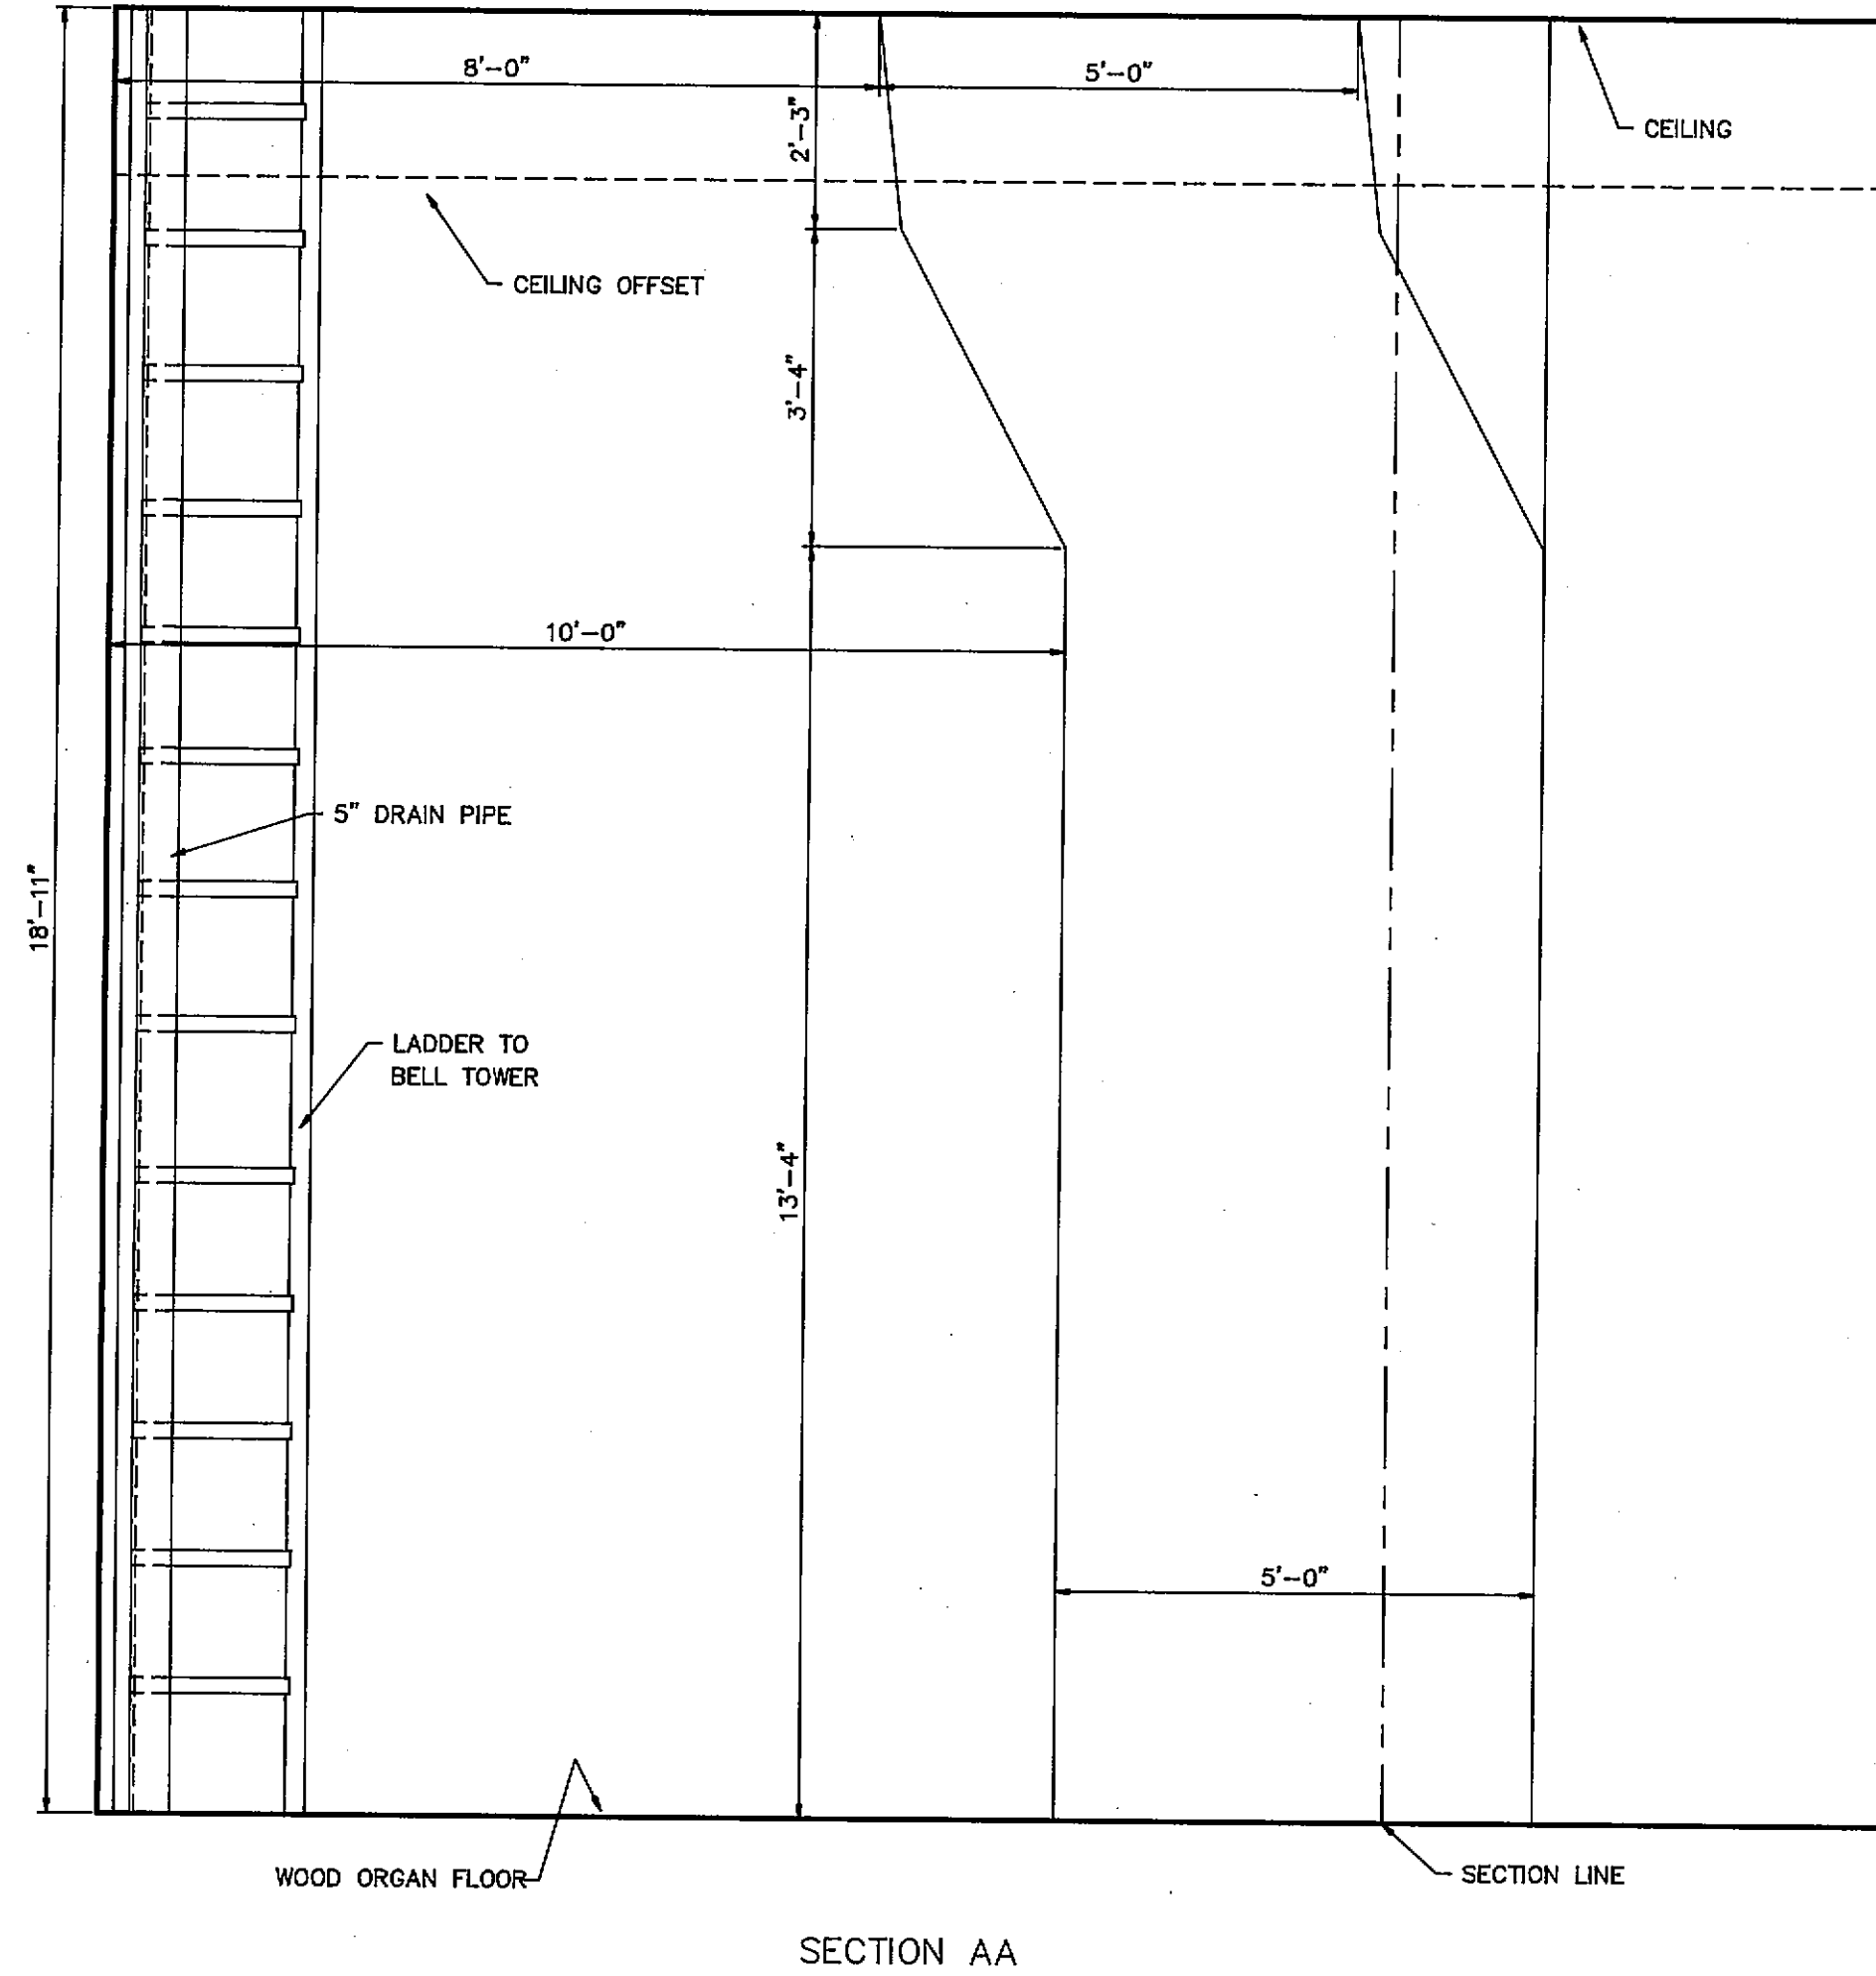


ORGAN SPACE  
(FLOOR PLAN & SECTION)

DIMENSIONS OK\_PHL FABRY / SLH DATE 1-8-90  
5-8-90


FIRST UNITED METHODIST CHURCH  
BATTLE CREEK, MICHIGAN

SCALE 1/2" = 1'-0"	M. P. Moller INCORPORATED HAGERSTOWN, MD.	11801
CK'D DRAWN DATE		
SLH 6-5-90		


DRAWING NO. 101

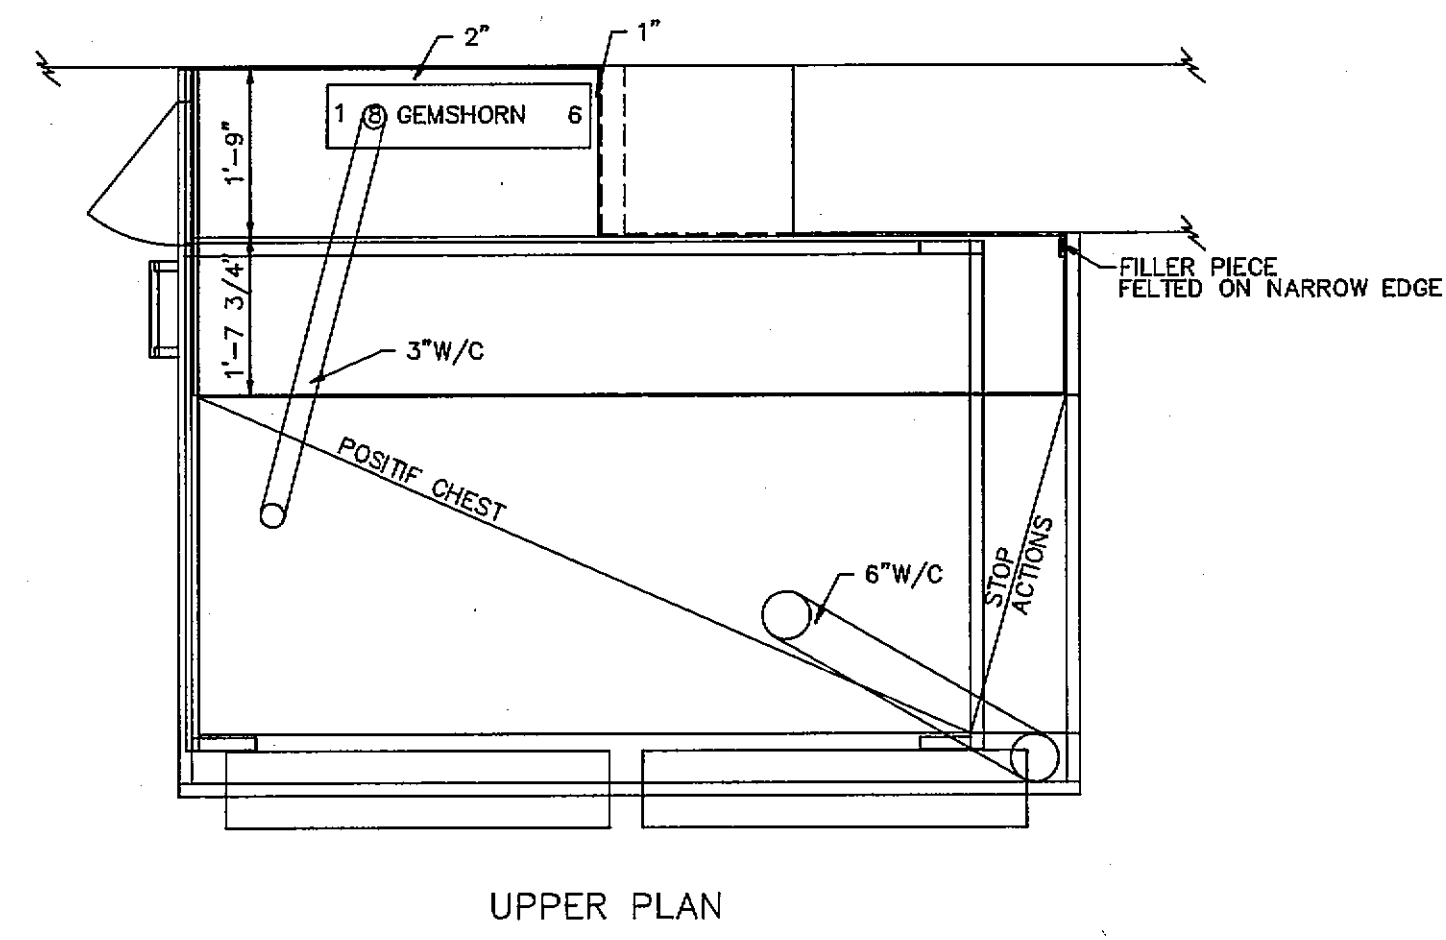


UPPER PLAN

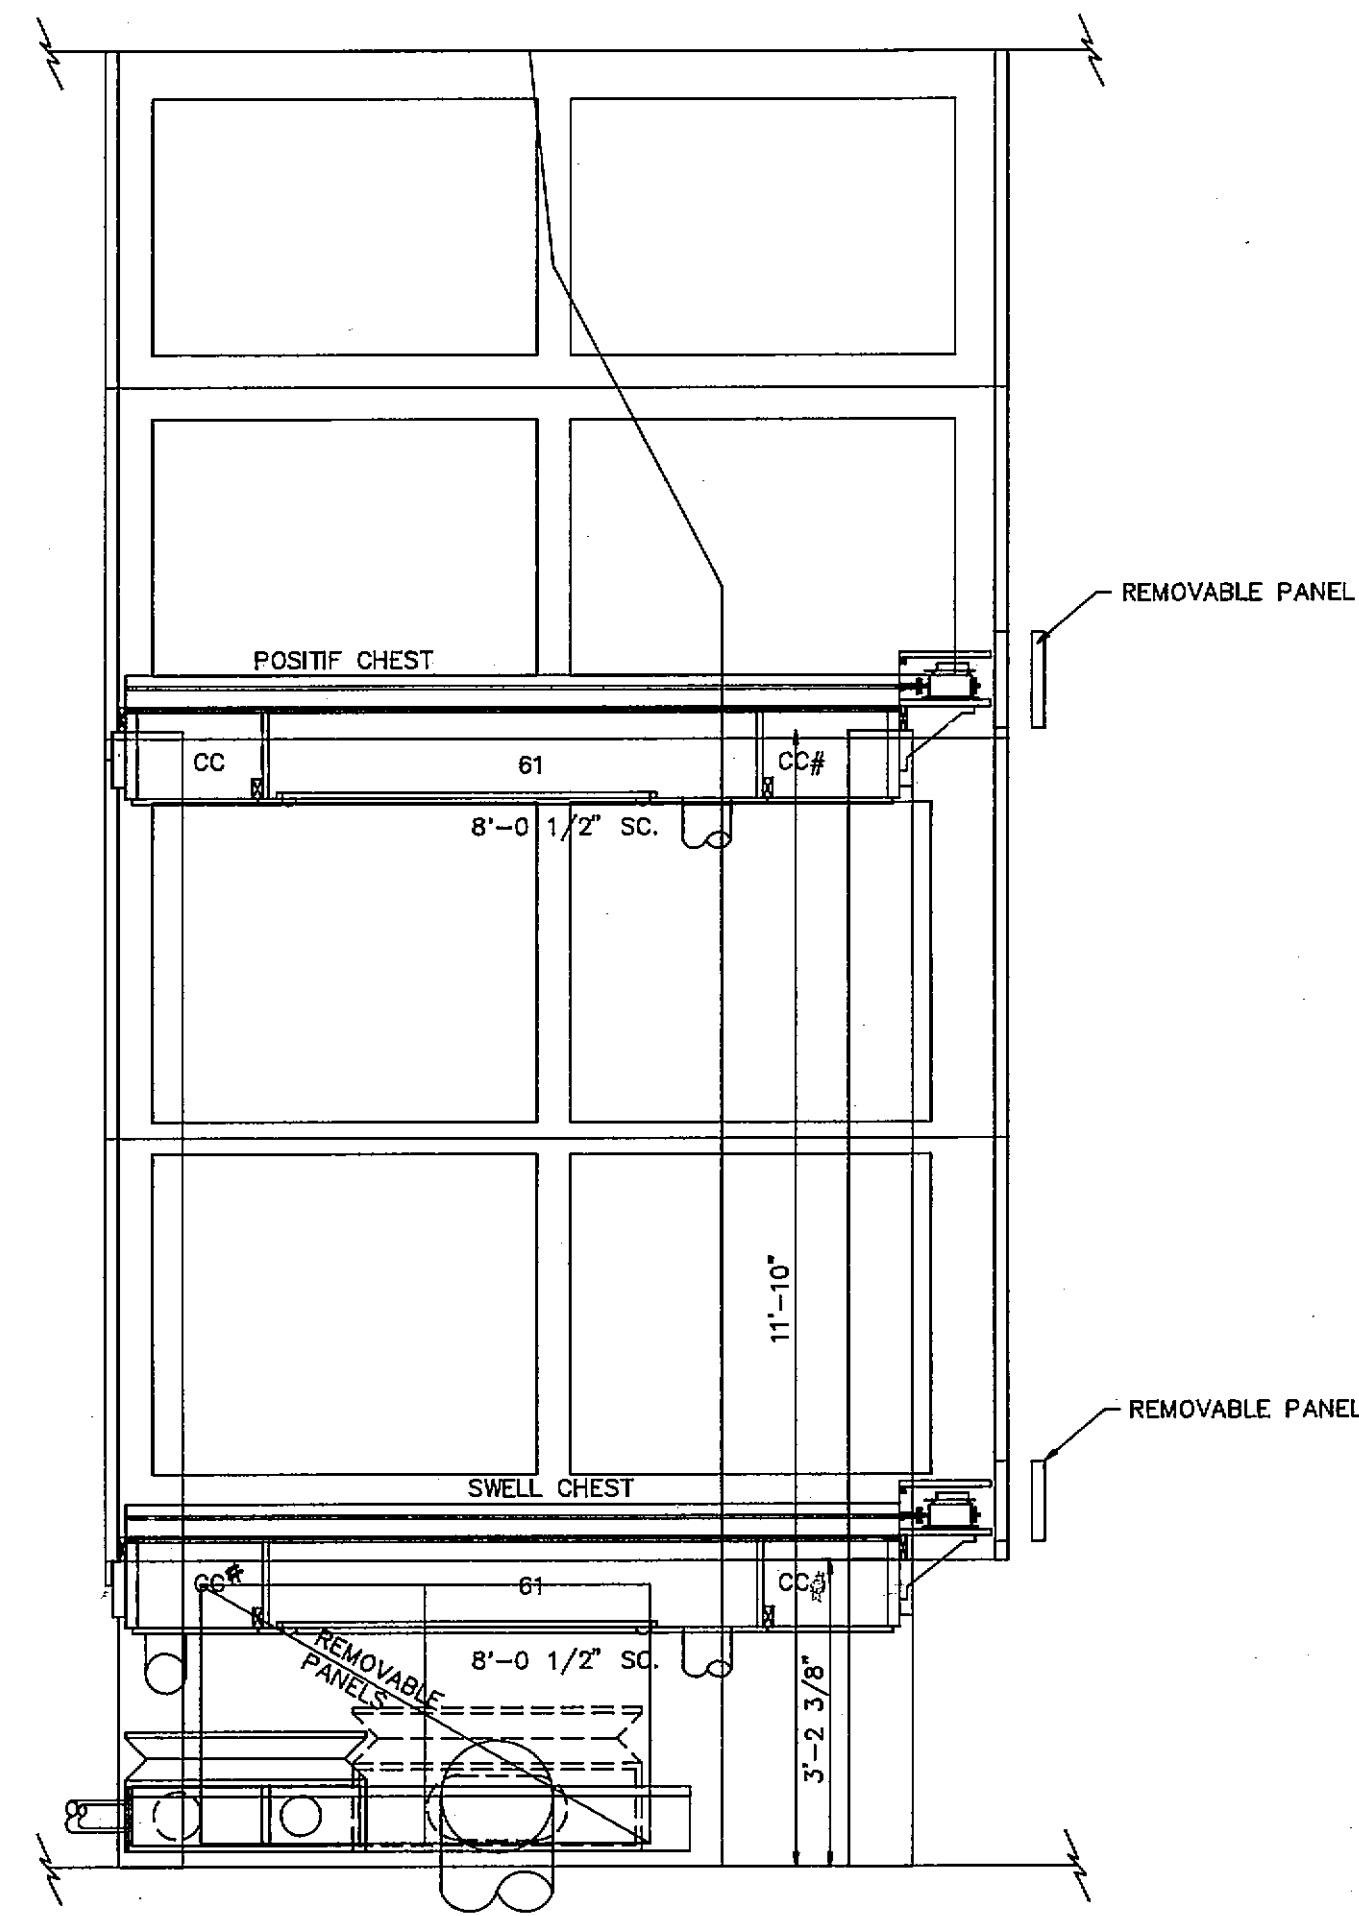


SECTION CC

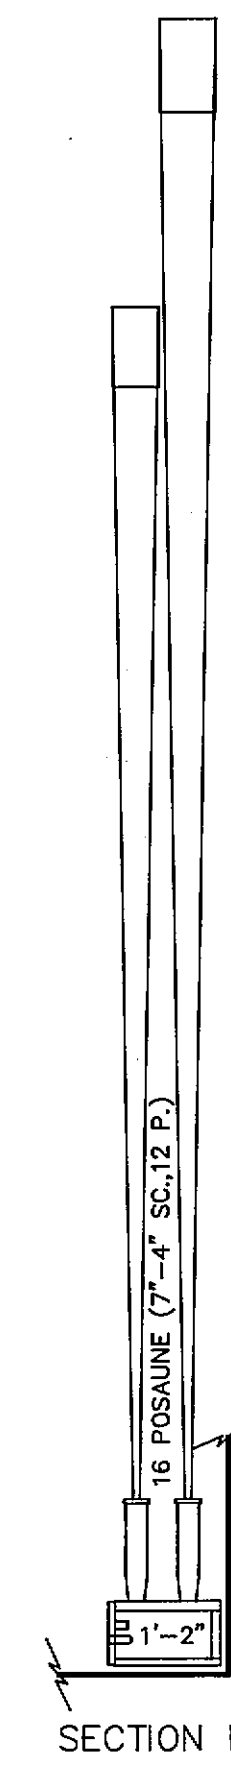


SECTION D

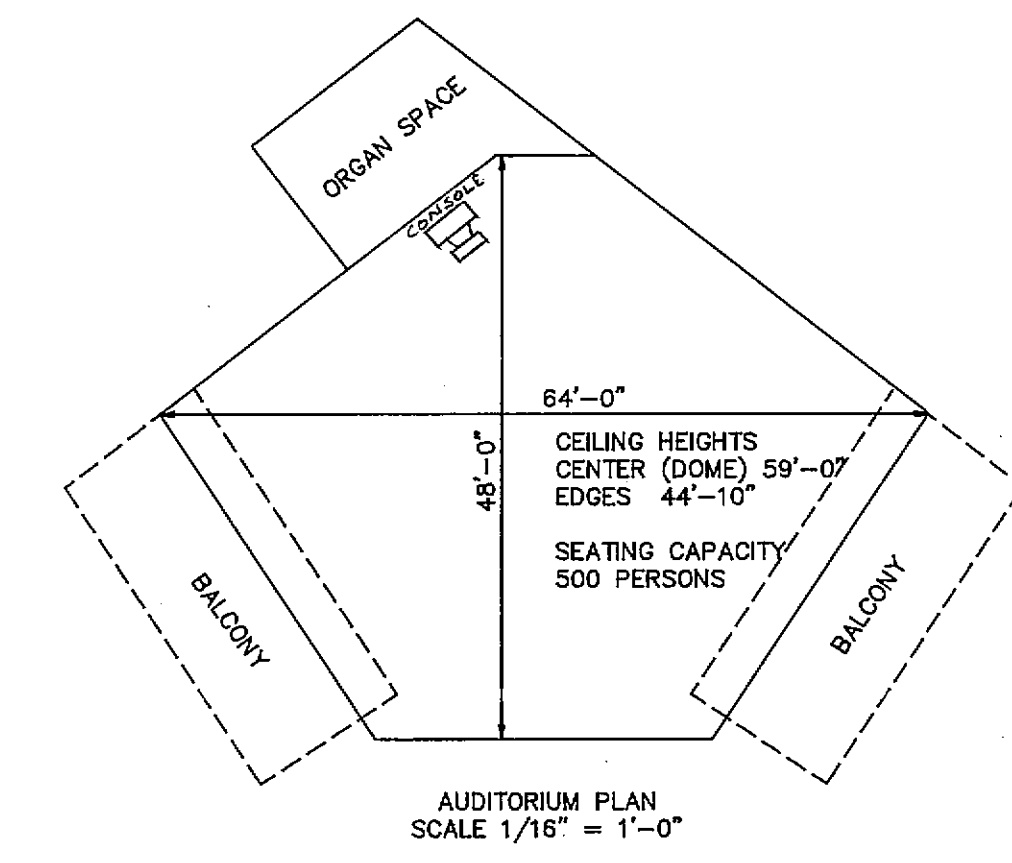


AUDITORIUM PLAN  
SCALE 1/16" = 1'-0"

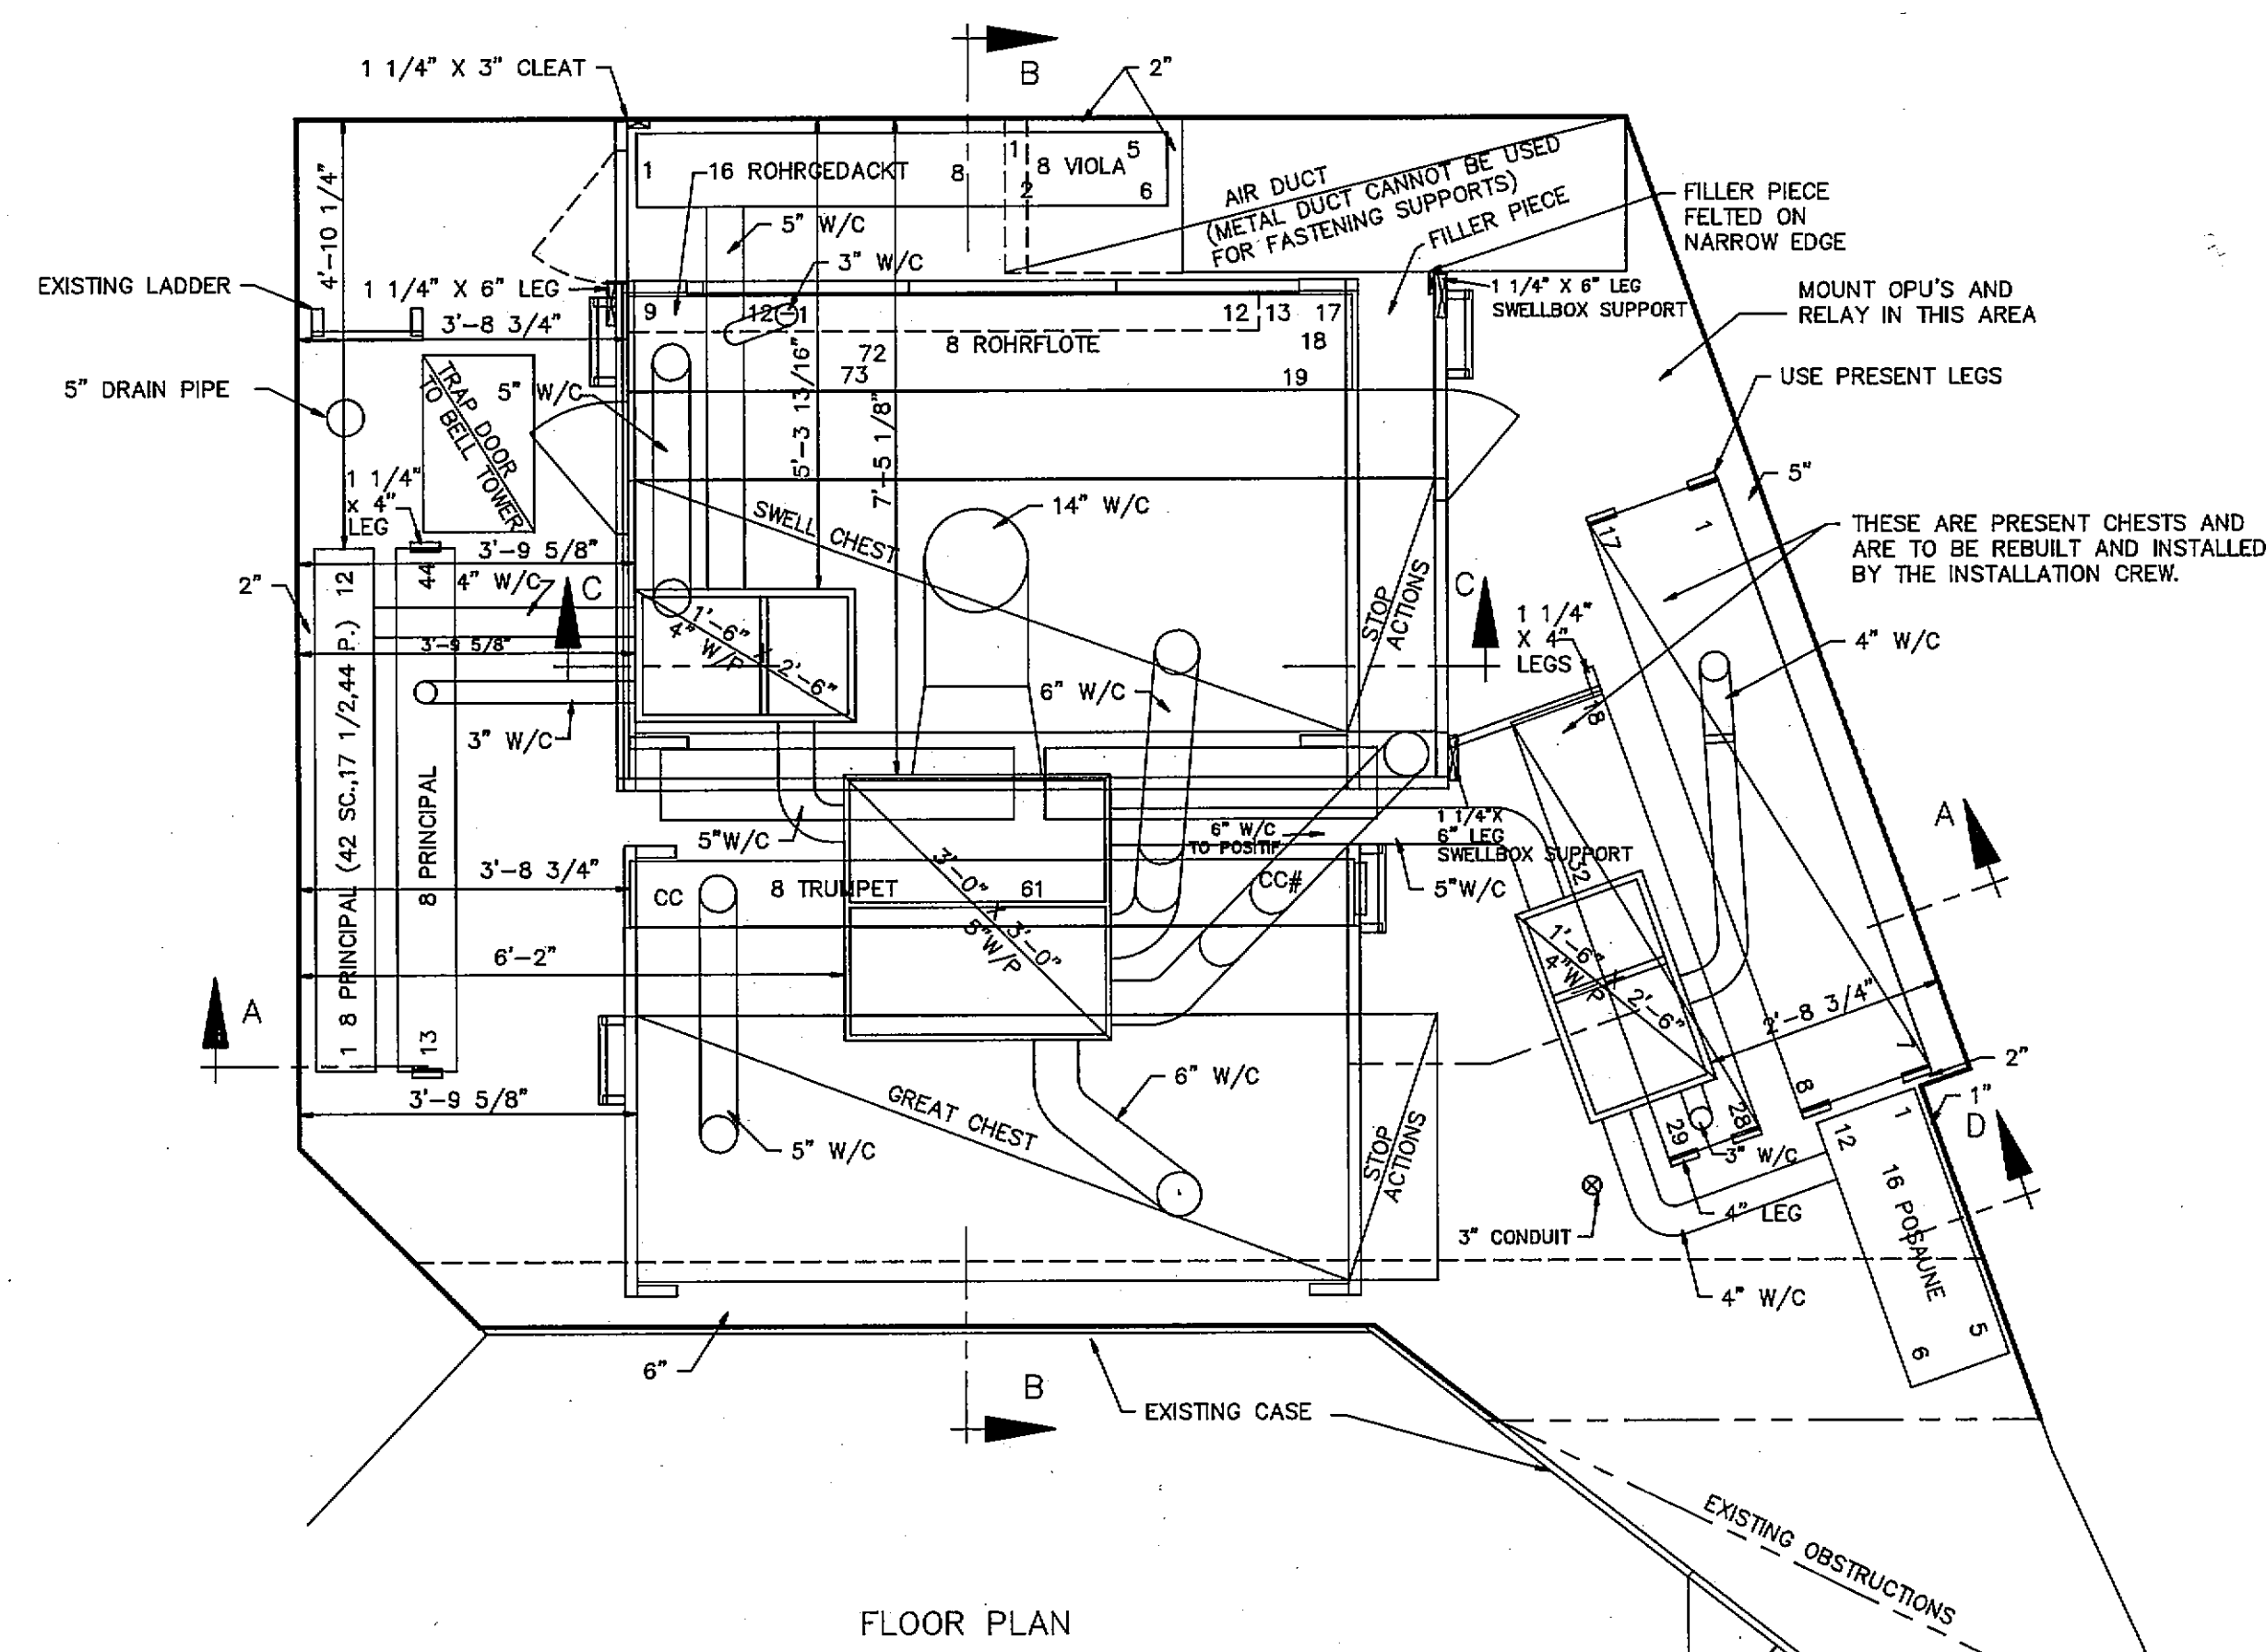

FLOOR PLAN

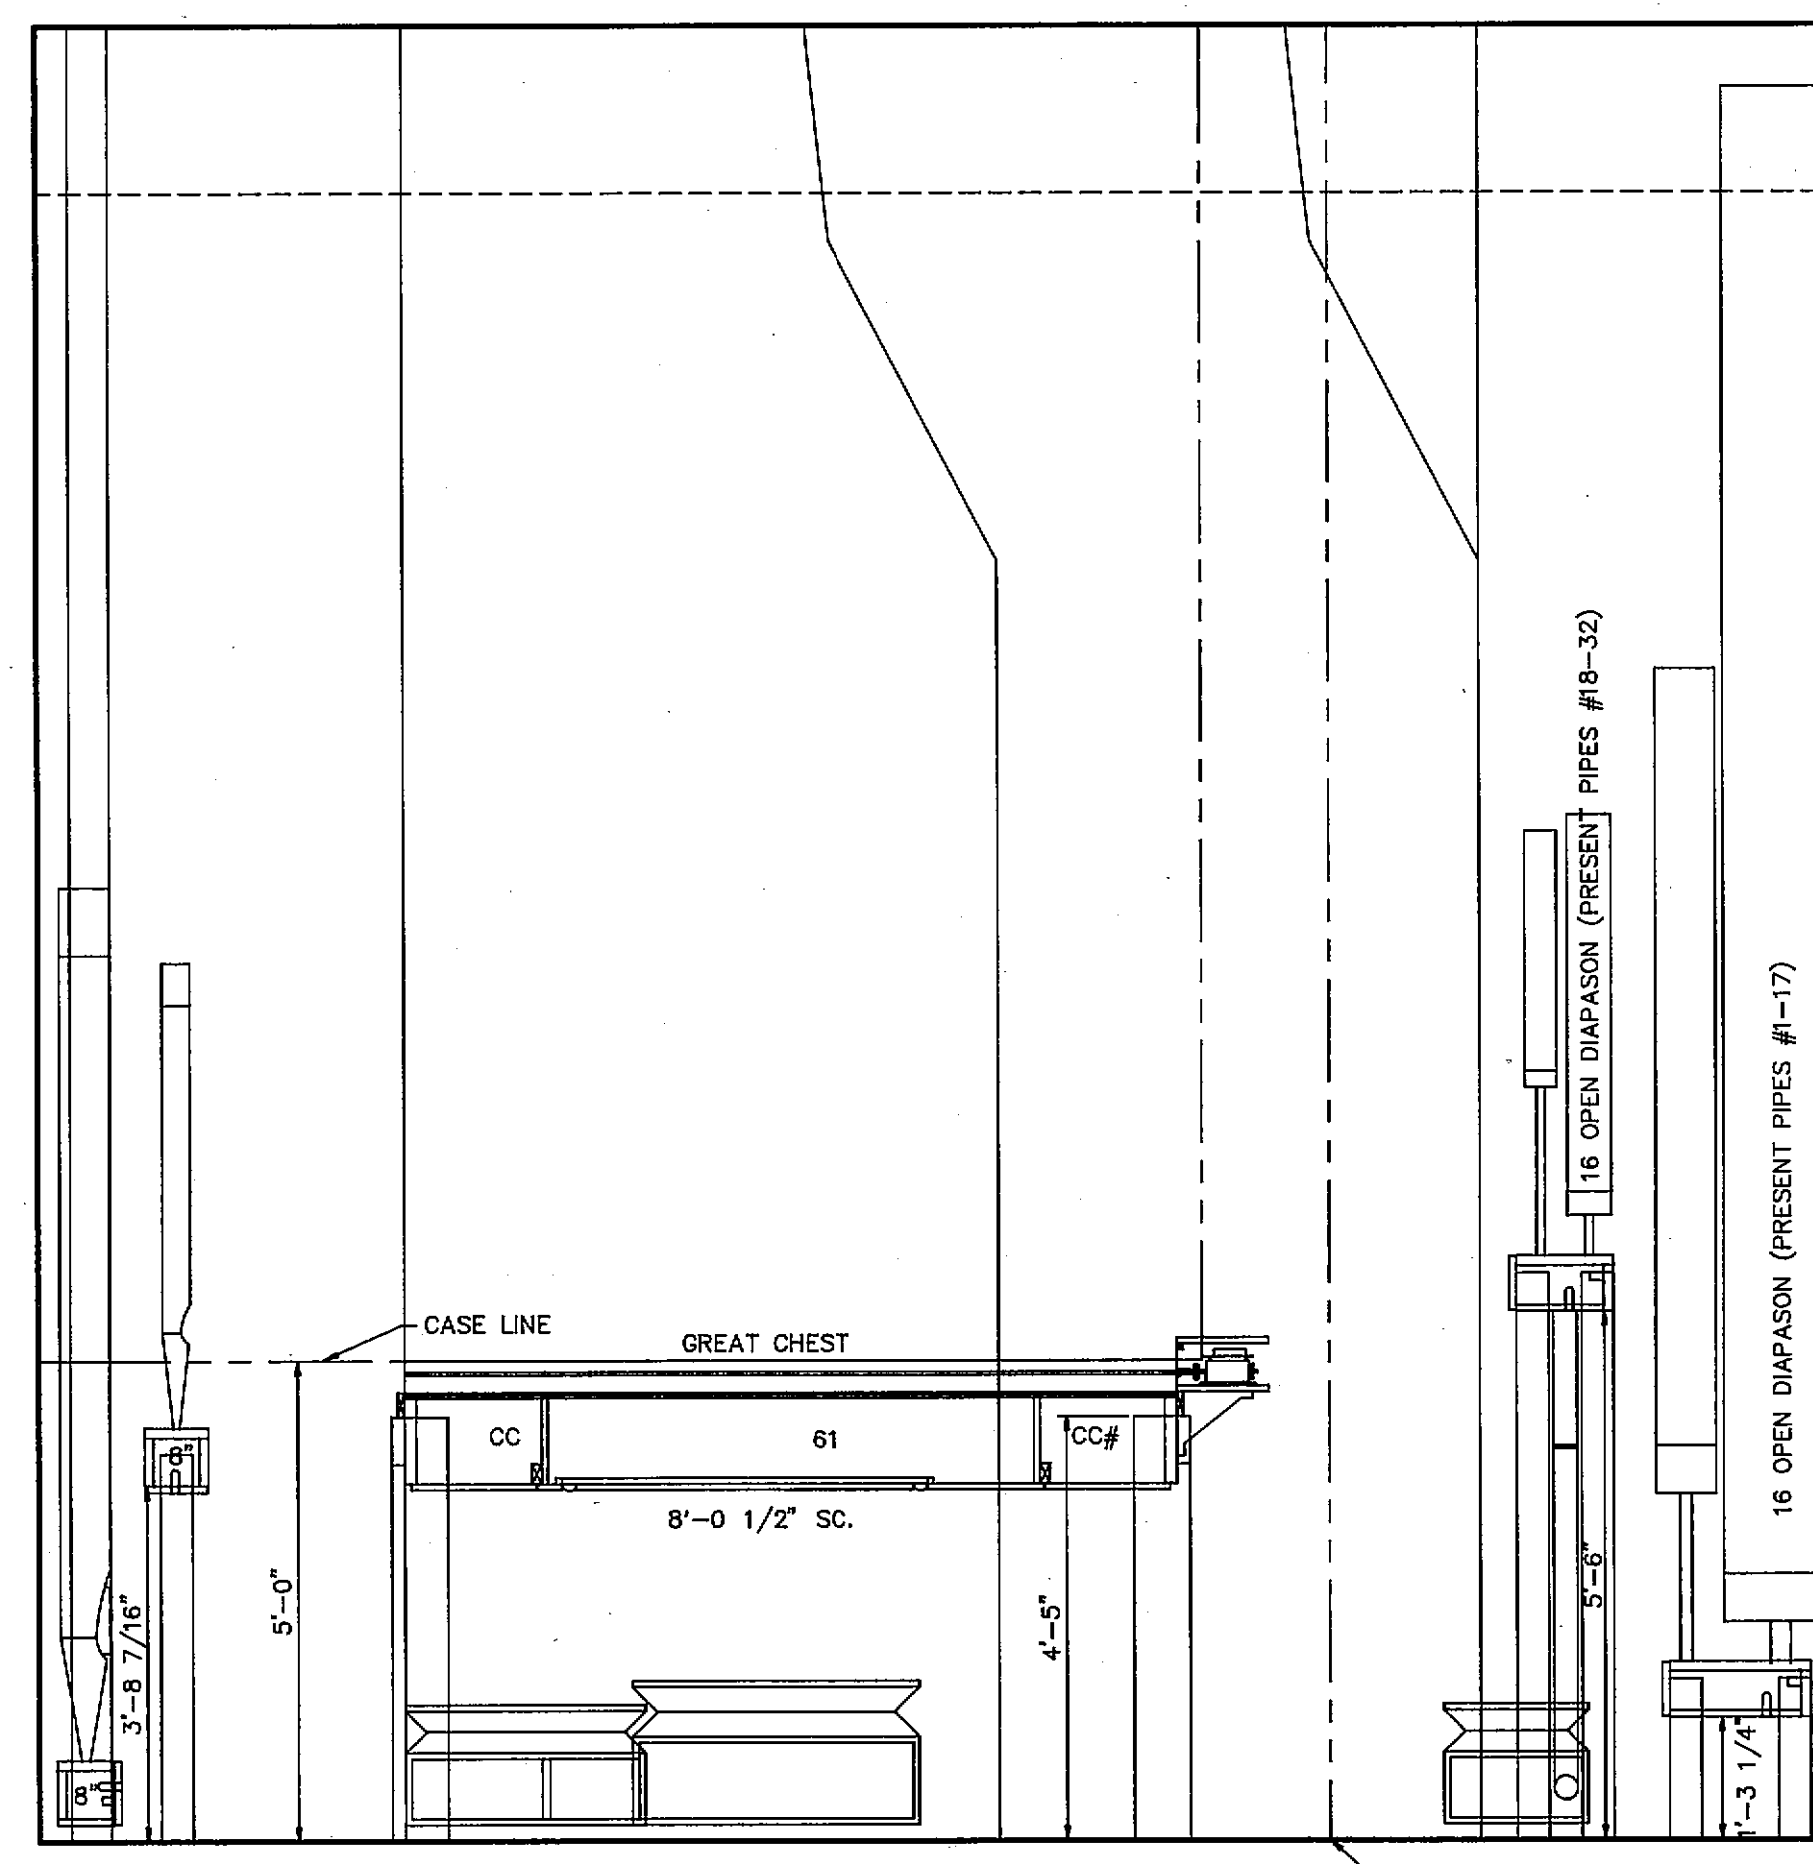

SECTION AA

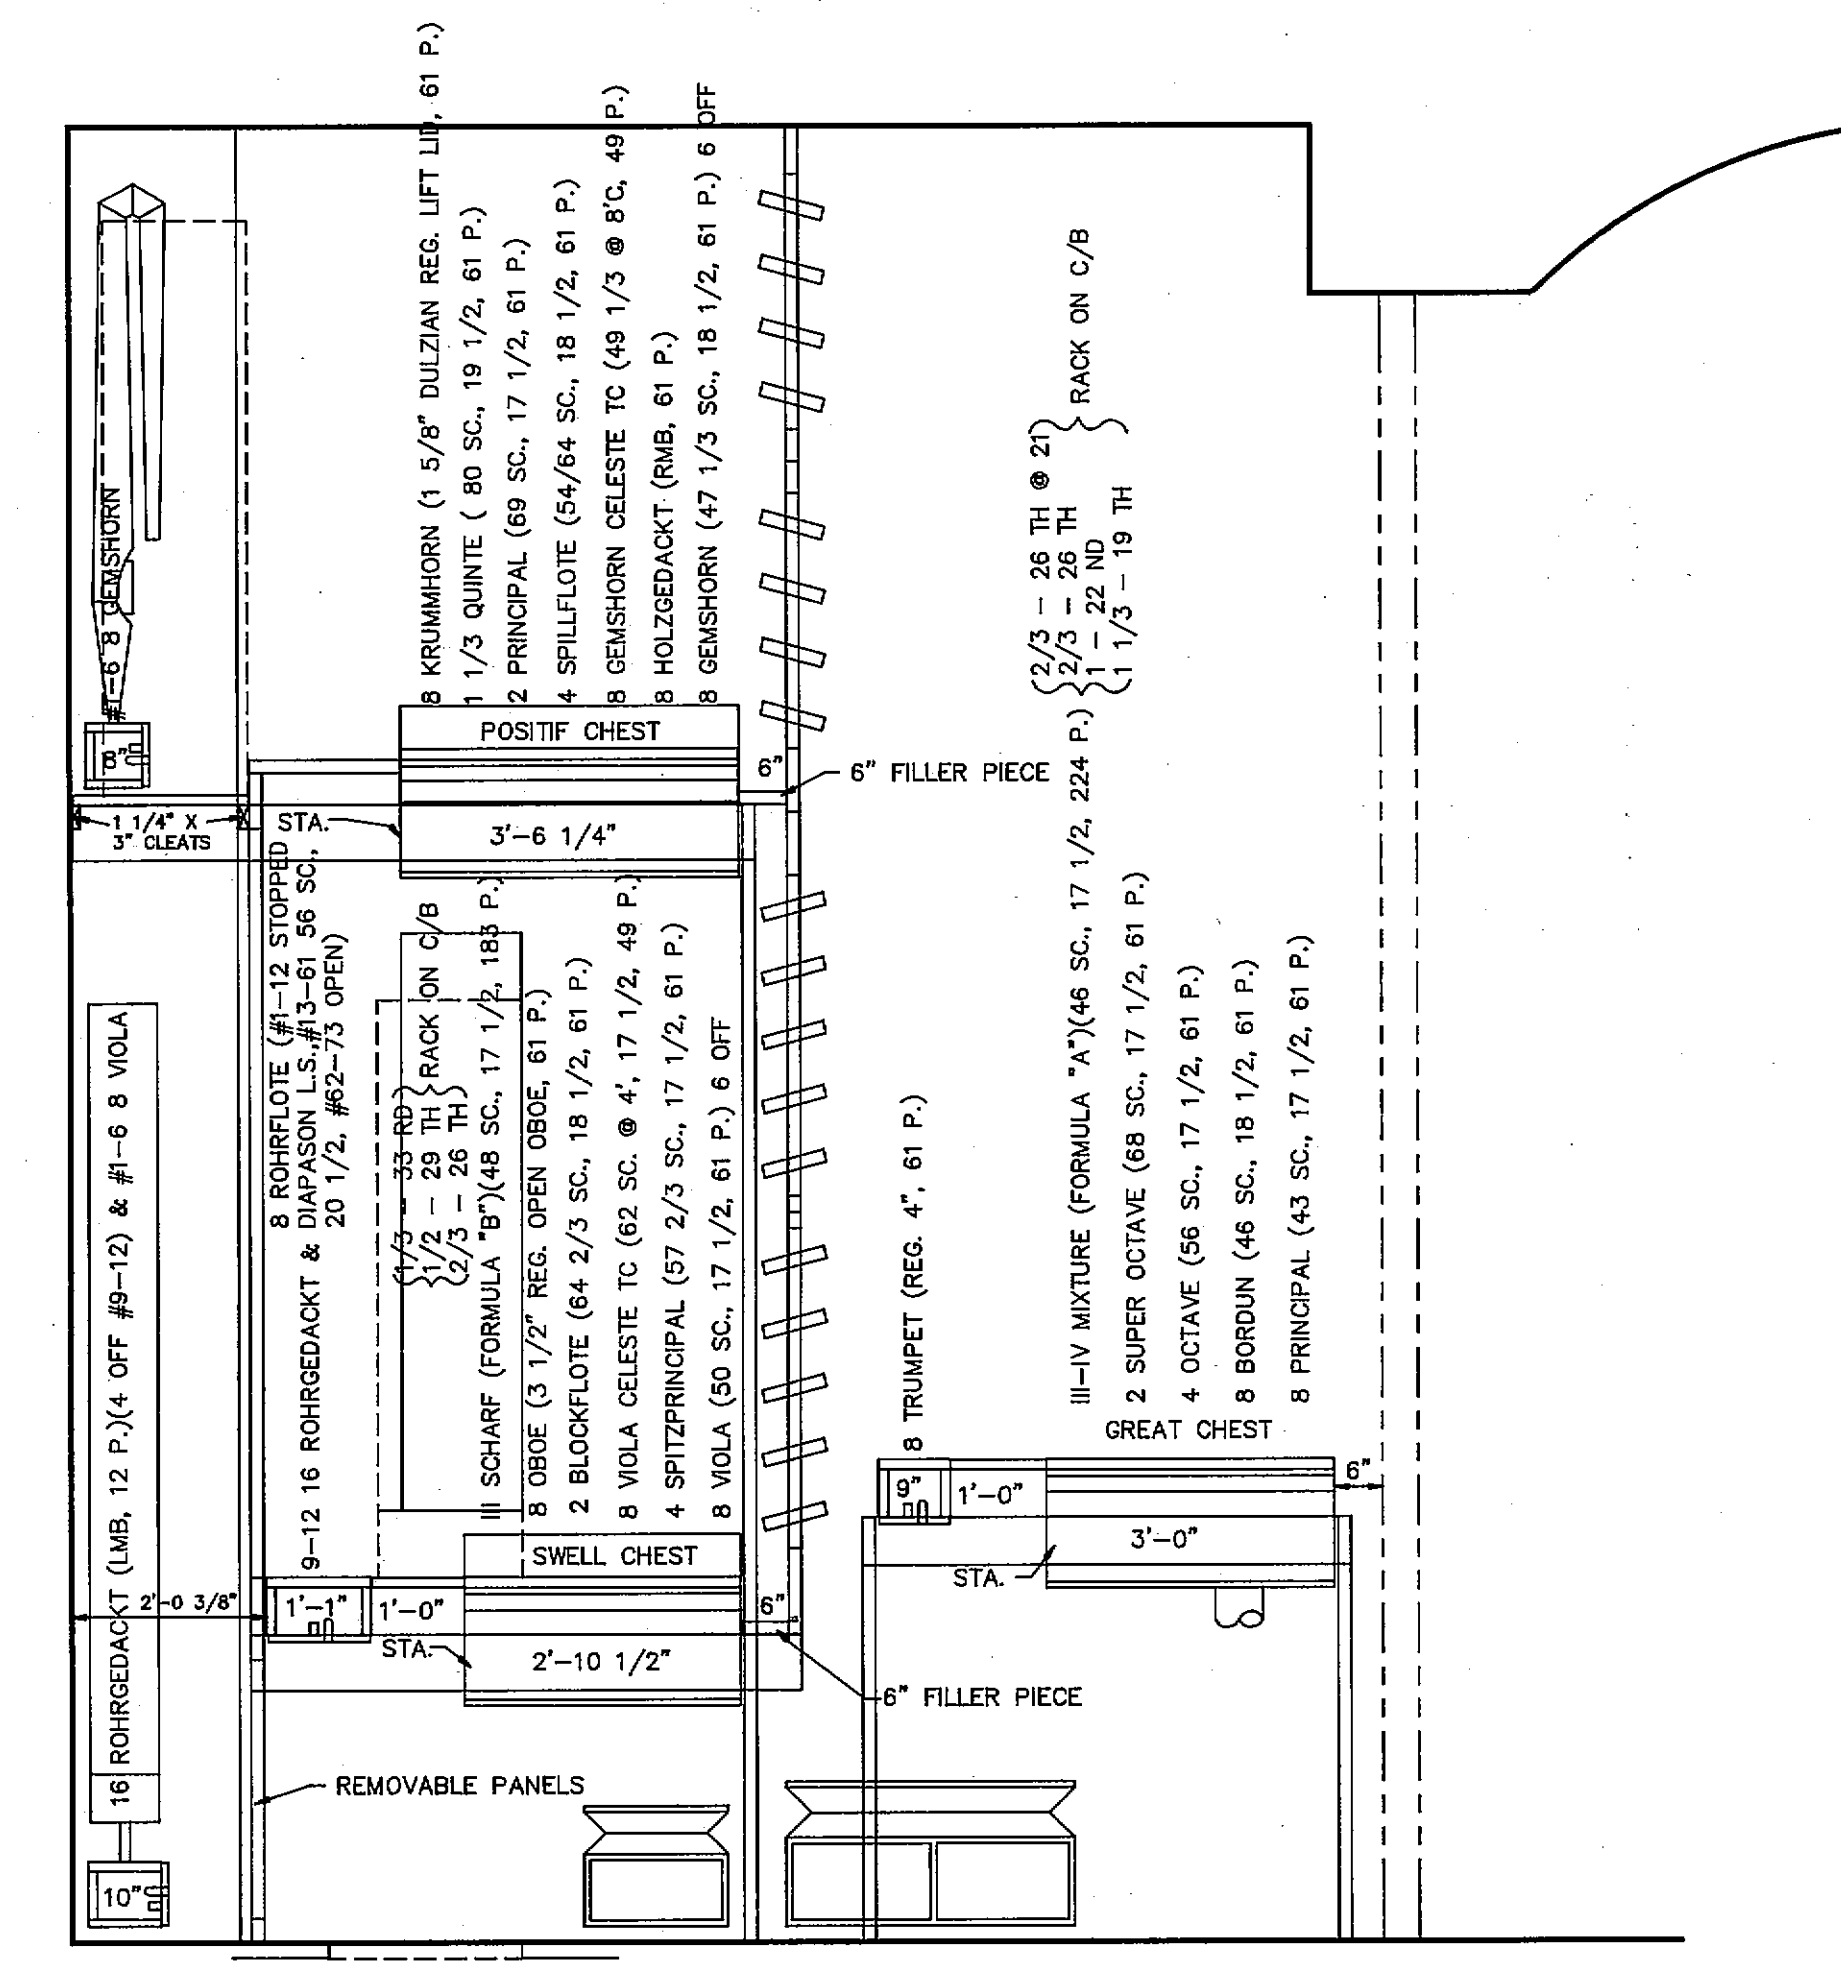


SECTION BB

FOR ADDITIONAL INFORMATION SEE TYPED SUPPLEMENT SHEETS DATED 8-2-50


LAYOUT AND SECTIONS

FIRST UNITED METHODIST CHURCH  
BATTLE CREEK, MICHIGAN

SCALE: 1/2" = 1'-0"	M. P. Miller 1808 BATTLE CREEK	11801
DRAWN DATE		
SH 8-5-50	HAGERSTOWN, MD.	

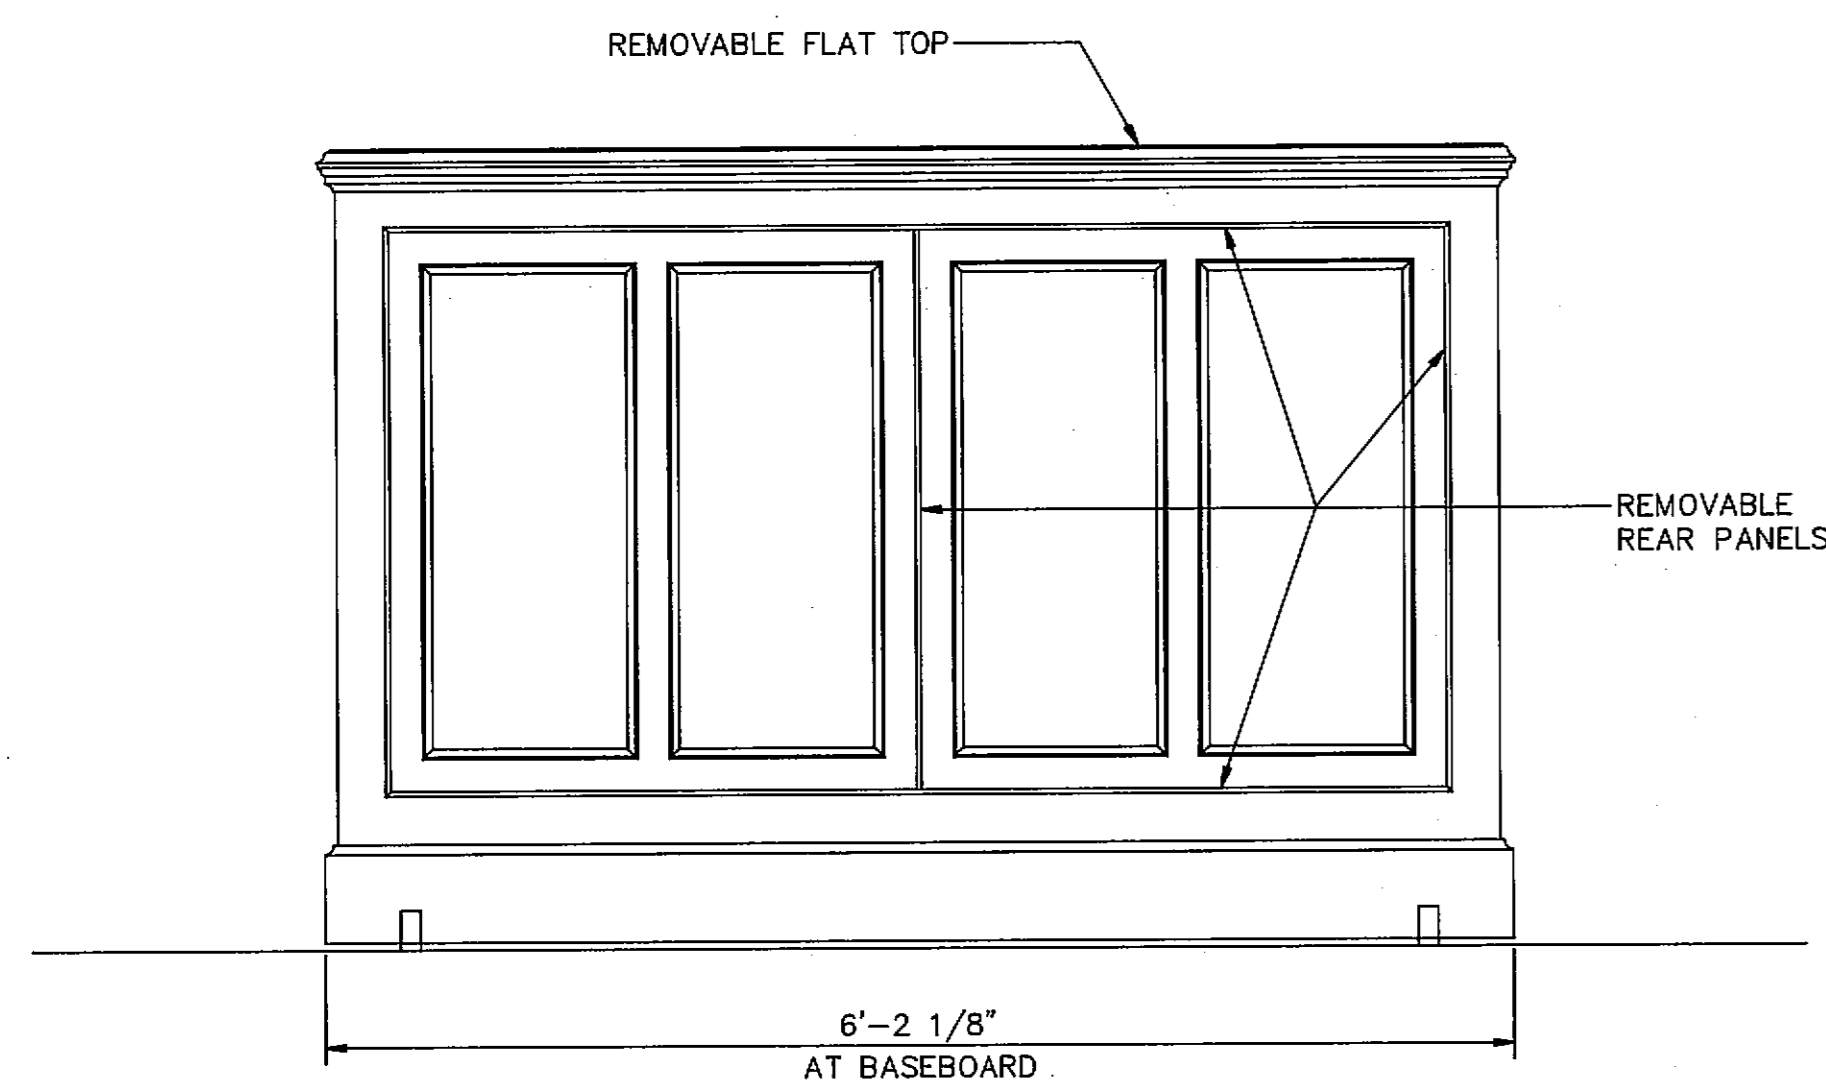


REAR VIEW

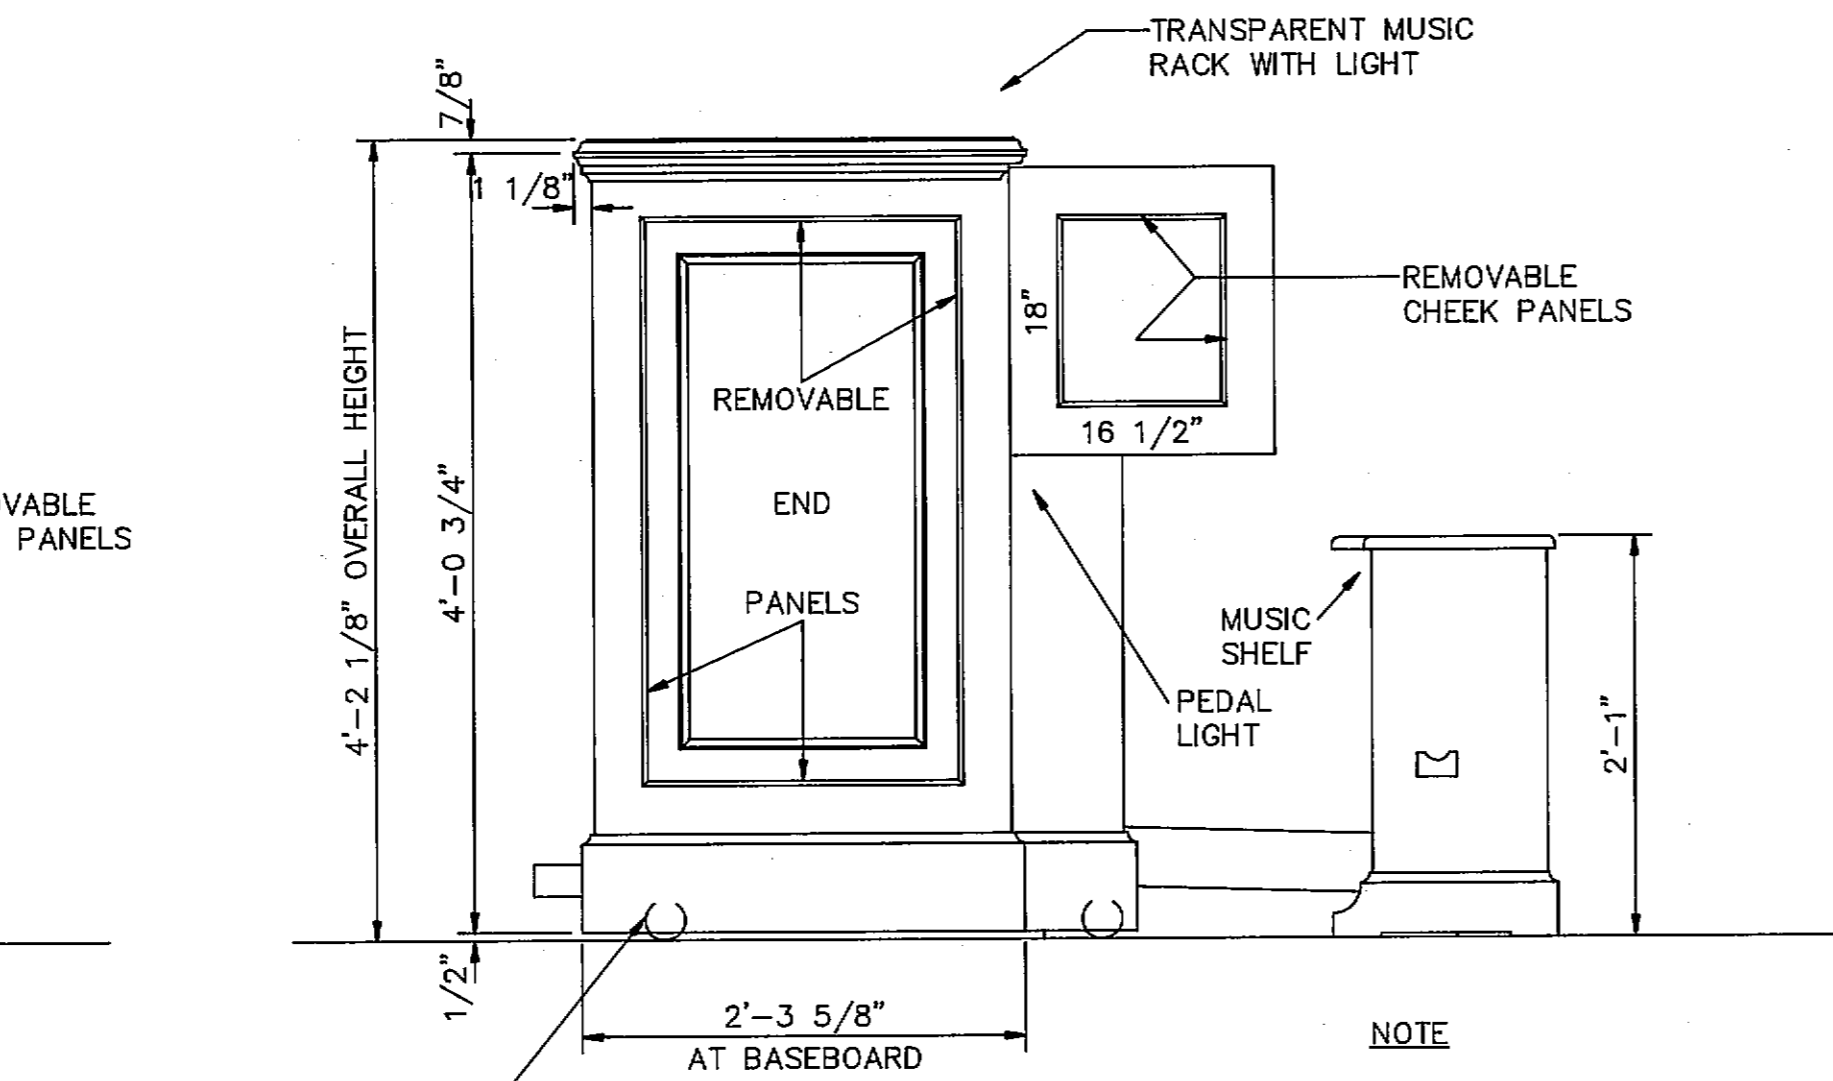


END VIEW


NOTE  
 PEDAL KEYS TO BE PROVIDED WITH DARNELL CASTERS MODEL 13-51-PADI-M-CI & SECURED TO CABINET

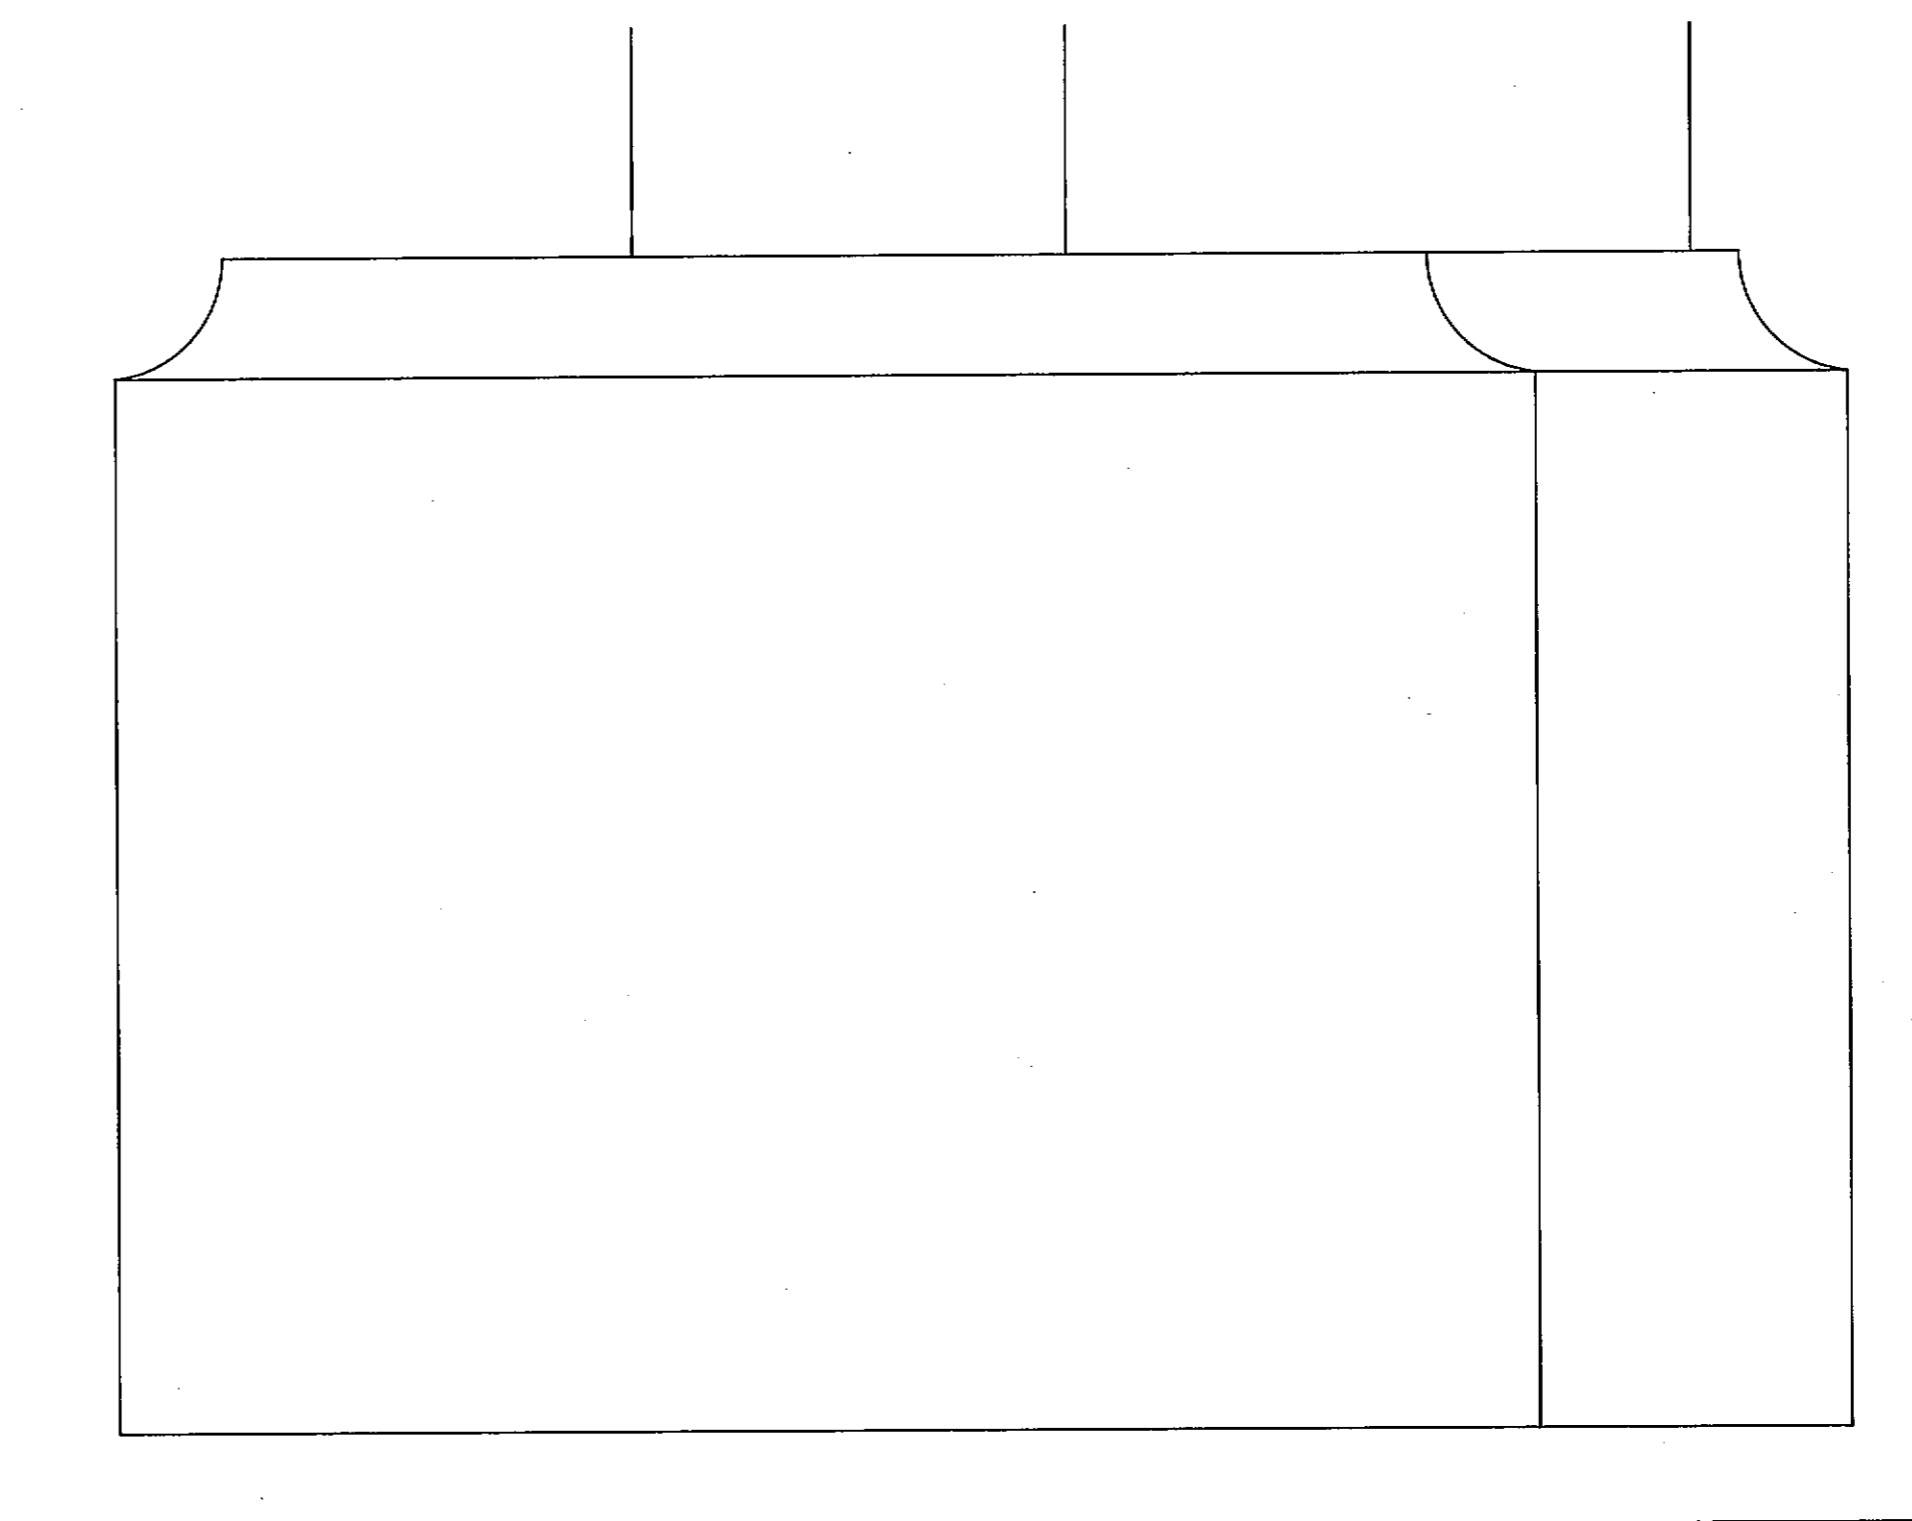


FSD - CASTER SUPPORT FRONT VIEW

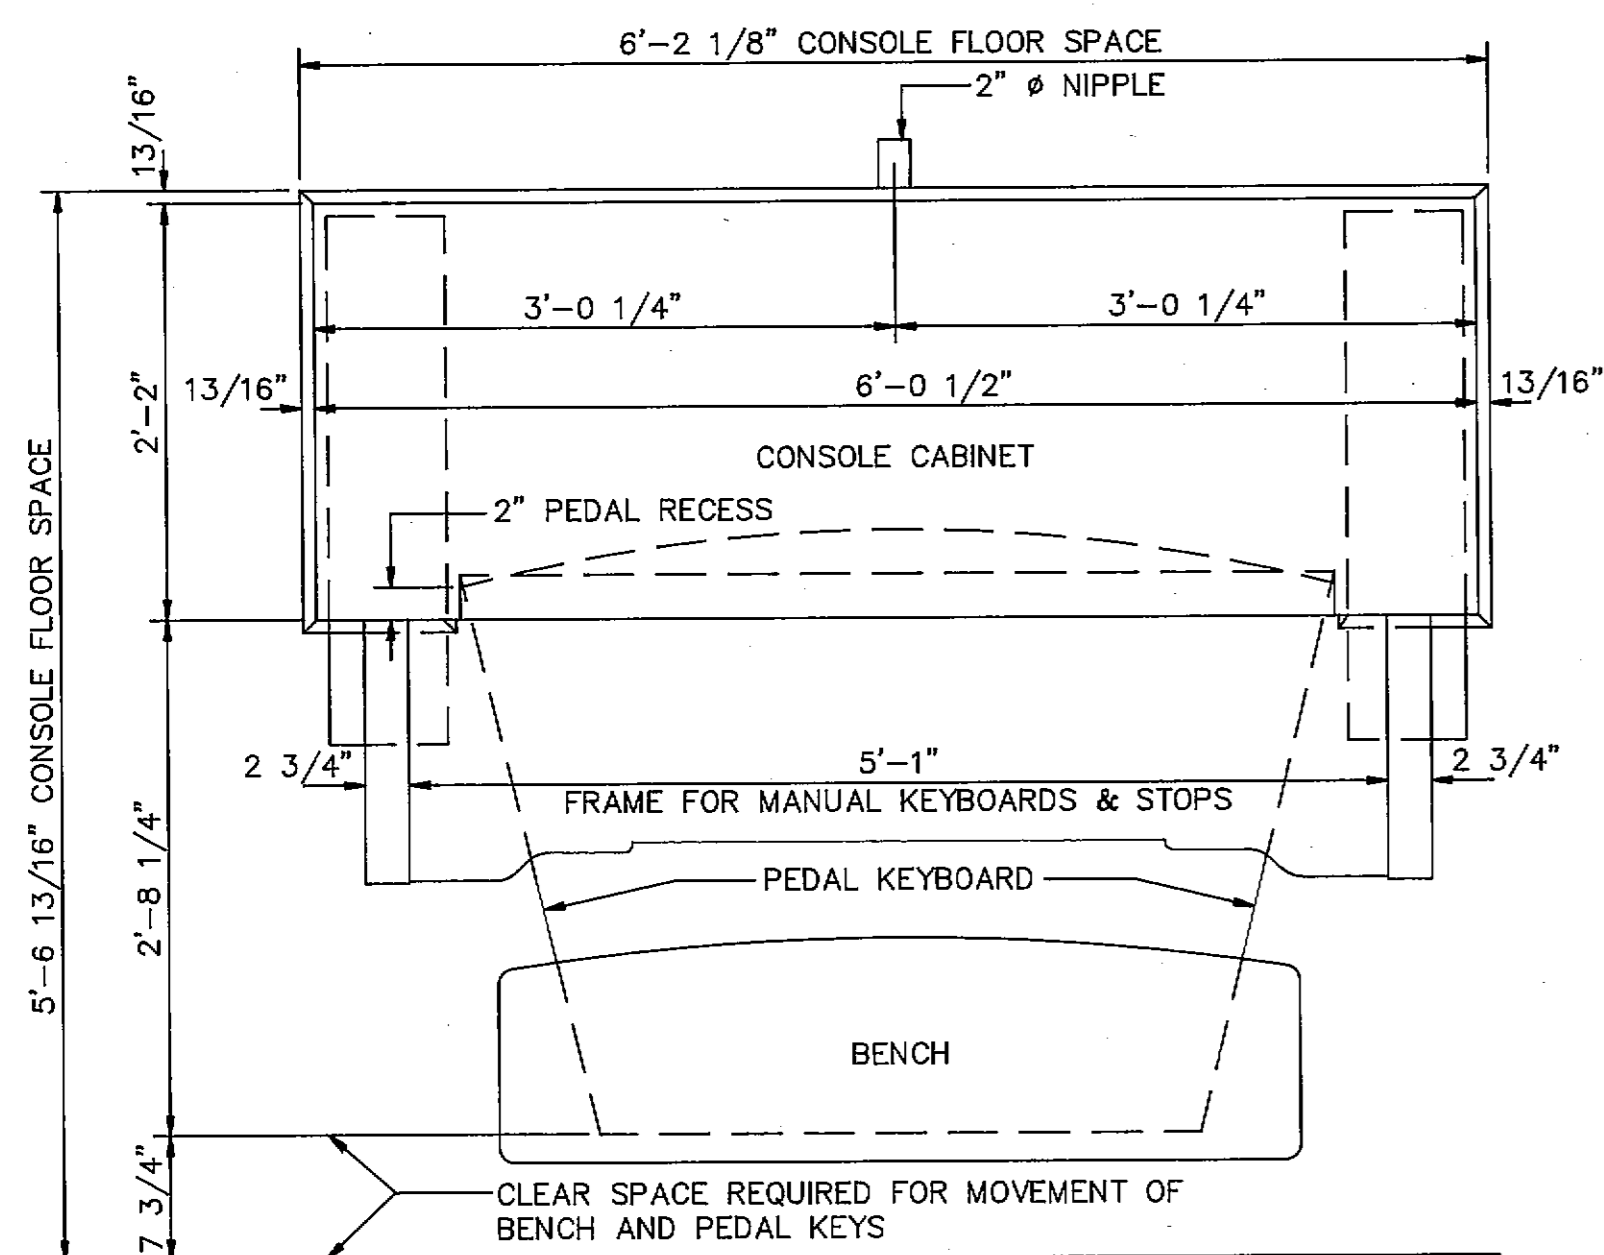

FLOOR PLAN

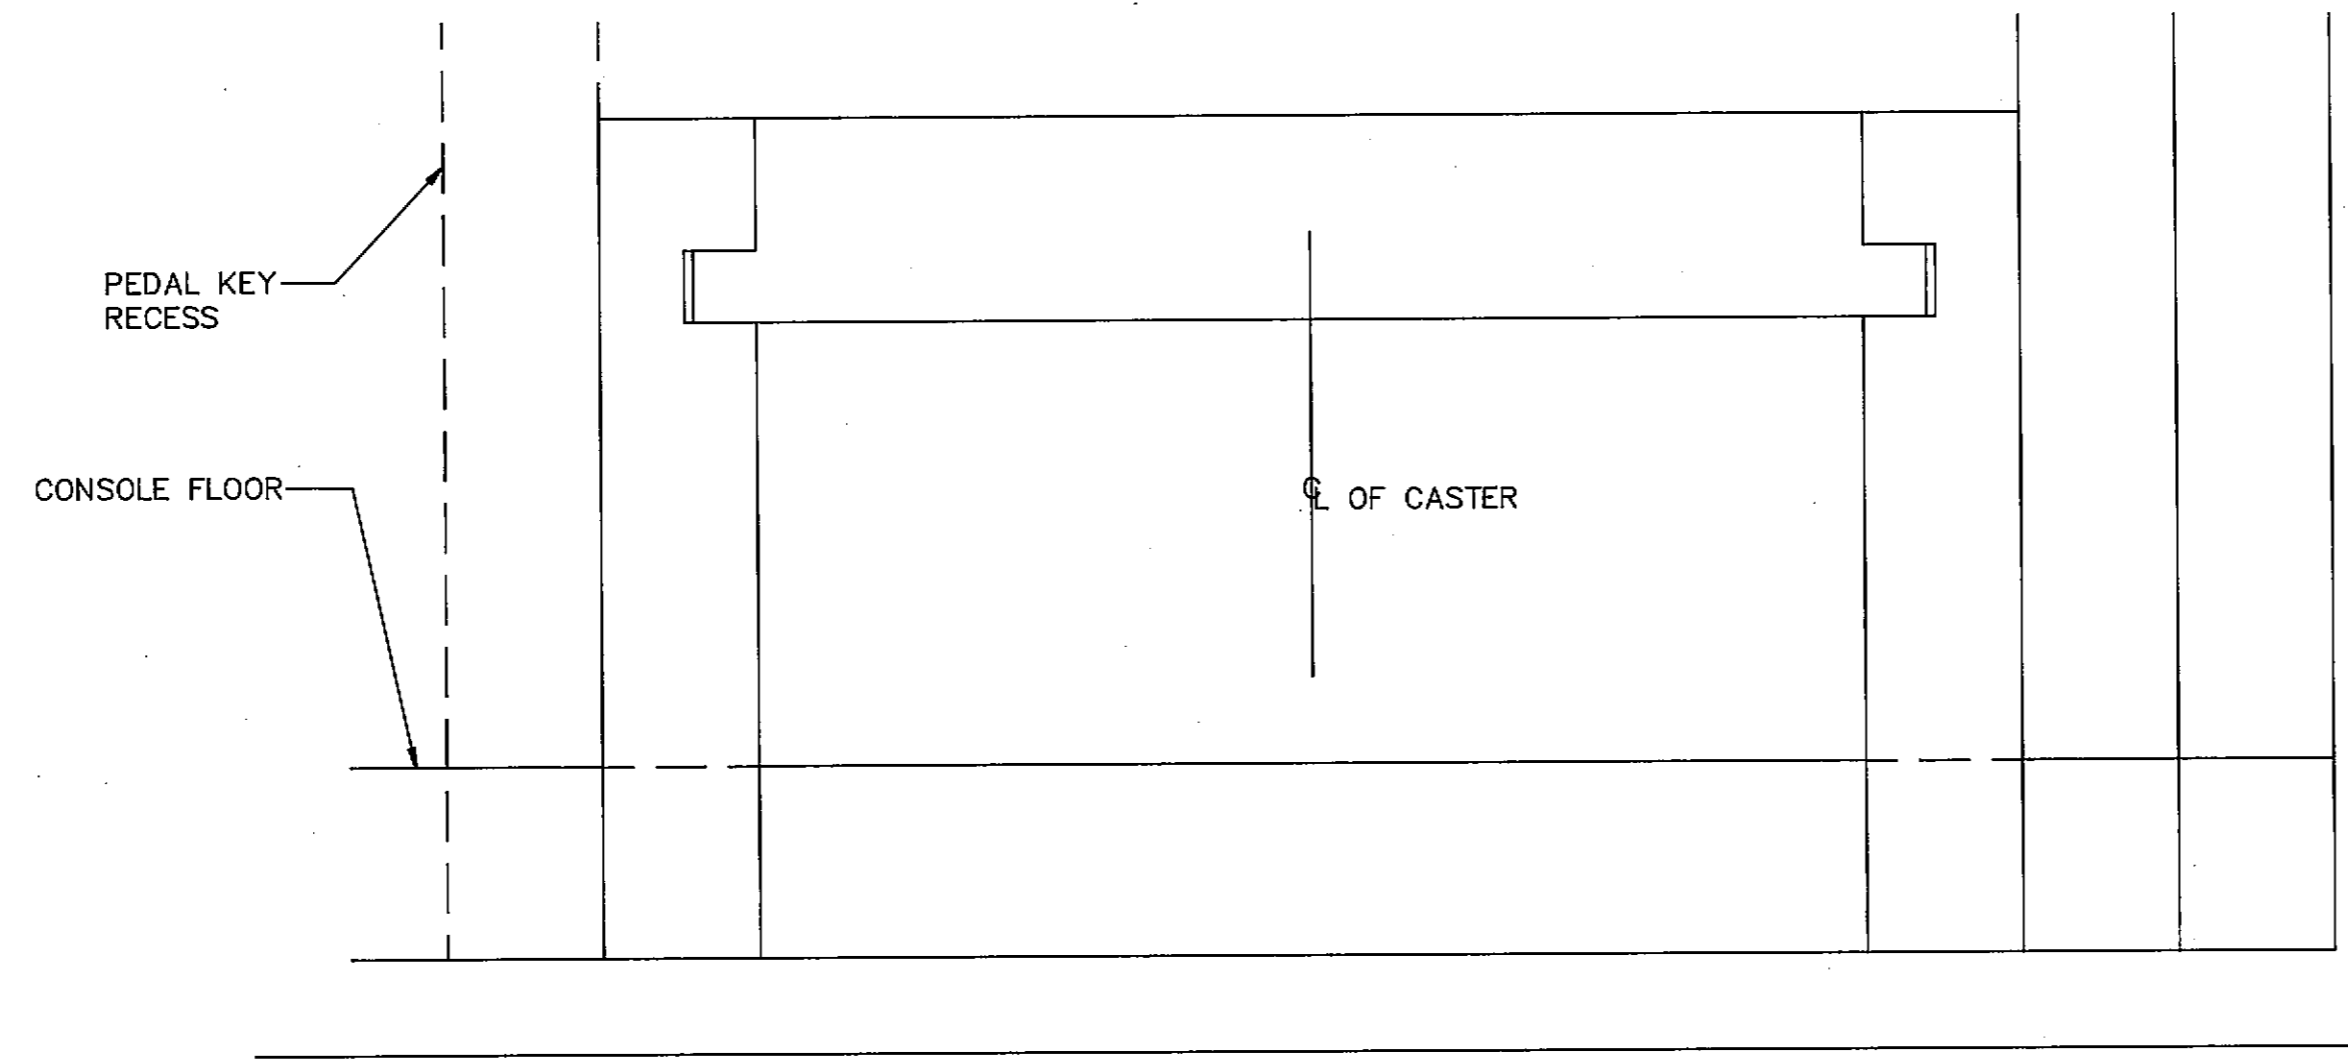

FSD - CASTER SUPPORT

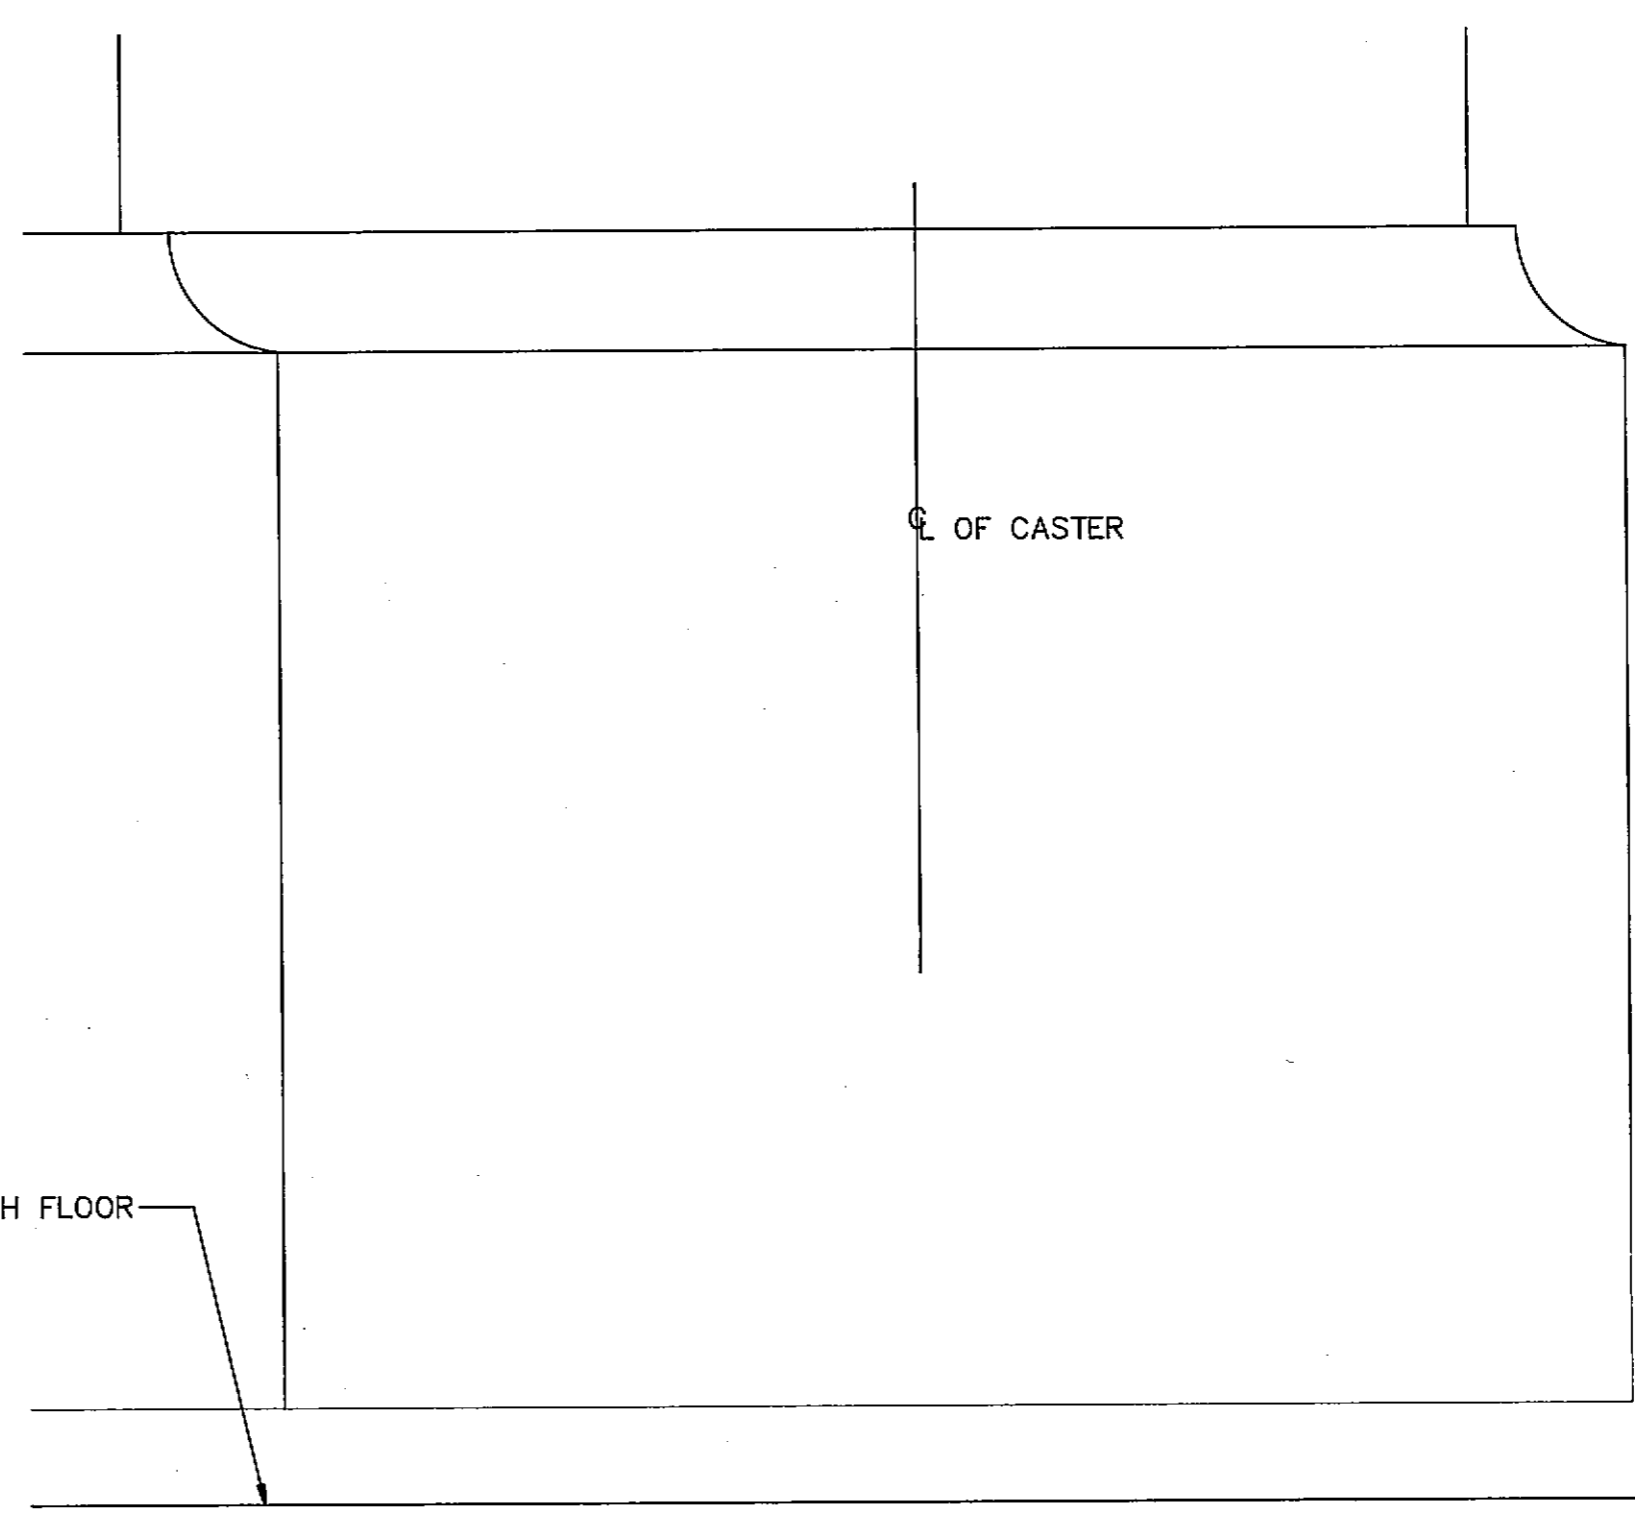

FSD - CASTER PROJECTION

- CONSOLE CABINET MOVABLE - NO ROLLTOP
- CABINET DESIGN B 3
- CABINET WOOD RIFT SAWN OAK
- CABINET FINISH TO CUSTOMER'S SAMPLE
- MANUALS THREE AND PEDAL - LEVEL - BONE & WALNUT MANUAL KEYS - MAPLE & WALNUT PEDAL KEYS - TRACKER TOUCH
- STOP CONTROLS WALNUT DRAW KNOBS & MAPLE TILTING TABLETS
- ACTION ALL ELECTRIC - SOLID STATE COUPLERS - SOLID STATE COMBINATION ACTION
- ACTION REQUIREMENTS 10-15 VOLTS DC


APPROXIMATE WEIGHT OF CONSOLE, PEDAL KEYS & BENCH IS 1250 POUNDS.

ONE PIECE \_\_\_\_\_ FEET OF 2" DIAMETER FLEXAUST HOSE FOR CABLES, DC WIRES MOTOR STARTER & CONSOLE LIGHTING WIRES.


DIMENSIONS OK H. A. HARVEY DATE 4-10-90  
 DESIGN APPROVAL H. A. HARVEY DATE 4-10-90

FIRST UNITED METHODIST CHURCH,  
 BATTLE CREEK, MICHIGAN

SCALE - 1" = 1'-0"				<i>M. P. Miller</i> INCORPORATED HAGERSTOWN, MD.	11801
REV.	CK'D	DRAWN	DATE		
4-28-90	DMM	JM	4-2-90		DRAWING NO. 103

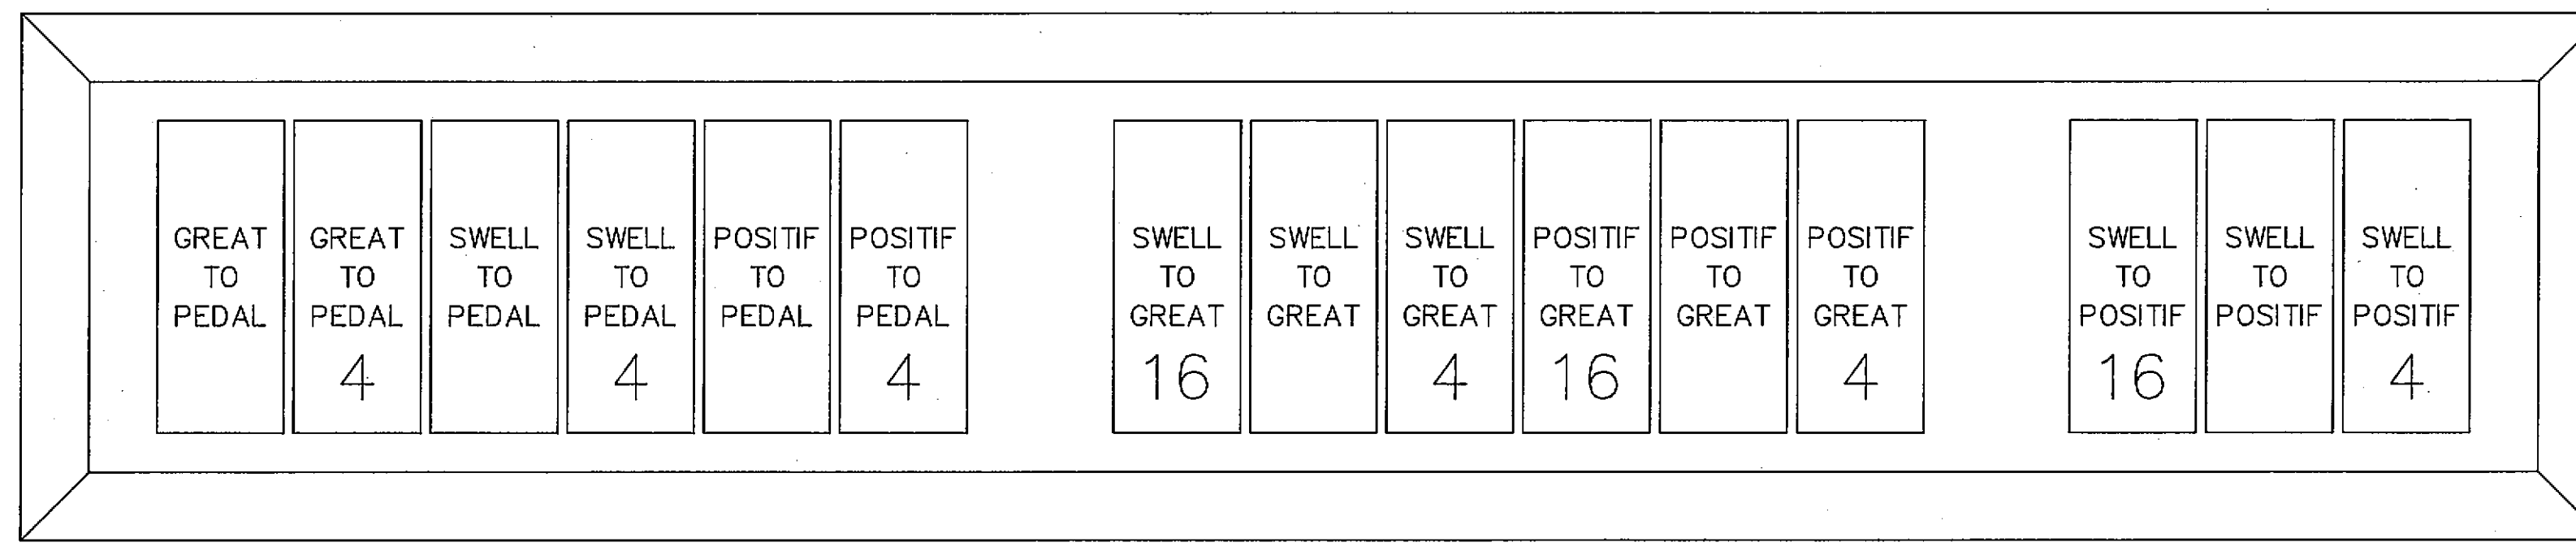


AMBER LEVEL GREEN LEVEL RED LEVEL  
 DC CURRENT CRESCENDO TUTTI

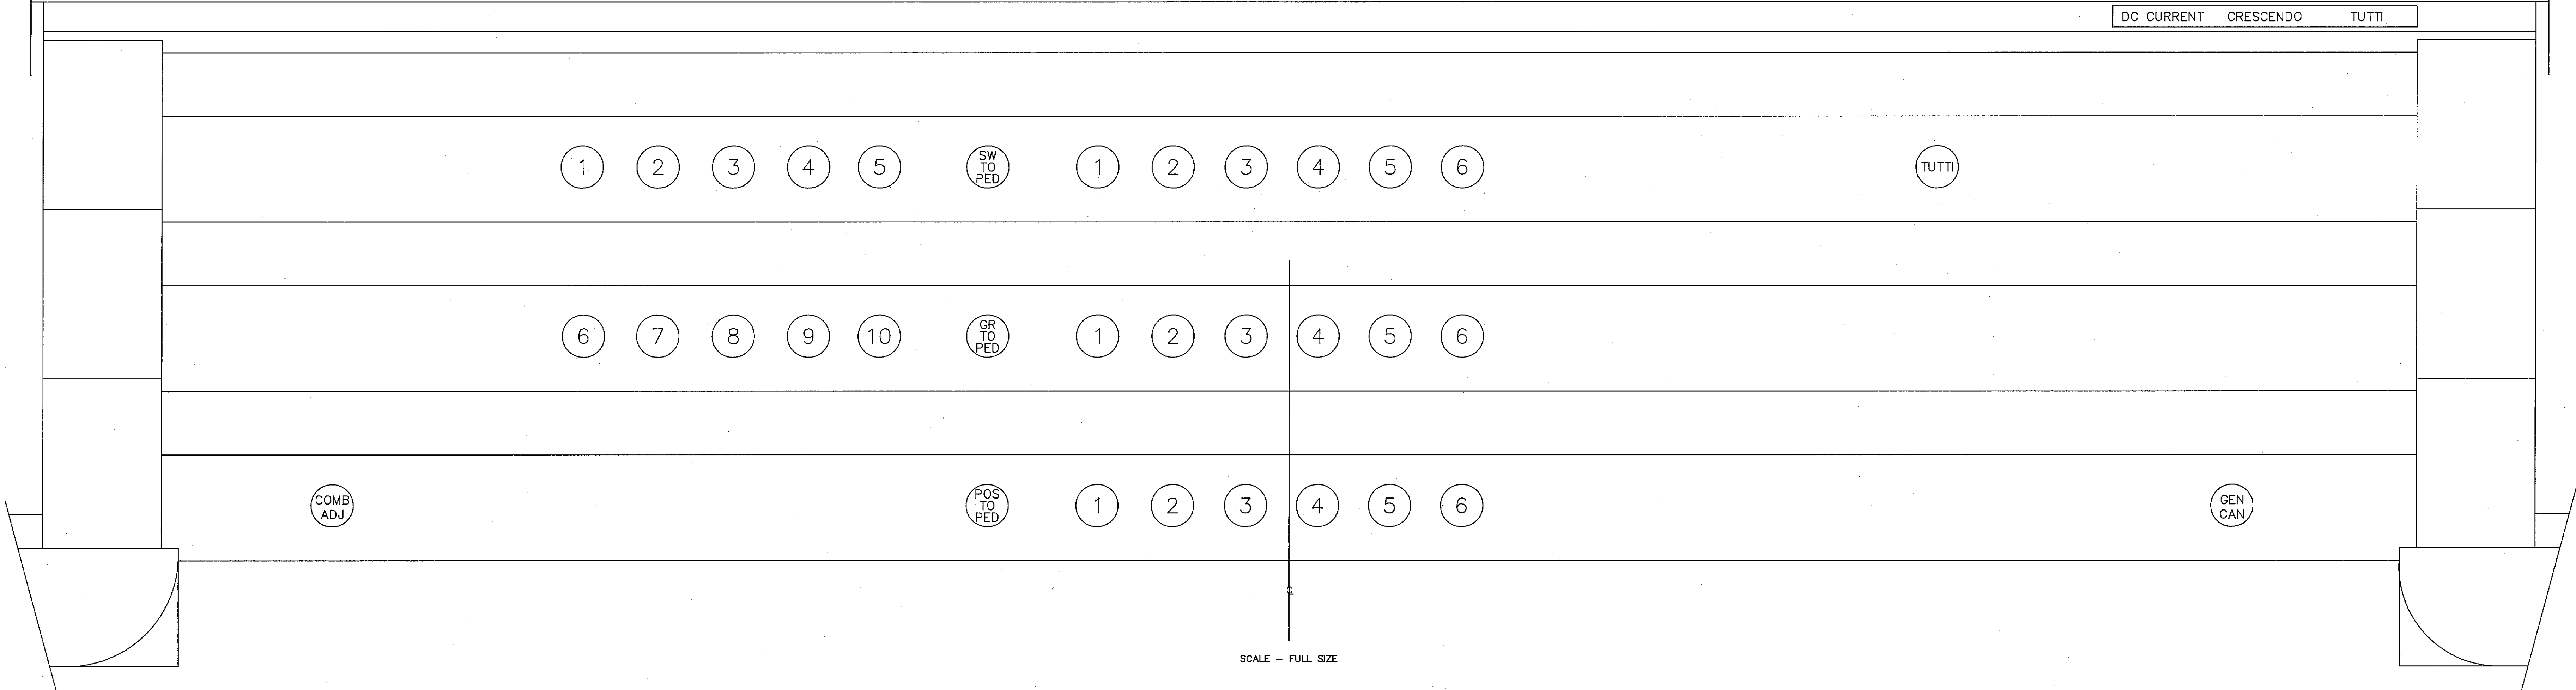

SCALE - FULL SIZE

PEDAL & STUD ARRANGEMENT  
 SCALE - 6" = 1'-0"

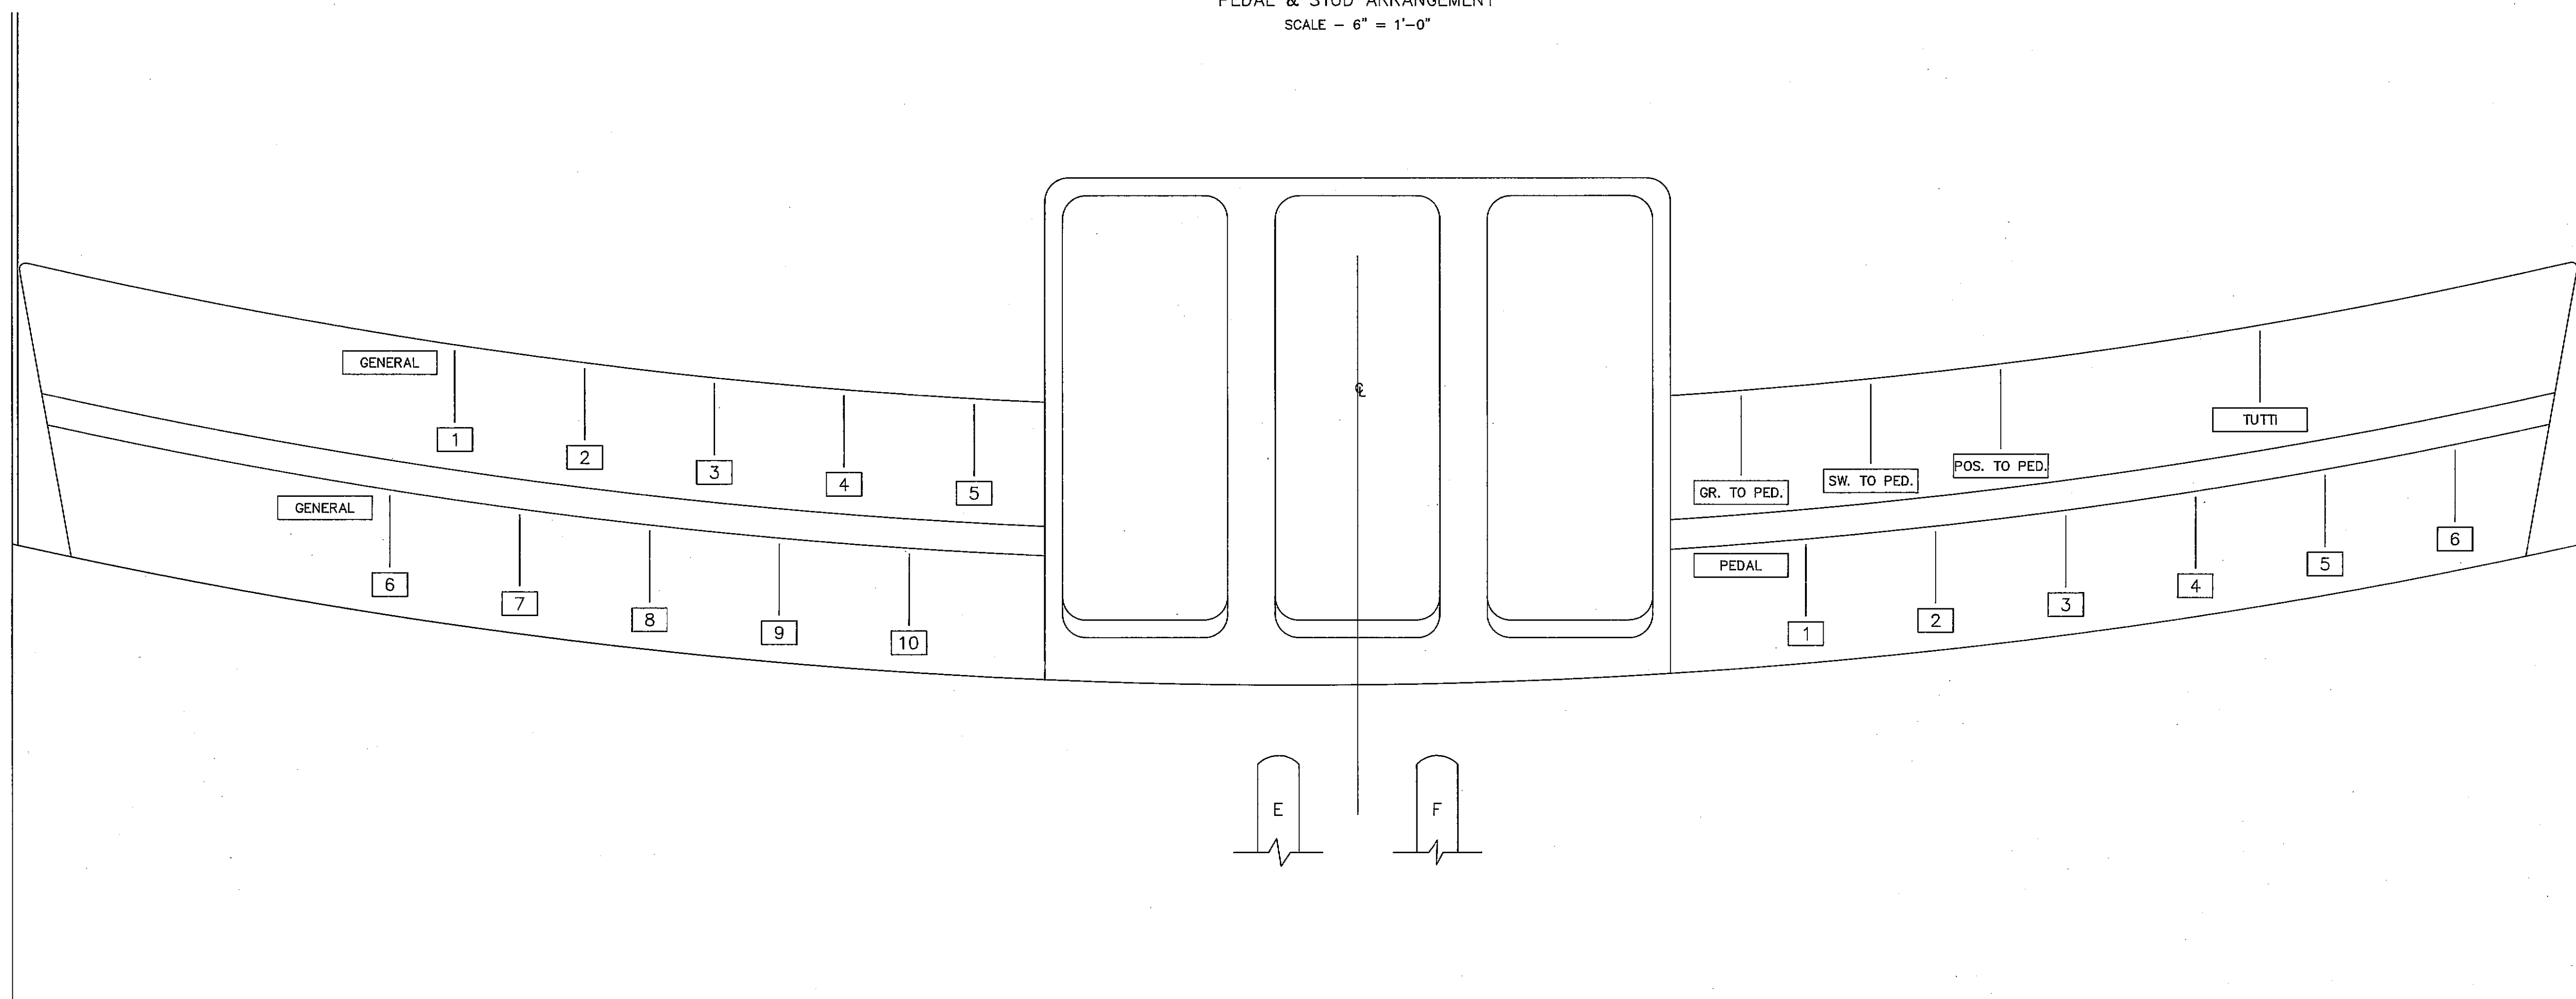


CUSTOMER'S APPROVAL \_\_\_\_\_ DATE \_\_\_\_\_

FIRST UNITED METHODIST CHURCH,  
 BATTLE CREEK, MICHIGAN



SCALE - SEE NOTES		<i>M.P. Miller</i> INCORPORATED	11801
REV.	CK'D		
DMM	JM	5-30-90	HAGERSTOWN, MD.

DRAWING NO. 102-A

1 file - and 1 copy

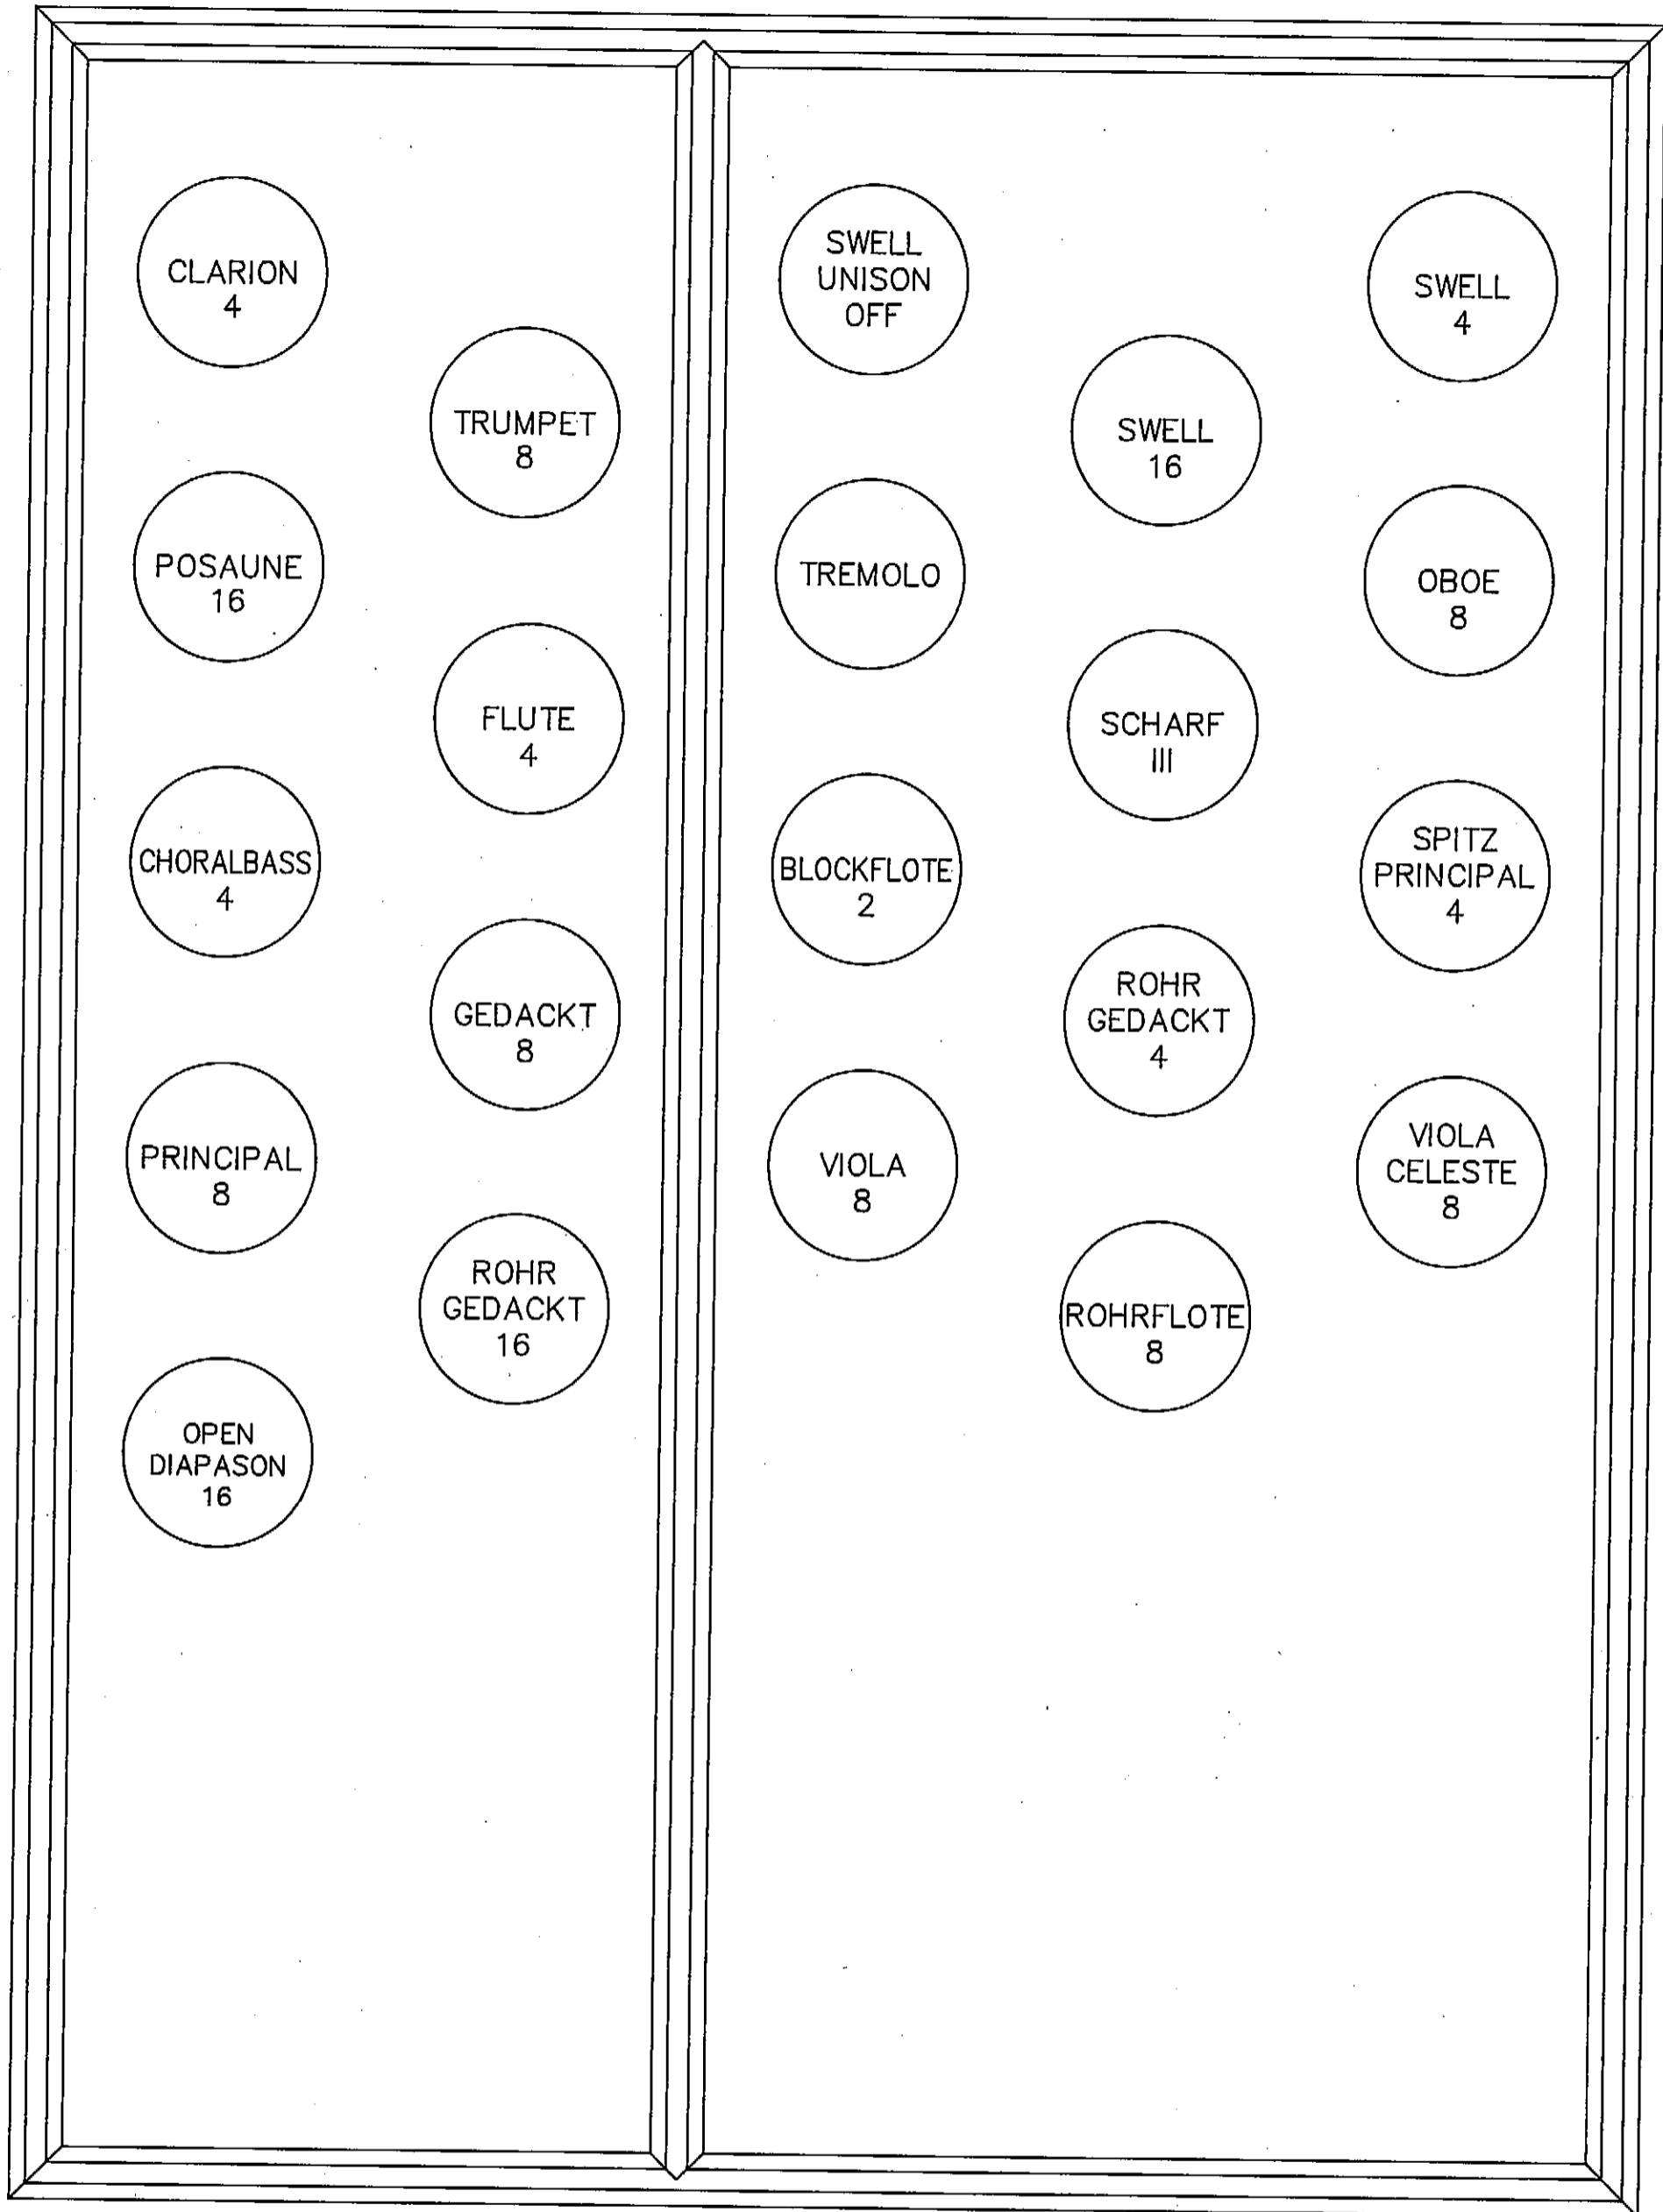

TOP OF SWELL KEY JAMB

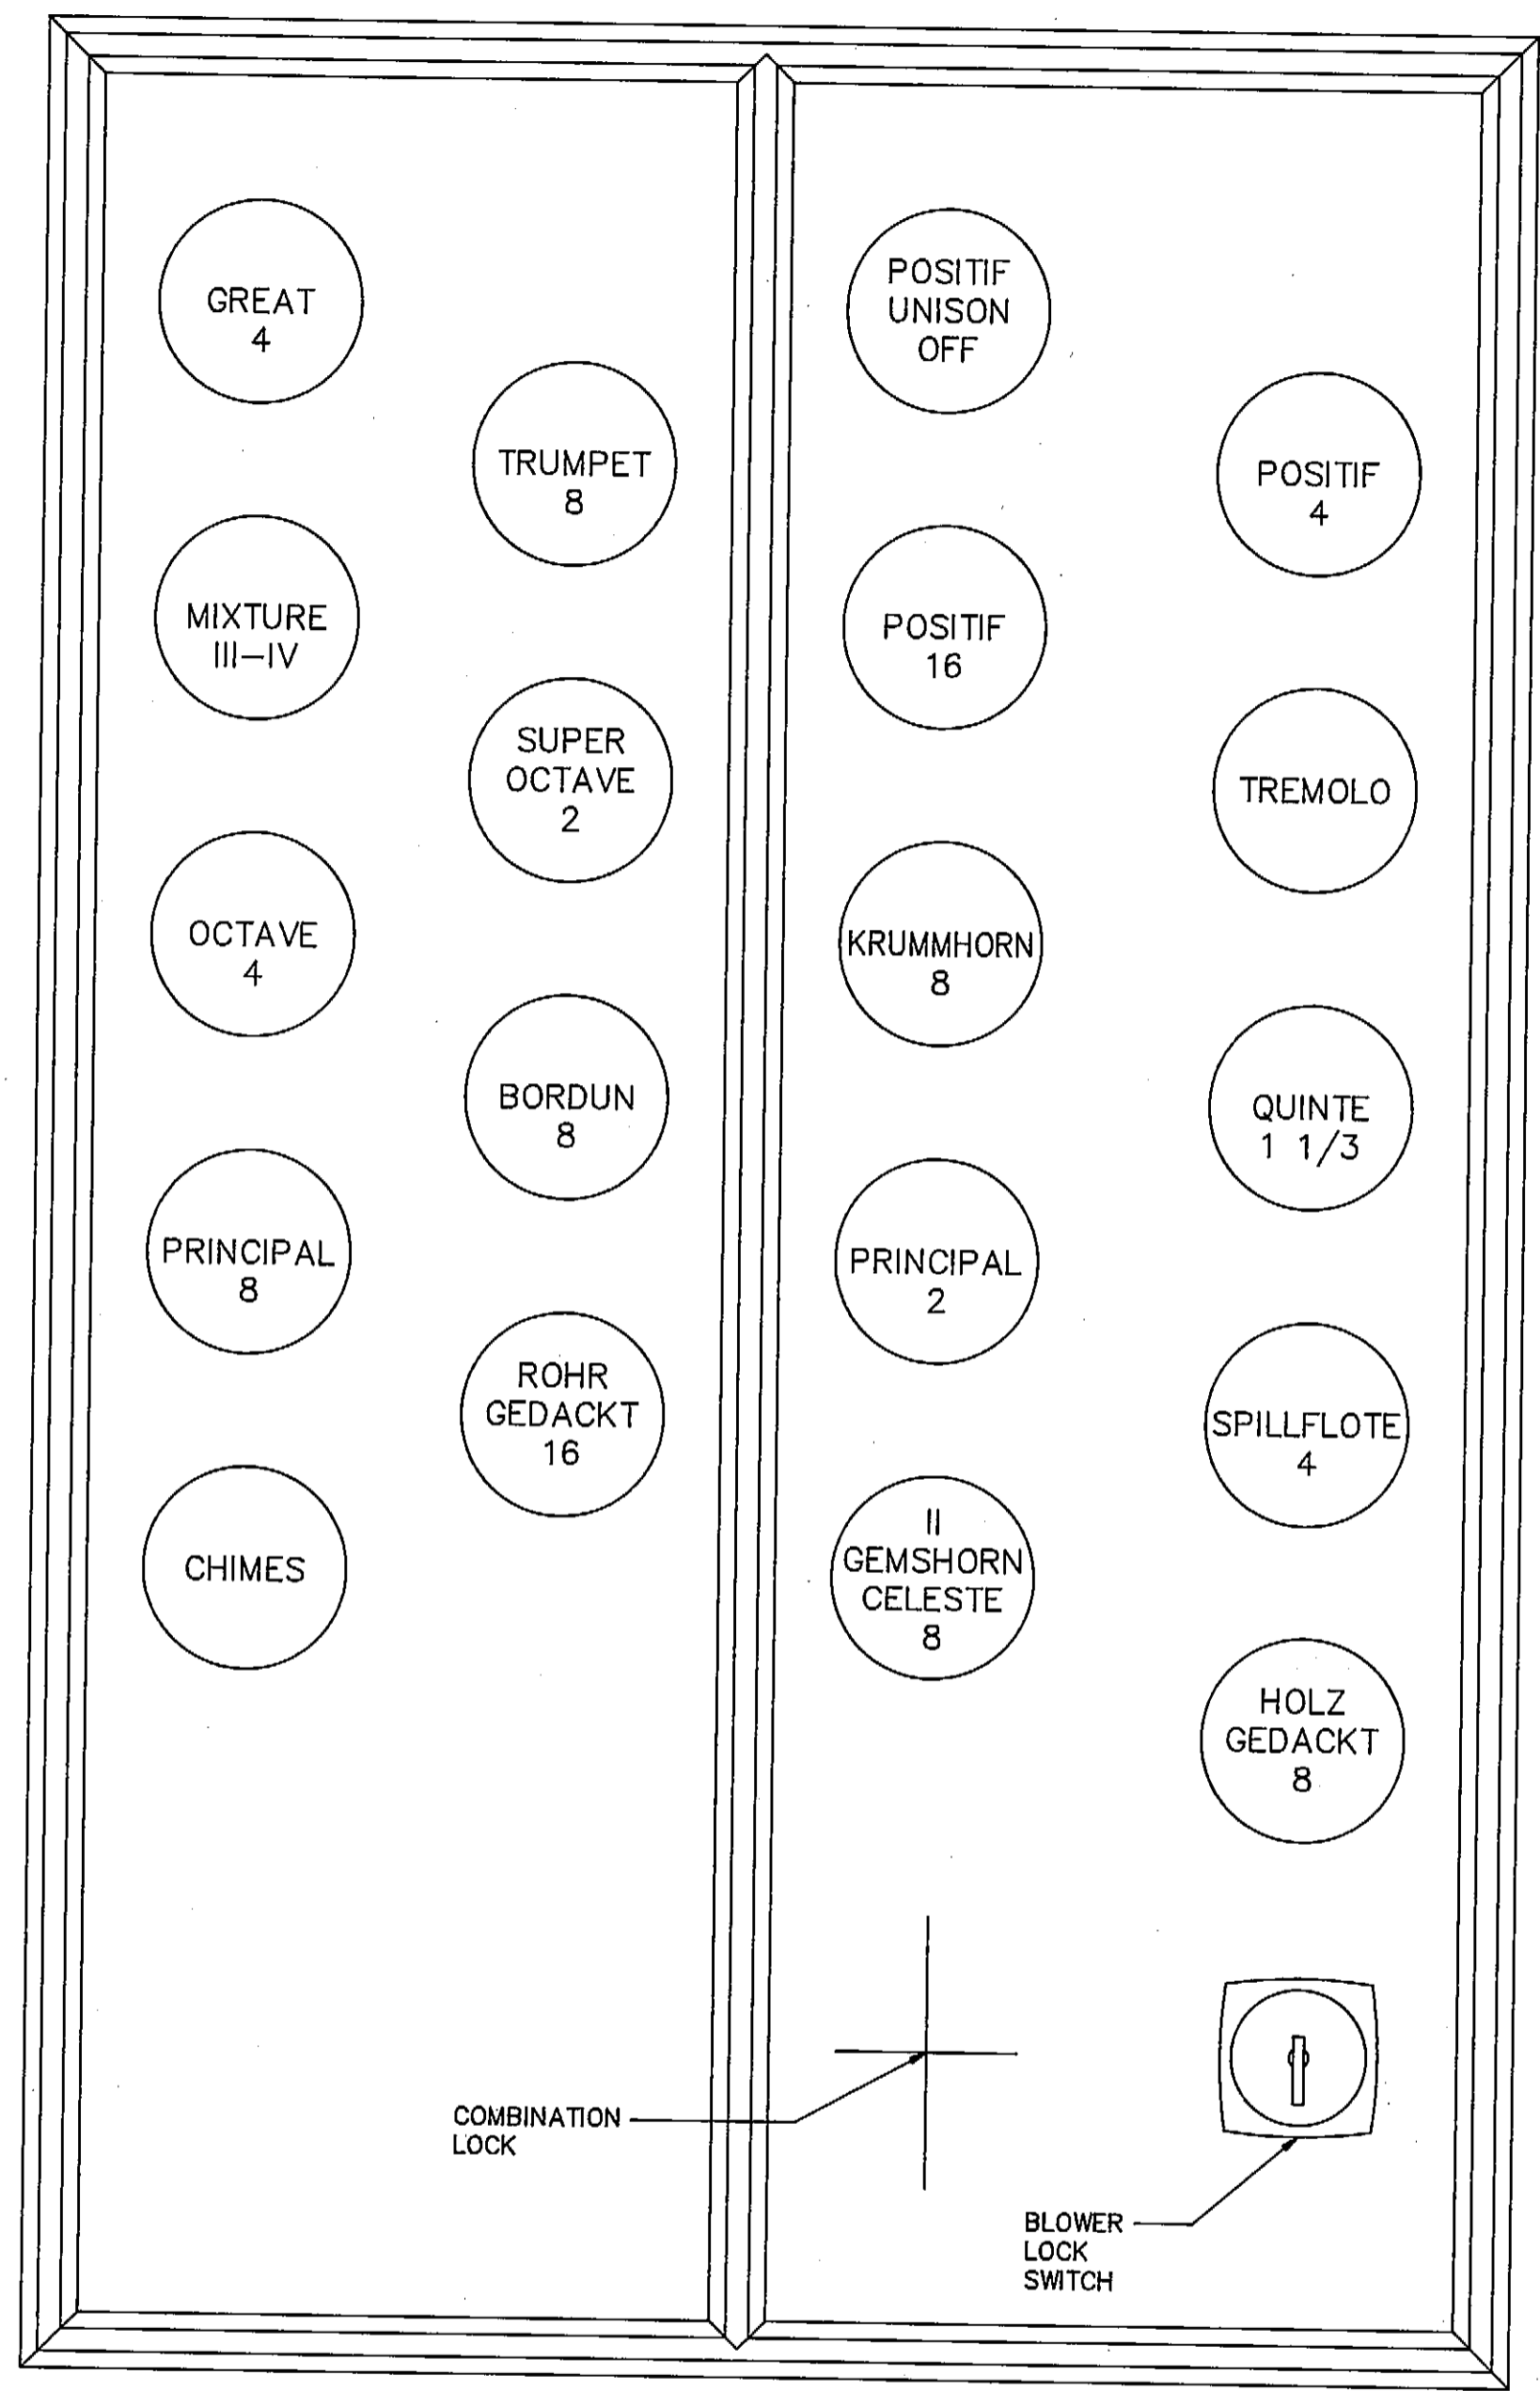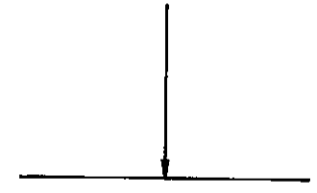

PURCHASER'S APPROVAL \_\_\_\_\_ DATE \_\_\_\_\_

FIRST UNITED METHODIST CHURCH,  
BATTLE CREEK, MICHIGAN

SCALE - FULL SIZE				<i>M. P. Moller</i> INCORPORATED HAGERSTOWN, MD.	11801
REV.	CK'D	DRAWN	DATE		
	DMM	JM	4-2-90		DRAWING NO. 102-B

*1 fold - cut & use*