




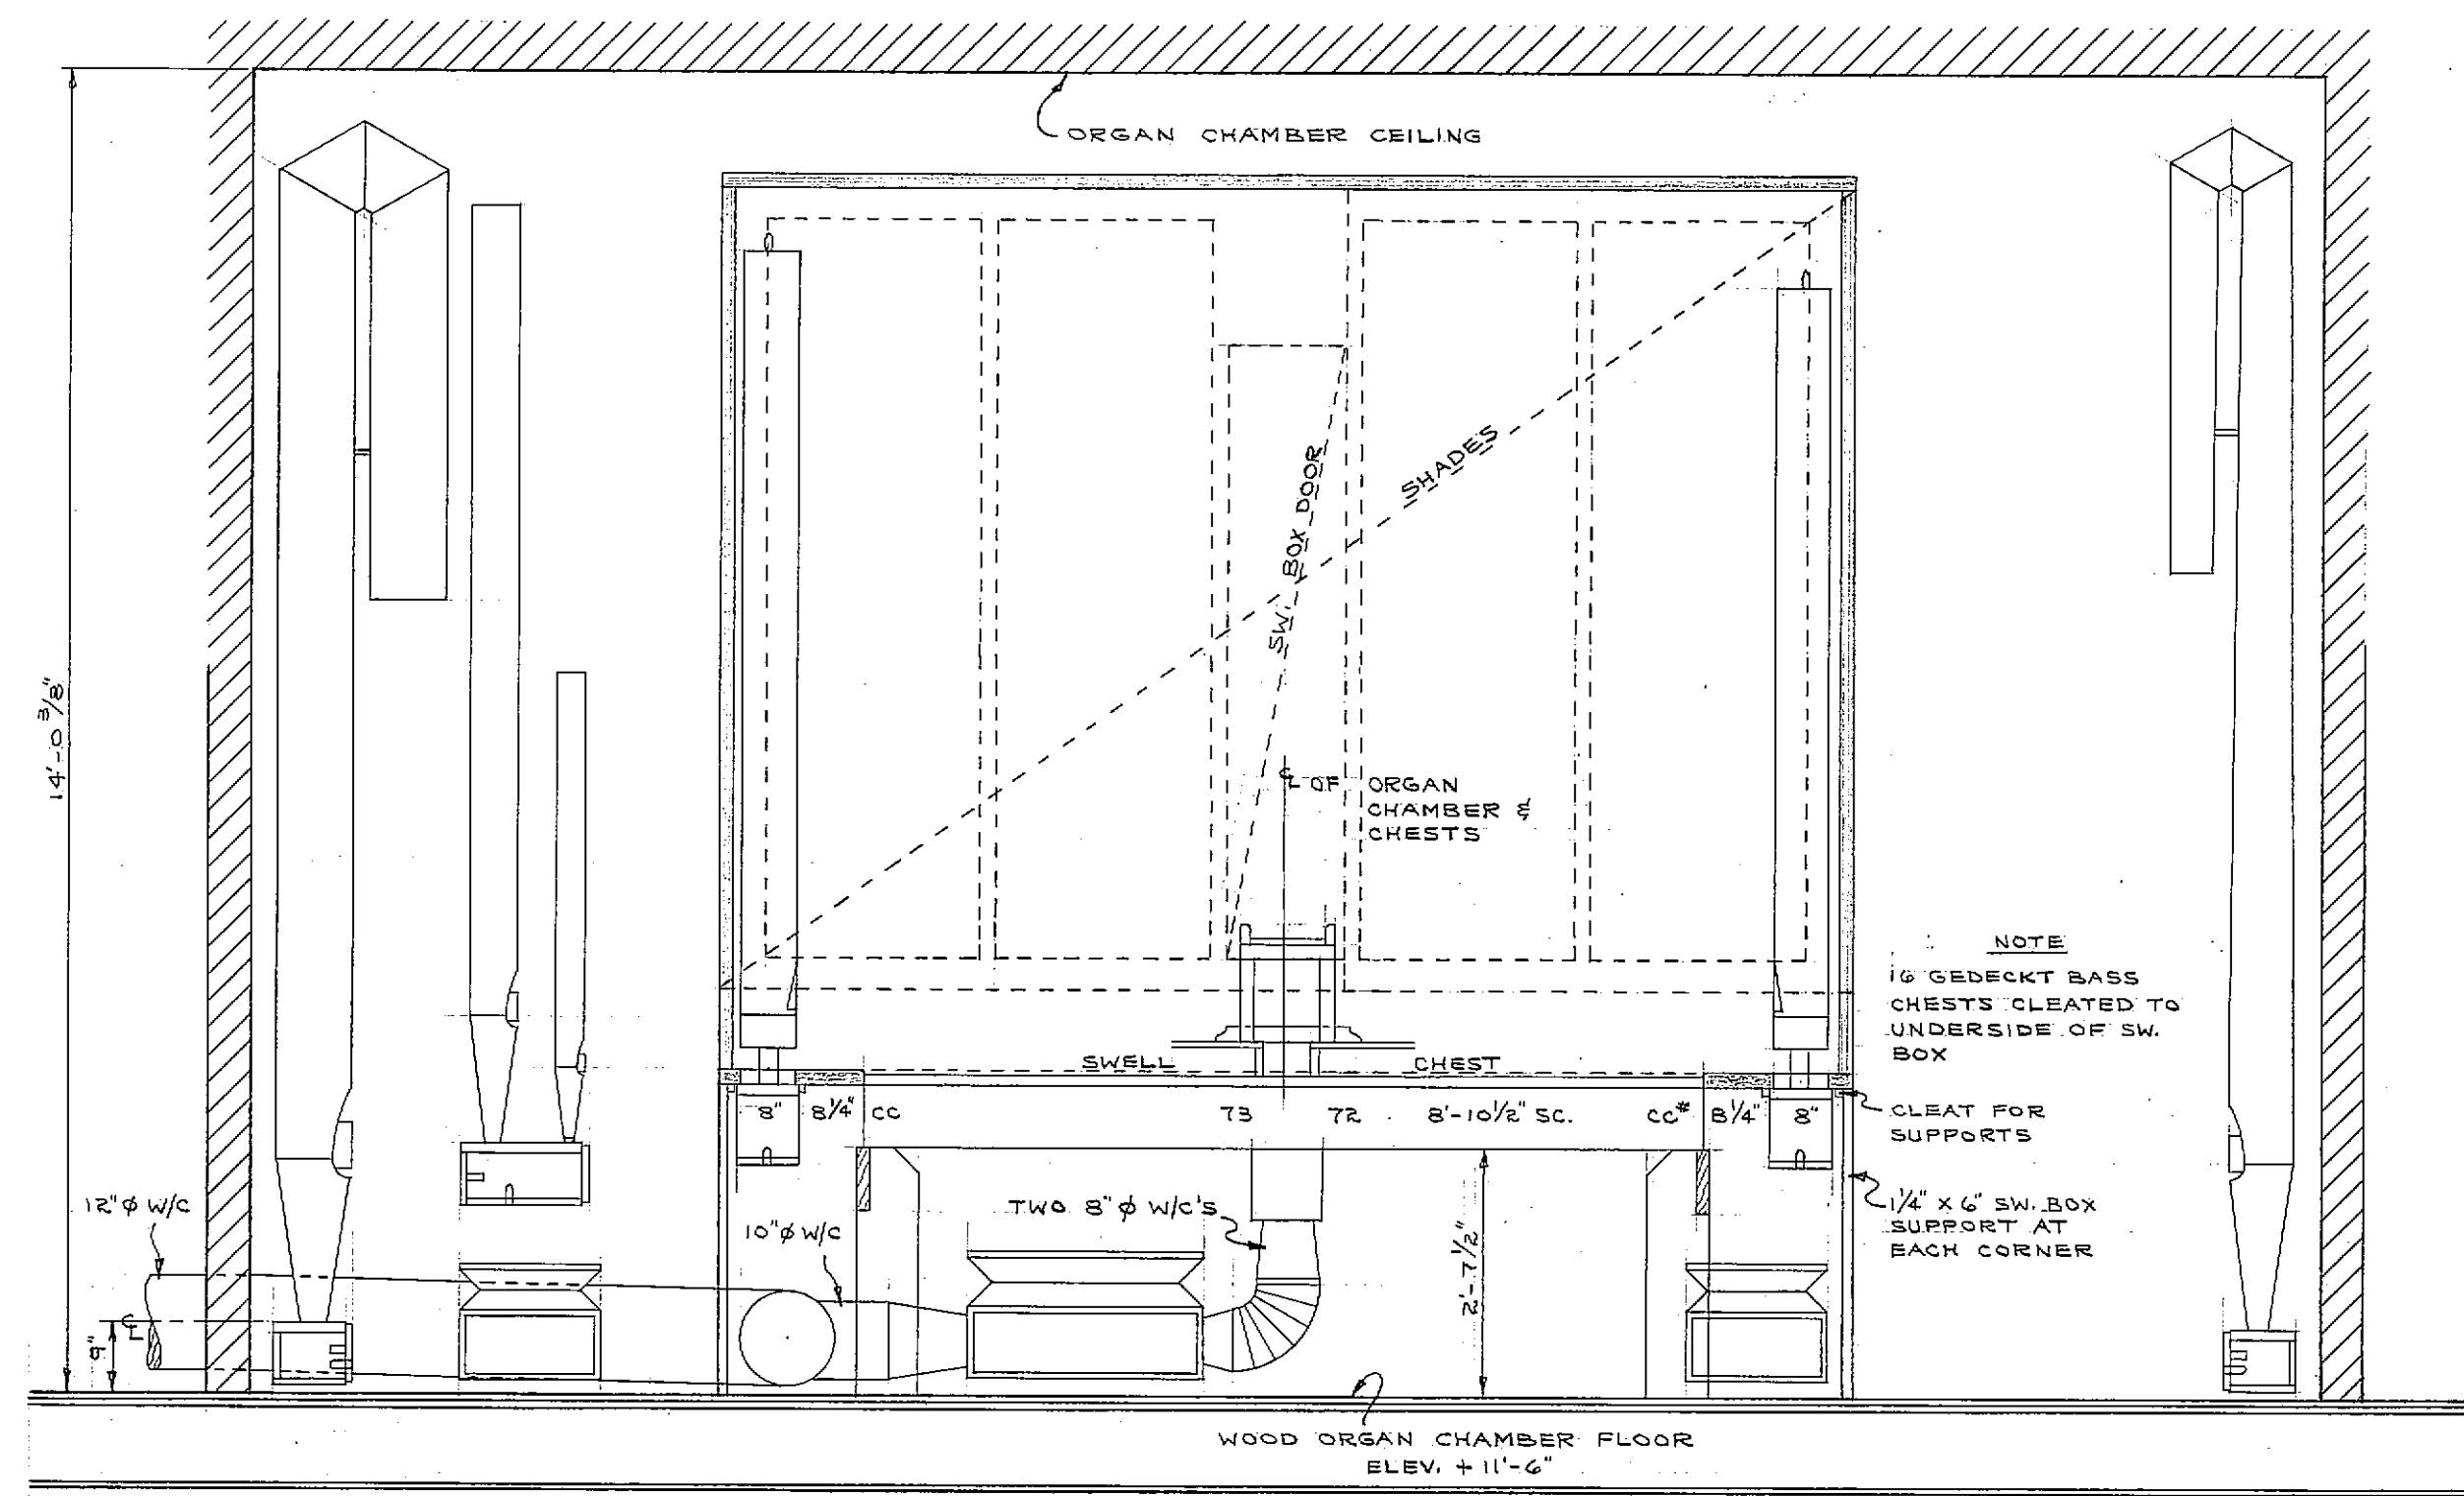


SECTION AA

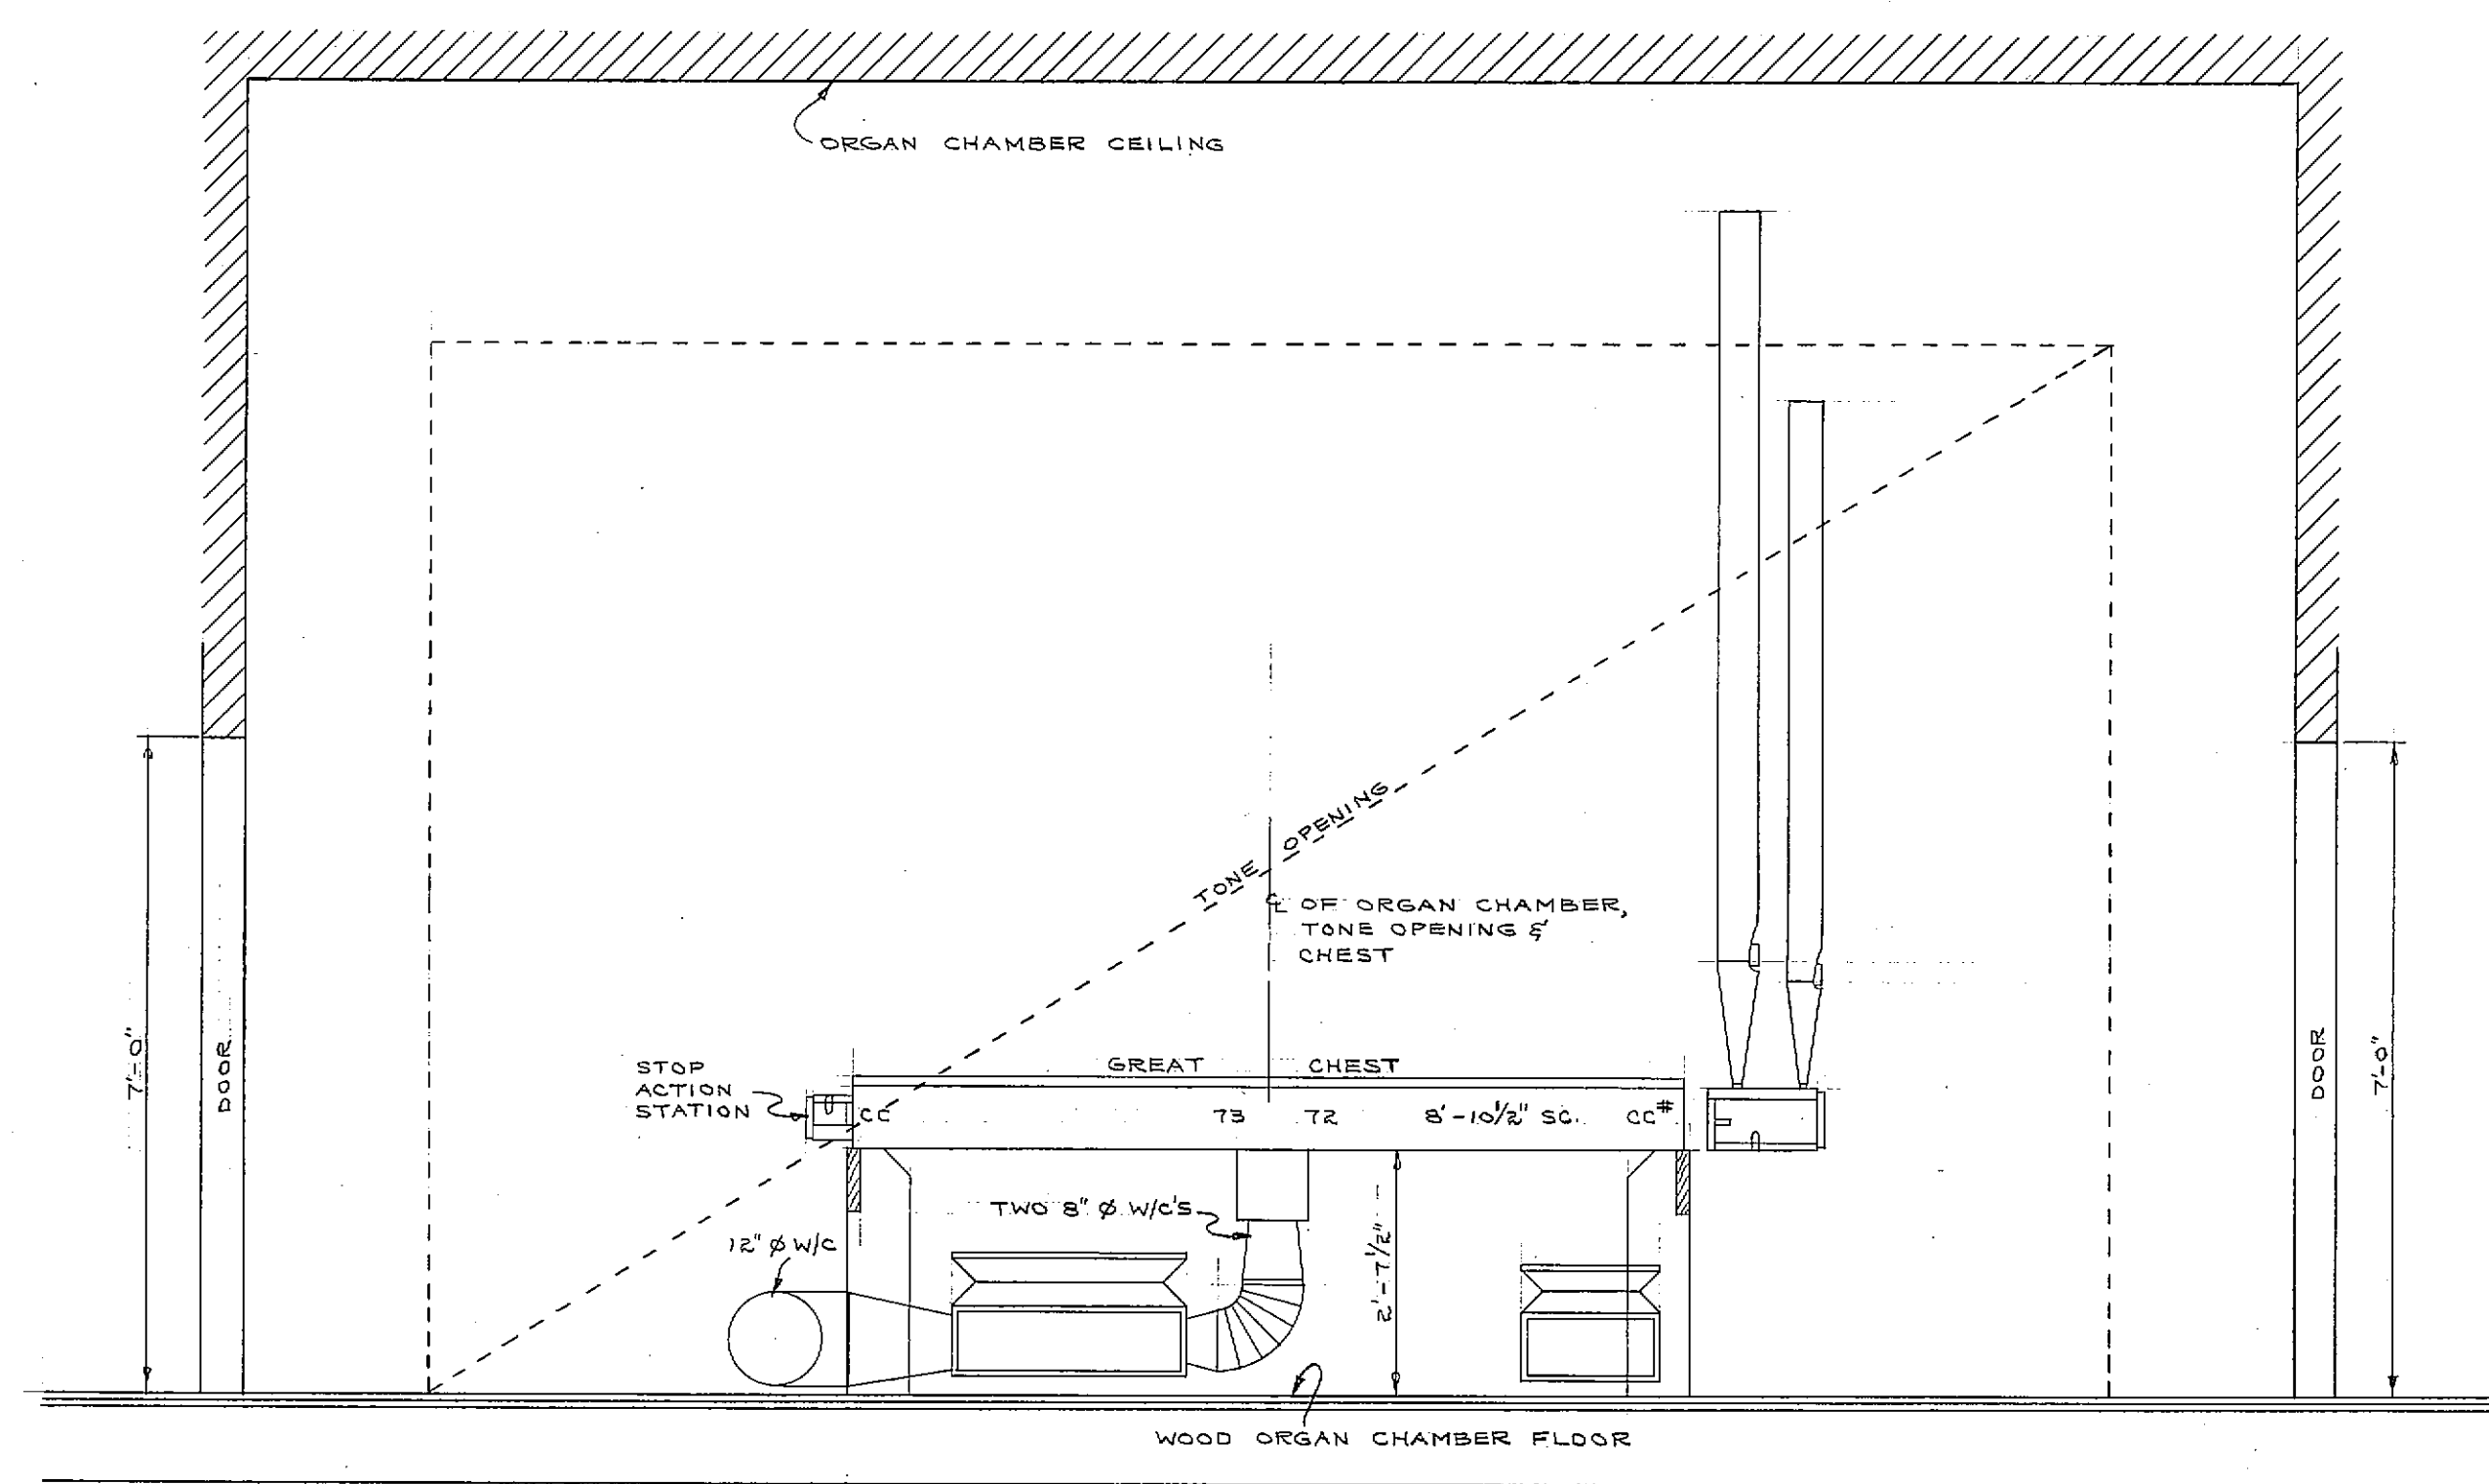


SECTION BB

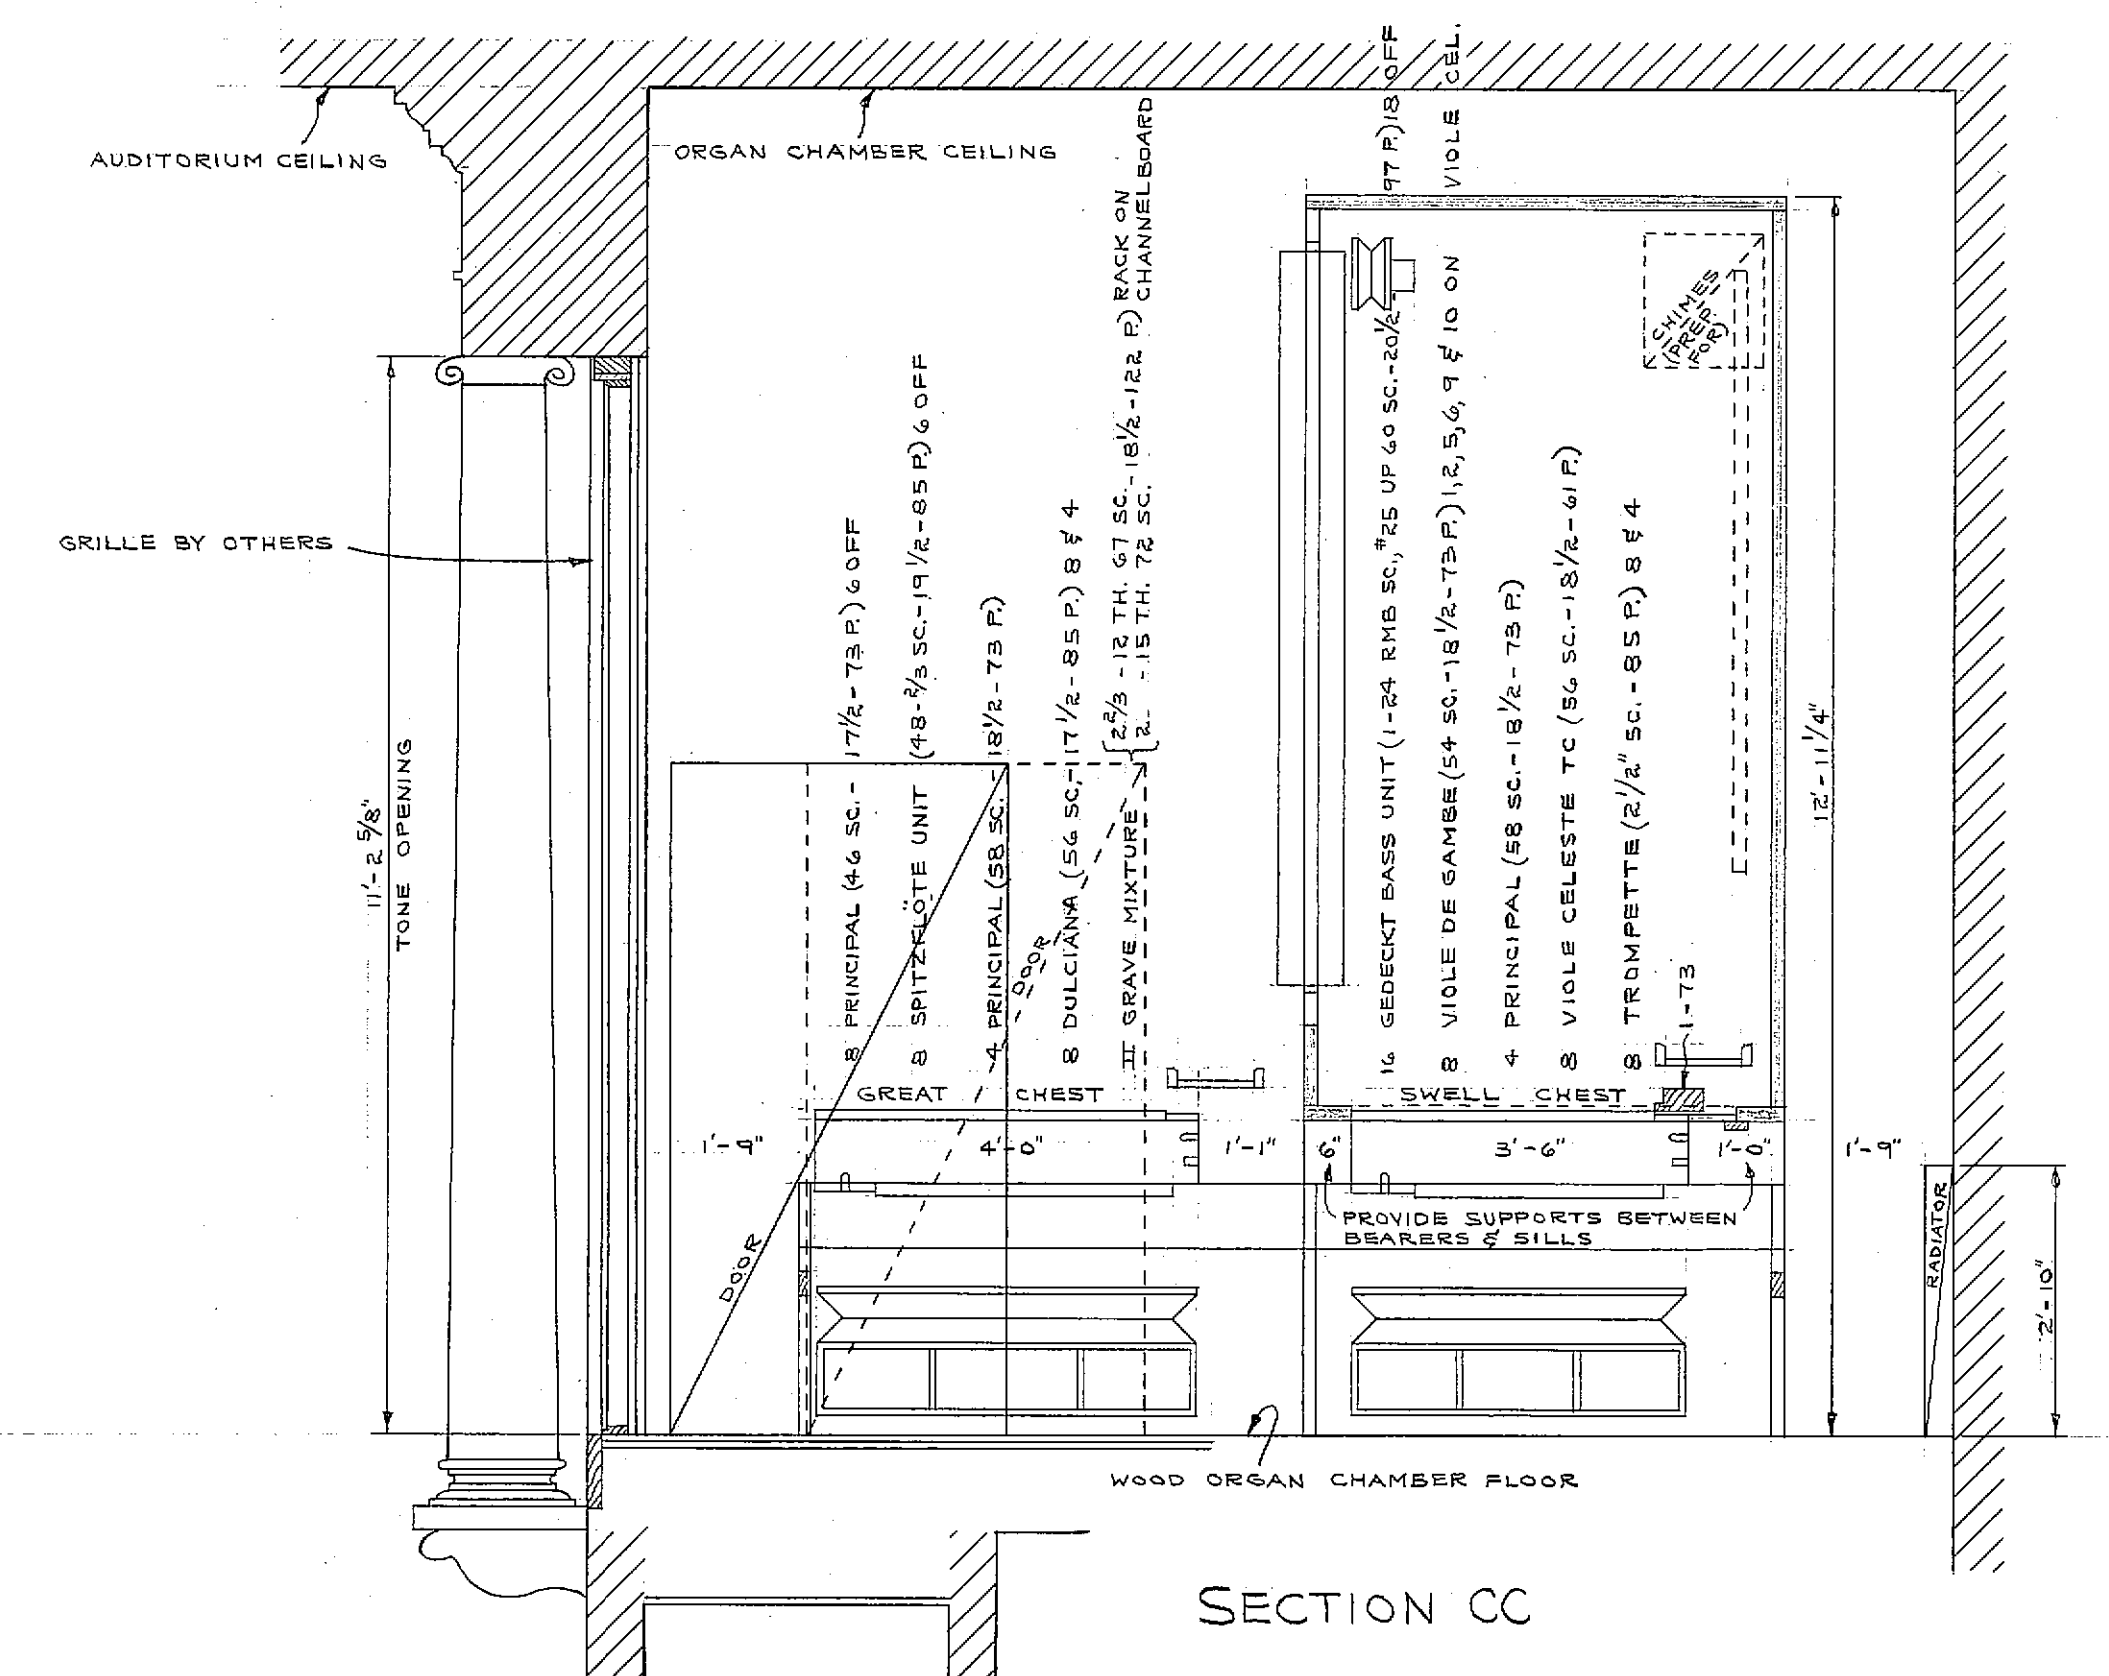

SECTION CC

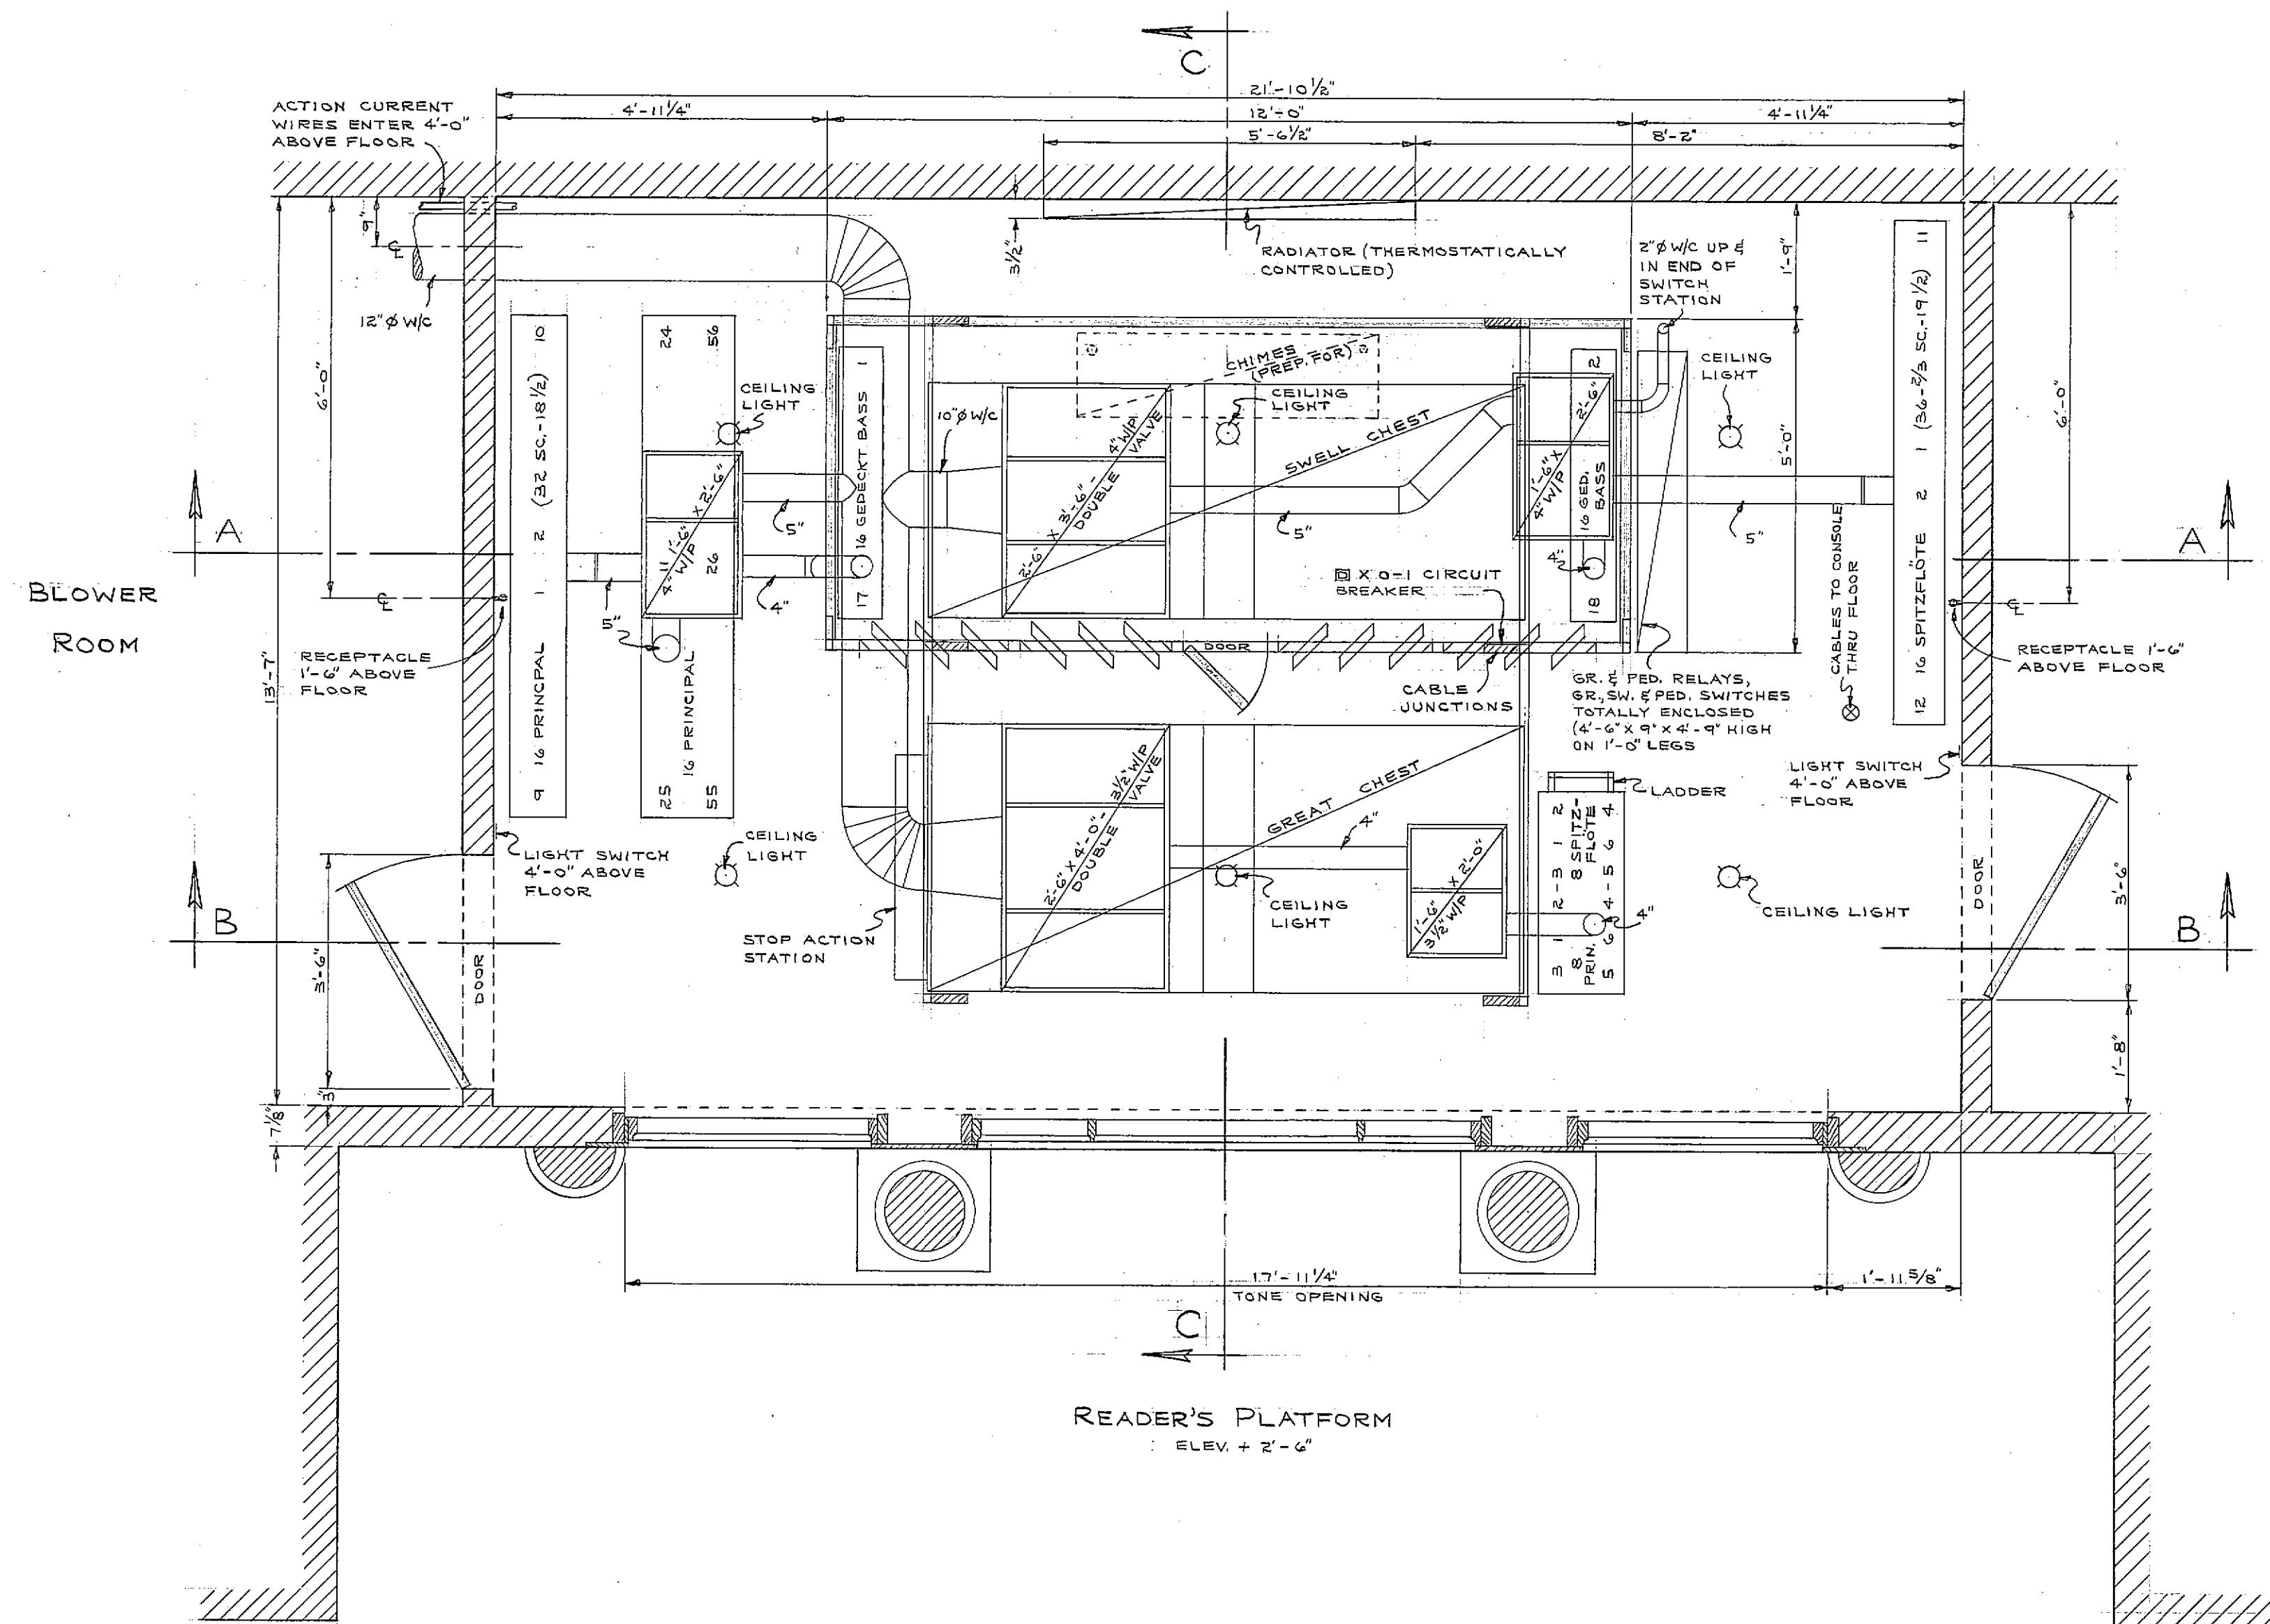


FLOOR PLAN

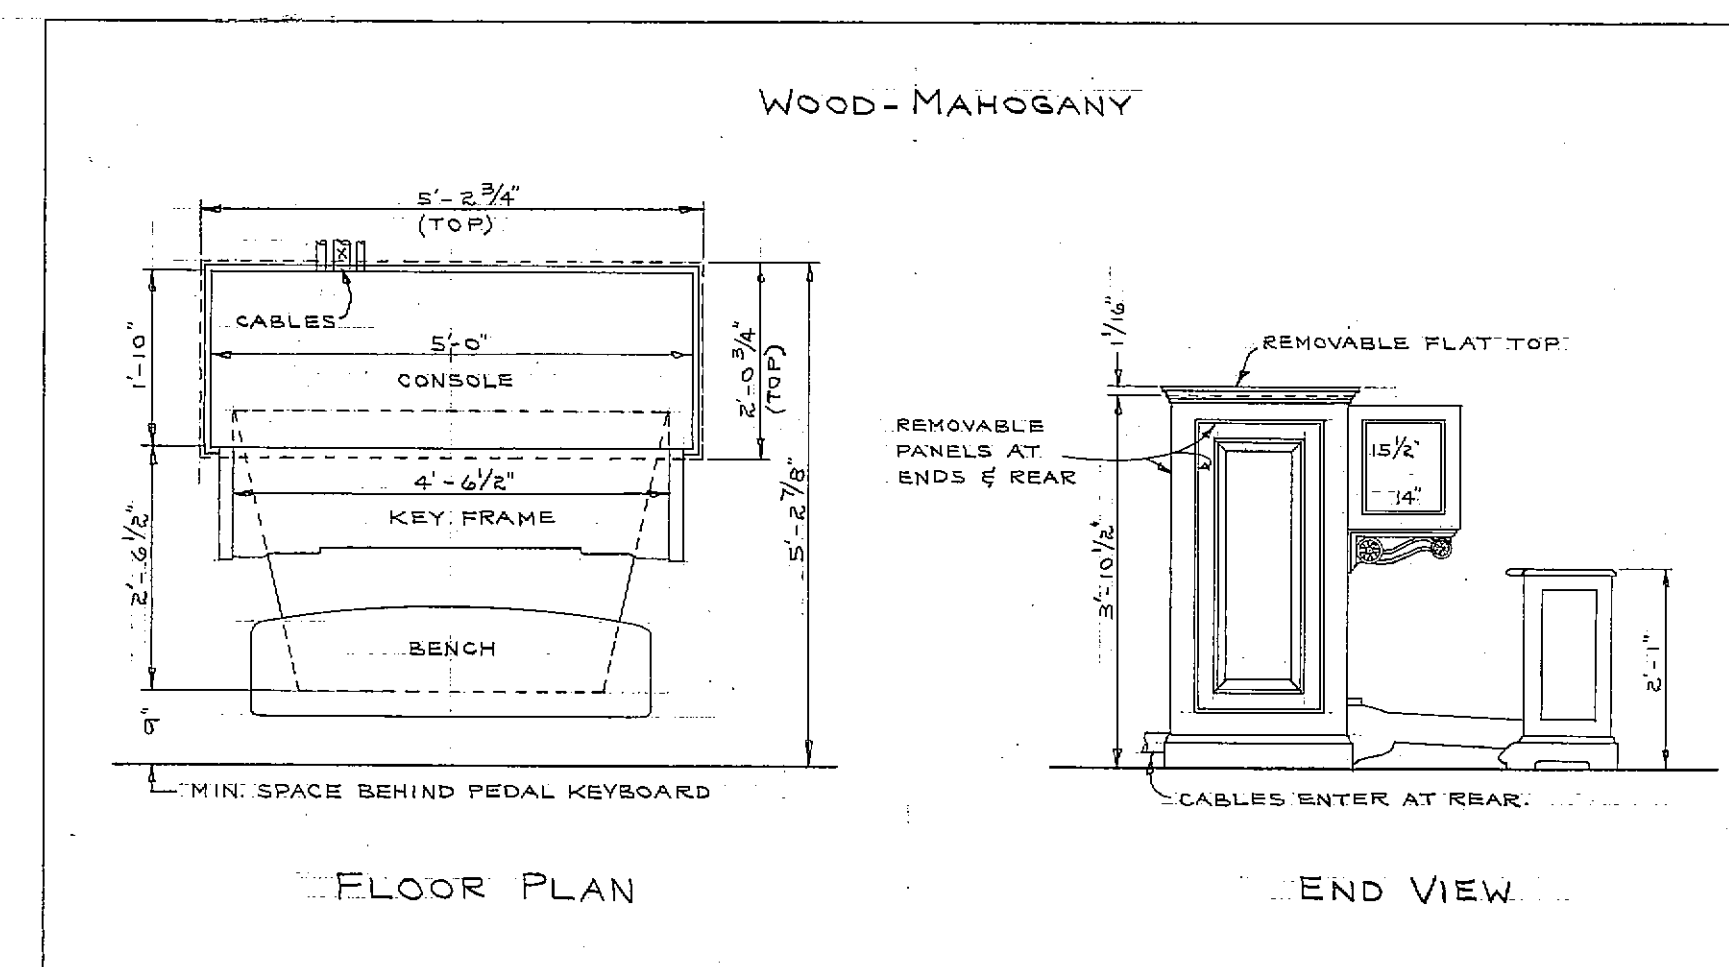

FLOOR PLAN

END VIEW

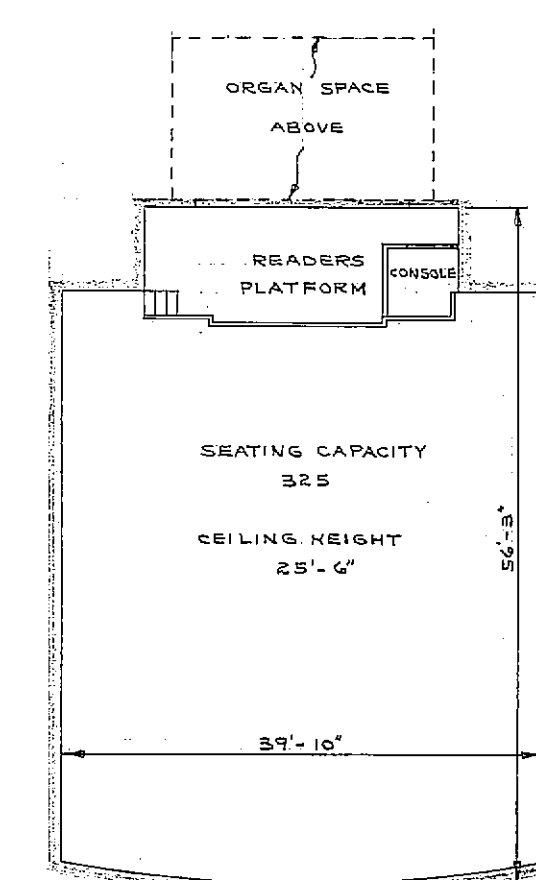

AUDITORIUM PLAN

BLOWER SIZE - STYLE SPACES 2 HP MOTOR 12" OUTLET
5'-5" LONG 2'-2" WIDE
10-15 VOLTS, 20 AMP, DC ORGAN POWER UNIT
SUPPLY 3'-0" X 3'-0" BLOWER RESERVOIR

30 FEET OF CABLES WILL BE REQUIRED FROM @ IN CONSOLE TO @ IN ORGAN.
CABLES REQUIRED:
GREAT RELAY ONE 77 COND.
SWELL STATION ONE 77 COND.
PEDAL RELAY & STOPS ONE 44 COND.
GREAT, SWELL STOPS & SHADES ONE 44 COND.

ACTION CURRENT WIRES REQUIRED:
DC ORGAN POWER UNIT TO CONSOLE -
61 FEET 3/4" R/C STRANDED FOR KEY COMMON (-)
61 FEET 3/4" R/C STRANDED FOR MAGNET COMMON (-)
DC ORGAN POWER UNIT TO ORGAN -
50 FEET 3/4" R/C STRANDED FOR MAGNET COMMON (-)
20 FEET 3/4" R/C STRANDED FOR KEY COMMON (-)

ONE 12" DIAMETER GALVANIZED IRON WIND CONDUCTOR FROM BLOWER TO ORGAN.
ONE 3" DIAMETER CONDUIT FROM CONSOLE TO ORGAN FOR CABLES.
ONE 1/4" DIAMETER CONDUIT FROM DC ORGAN POWER UNIT TO CONSOLE FOR ACTION CURRENT WIRES.
ONE 1/4" DIAMETER CONDUIT FROM DC ORGAN POWER UNIT TO ORGAN FOR ACTION CURRENT WIRES.
ONE 1/4" DIAMETER CONDUIT FROM CONSOLE TO MOTOR FOR STARTER WIRES.

FULL BOXES SHOULD BE PLACED AT ALL SHARP BENDS OF LARGE CONDUITS. IF CONDUITS ARE NOT REQUIRED BY BUILDING CODES, PROVIDE EQUIVALENT SPACE.

ACTION ELECTRO-PNEUMATIC
GRILLE NONE
DISPLAY PIPES NONE
MANUALS TWO (2) PEDAL
CONSOLE DETACHED - ALL ELECTRIC - MAHOGANY
STOP CONTROLS TILTING TABLETS
WIND PRESSURE GR. 3/2, SW. 4, PED. 4
PITCH A-440 @ 10" 8"

WIND CONDUCTORS, CONDUITS & ALL ELECTRICAL WIRING TO BLOWER MOTOR & ORGAN POWER UNIT INCLUDING NECESSARY POWER SUPPLY, AC SAFETY SWITCH, MOTOR & ORGAN POWER UNIT STARTER, CONDUITS & AC WIRING TO ORGAN POWER UNIT, CONDUITS & DC WIRING FROM ORGAN POWER UNIT TO DC SAFETY SWITCH & DC SAFETY SWITCH (PUSH AT 20 AMPERES) ETC. TO BE SUPPLIED & INSTALLED BY PURCHASER. LIGHT OUTLETS, LIGHT CONTROLS, SIGNAL SYSTEM DESIRED AT CONSOLE INCLUDING CONDUITS, WIRING ETC. TO BE SUPPLIED & INSTALLED BY PURCHASER. LIGHT OUTLETS, BULBS, WALL SWITCH & RECEPTACLE WITHIN ORGAN SPACE INCLUDING CONDUITS, WIRING ETC. TO BE SUPPLIED & INSTALLED BY PURCHASER.

MMH, INC. TO SUPPLY THE FOLLOWING WITH BLOWER:
SIX NO. 368-5-18, 150 LBS. VIBRATION ELIMINATORS (THREE UNDER EACH BASE RAIL)

CONSOLE APPROVED BY PERCY, SHAW, HEPBURN, & DEAN (ARCHITECTS) DATE 3-19-57
DIMENSIONS OK BY D. V. CORBETT DATE 3-5-58

FIRST CHURCH OF CHRIST, SCIENTIST,
LYNN, MASS.

SCALE - 1/4" = 1'-0"
LAYOUT TRACED CHKD DATE M. P. MÖLLER, INC. 9061
W.A.R. S.W. P. 3-28-58 HAGERSTOWN, MD. DRAWING NO. 102