




GRILLE TO BE MANUFACTURED IN
TWO SECTIONS.

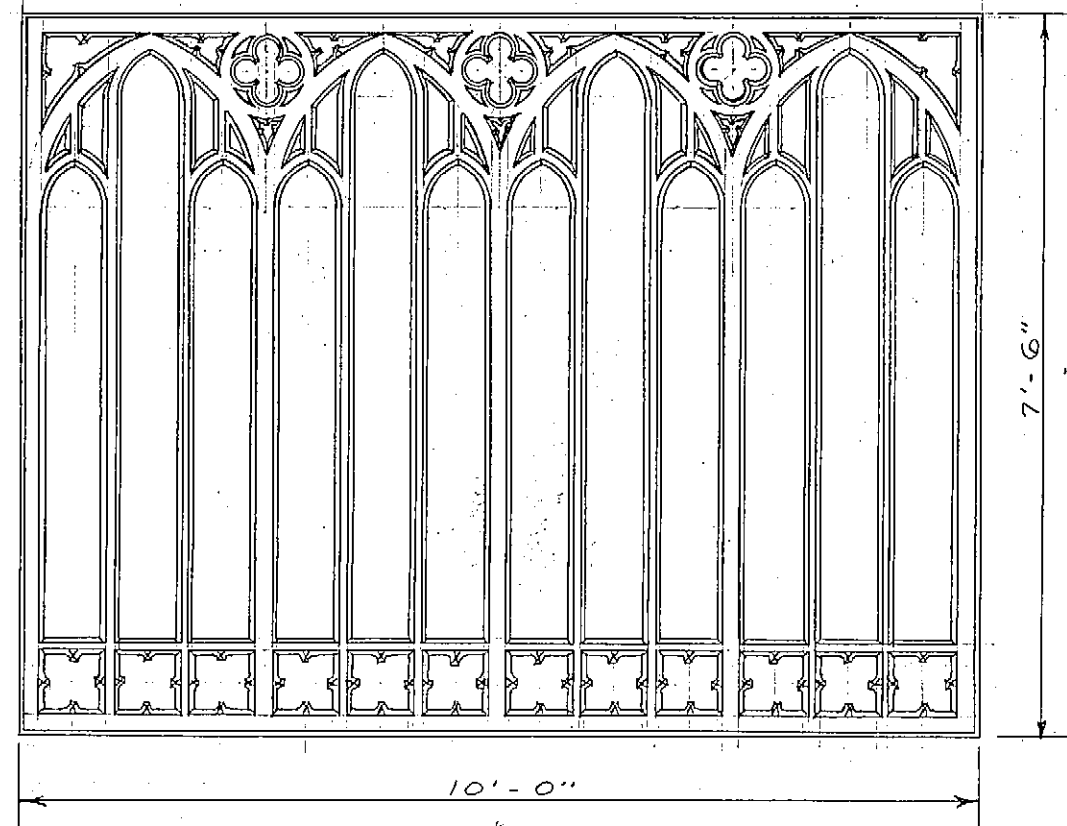

ELEVATION

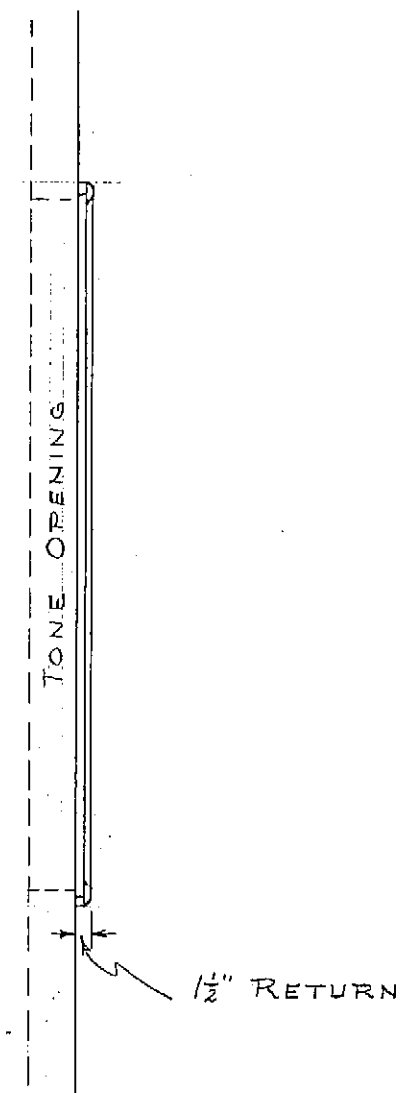

END VIEW

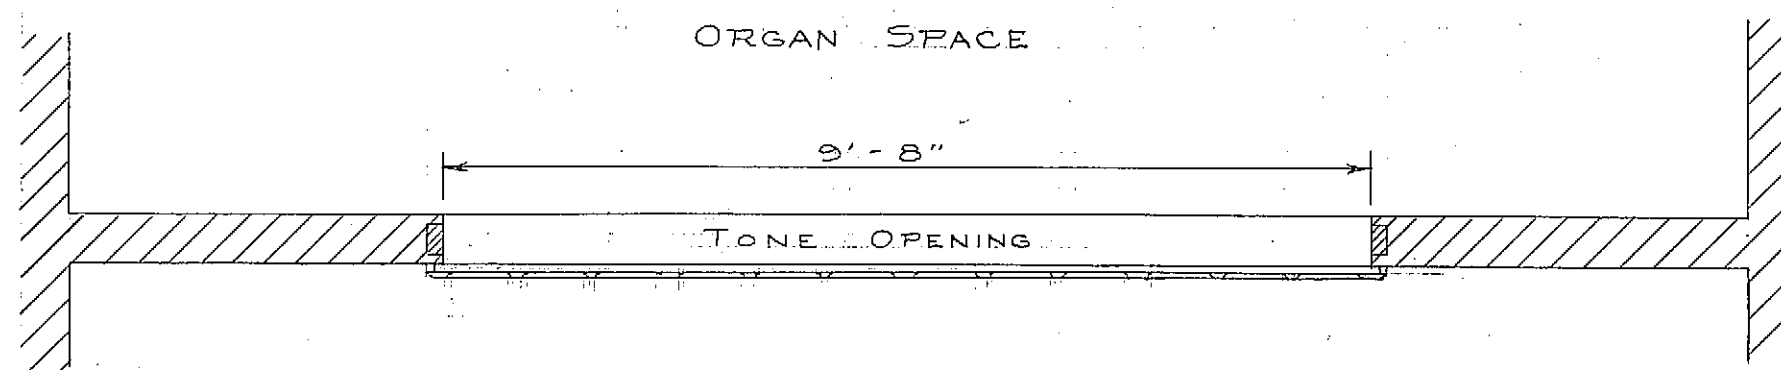

PLAN

NOTE
OPEN AREA BEHIND GRILLE TO
HAVE CLOTH BACKING.

WOOD — QUARTER SAWN RED OAK
FINISH — TO COLOR BLOCK
FOR CONSOLE

CLOTH — #1148/41" COLOR #438

APPROVED BY R. S. HUGHART DATE 5-19-46

KNOX PRESBYTERIAN CHURCH,
SPOKANE, WASH.

SCALE — 1/2" = 1'-0"


DRAWN CH'K'D DATE
Frost 5-4-46

M. P. MÖLLER, INC.
HAGERSTOWN, MD.

7179


DRAWING # 103

CHIMES - DEAGAN "D" ELECTRIC ACTION
A TO F - #22 TO #42 - 21 TUBES

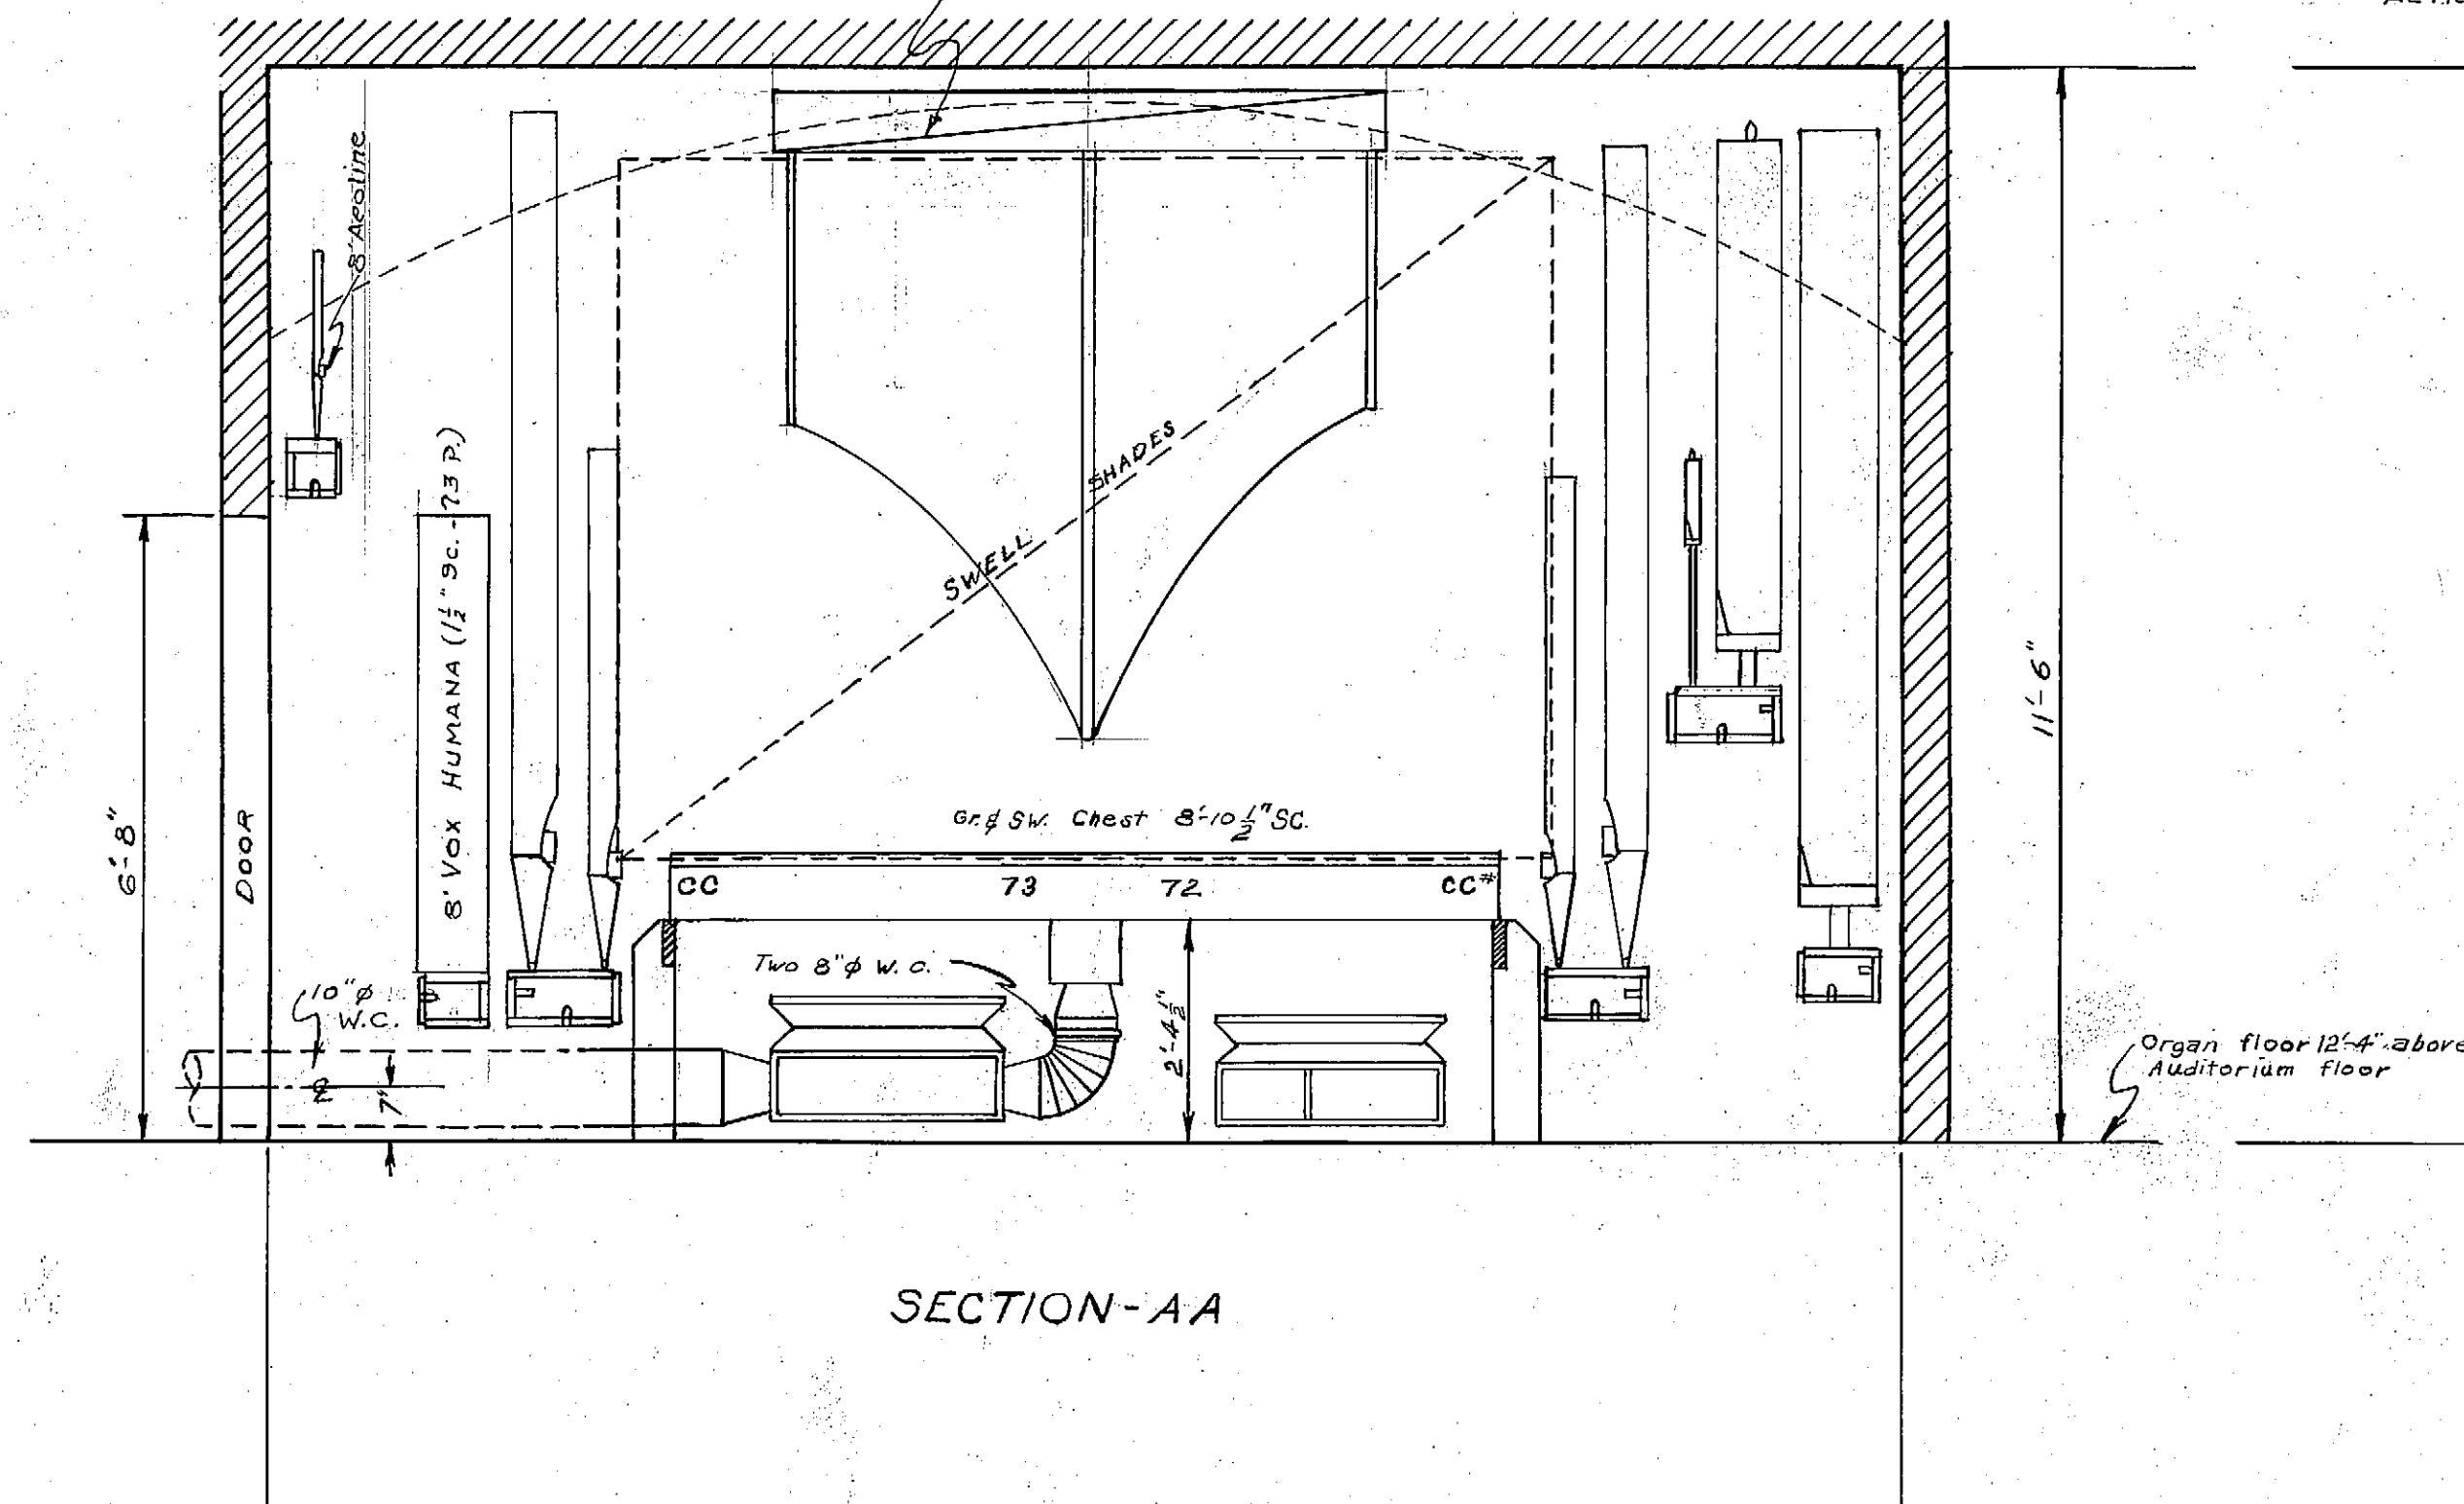


SECTION-AA


DEAGAN "A" ELECTRO-PNEUMATIC ACTION
INSTALLED 7/8/46 & REPLACED WITH
DEAGAN "D" ELECTRIC ACTION 10/2/47. CHIME
ACTION & DEAGAN "A" CHIMES INSTALLED IN #6861 SEATTLE, WASH.

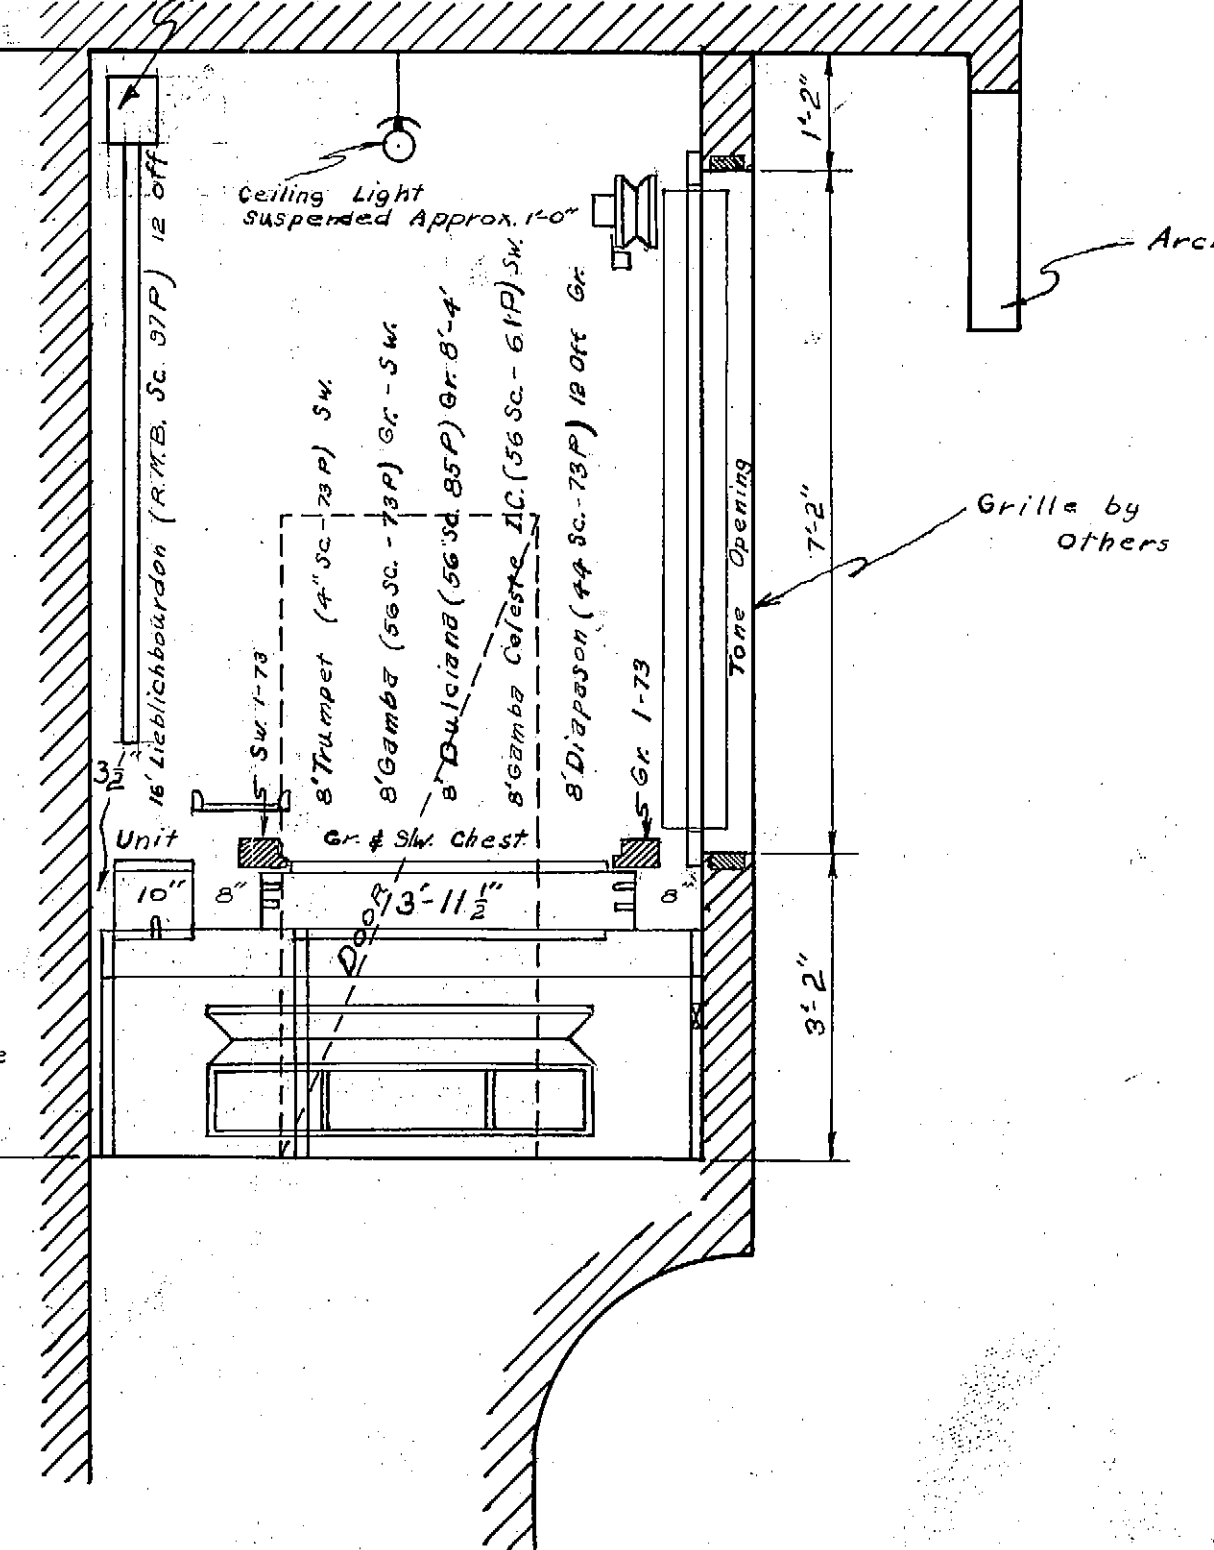

SECTION-BB

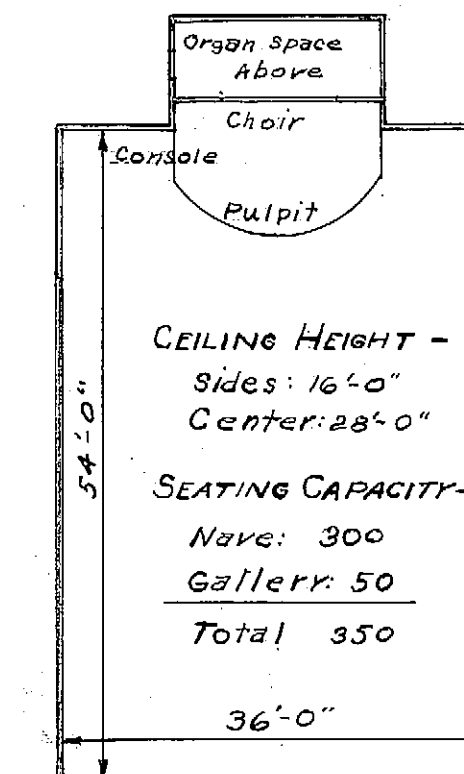


AUDITORIUM PLAN
Scale: 1/8" = 1'-0"

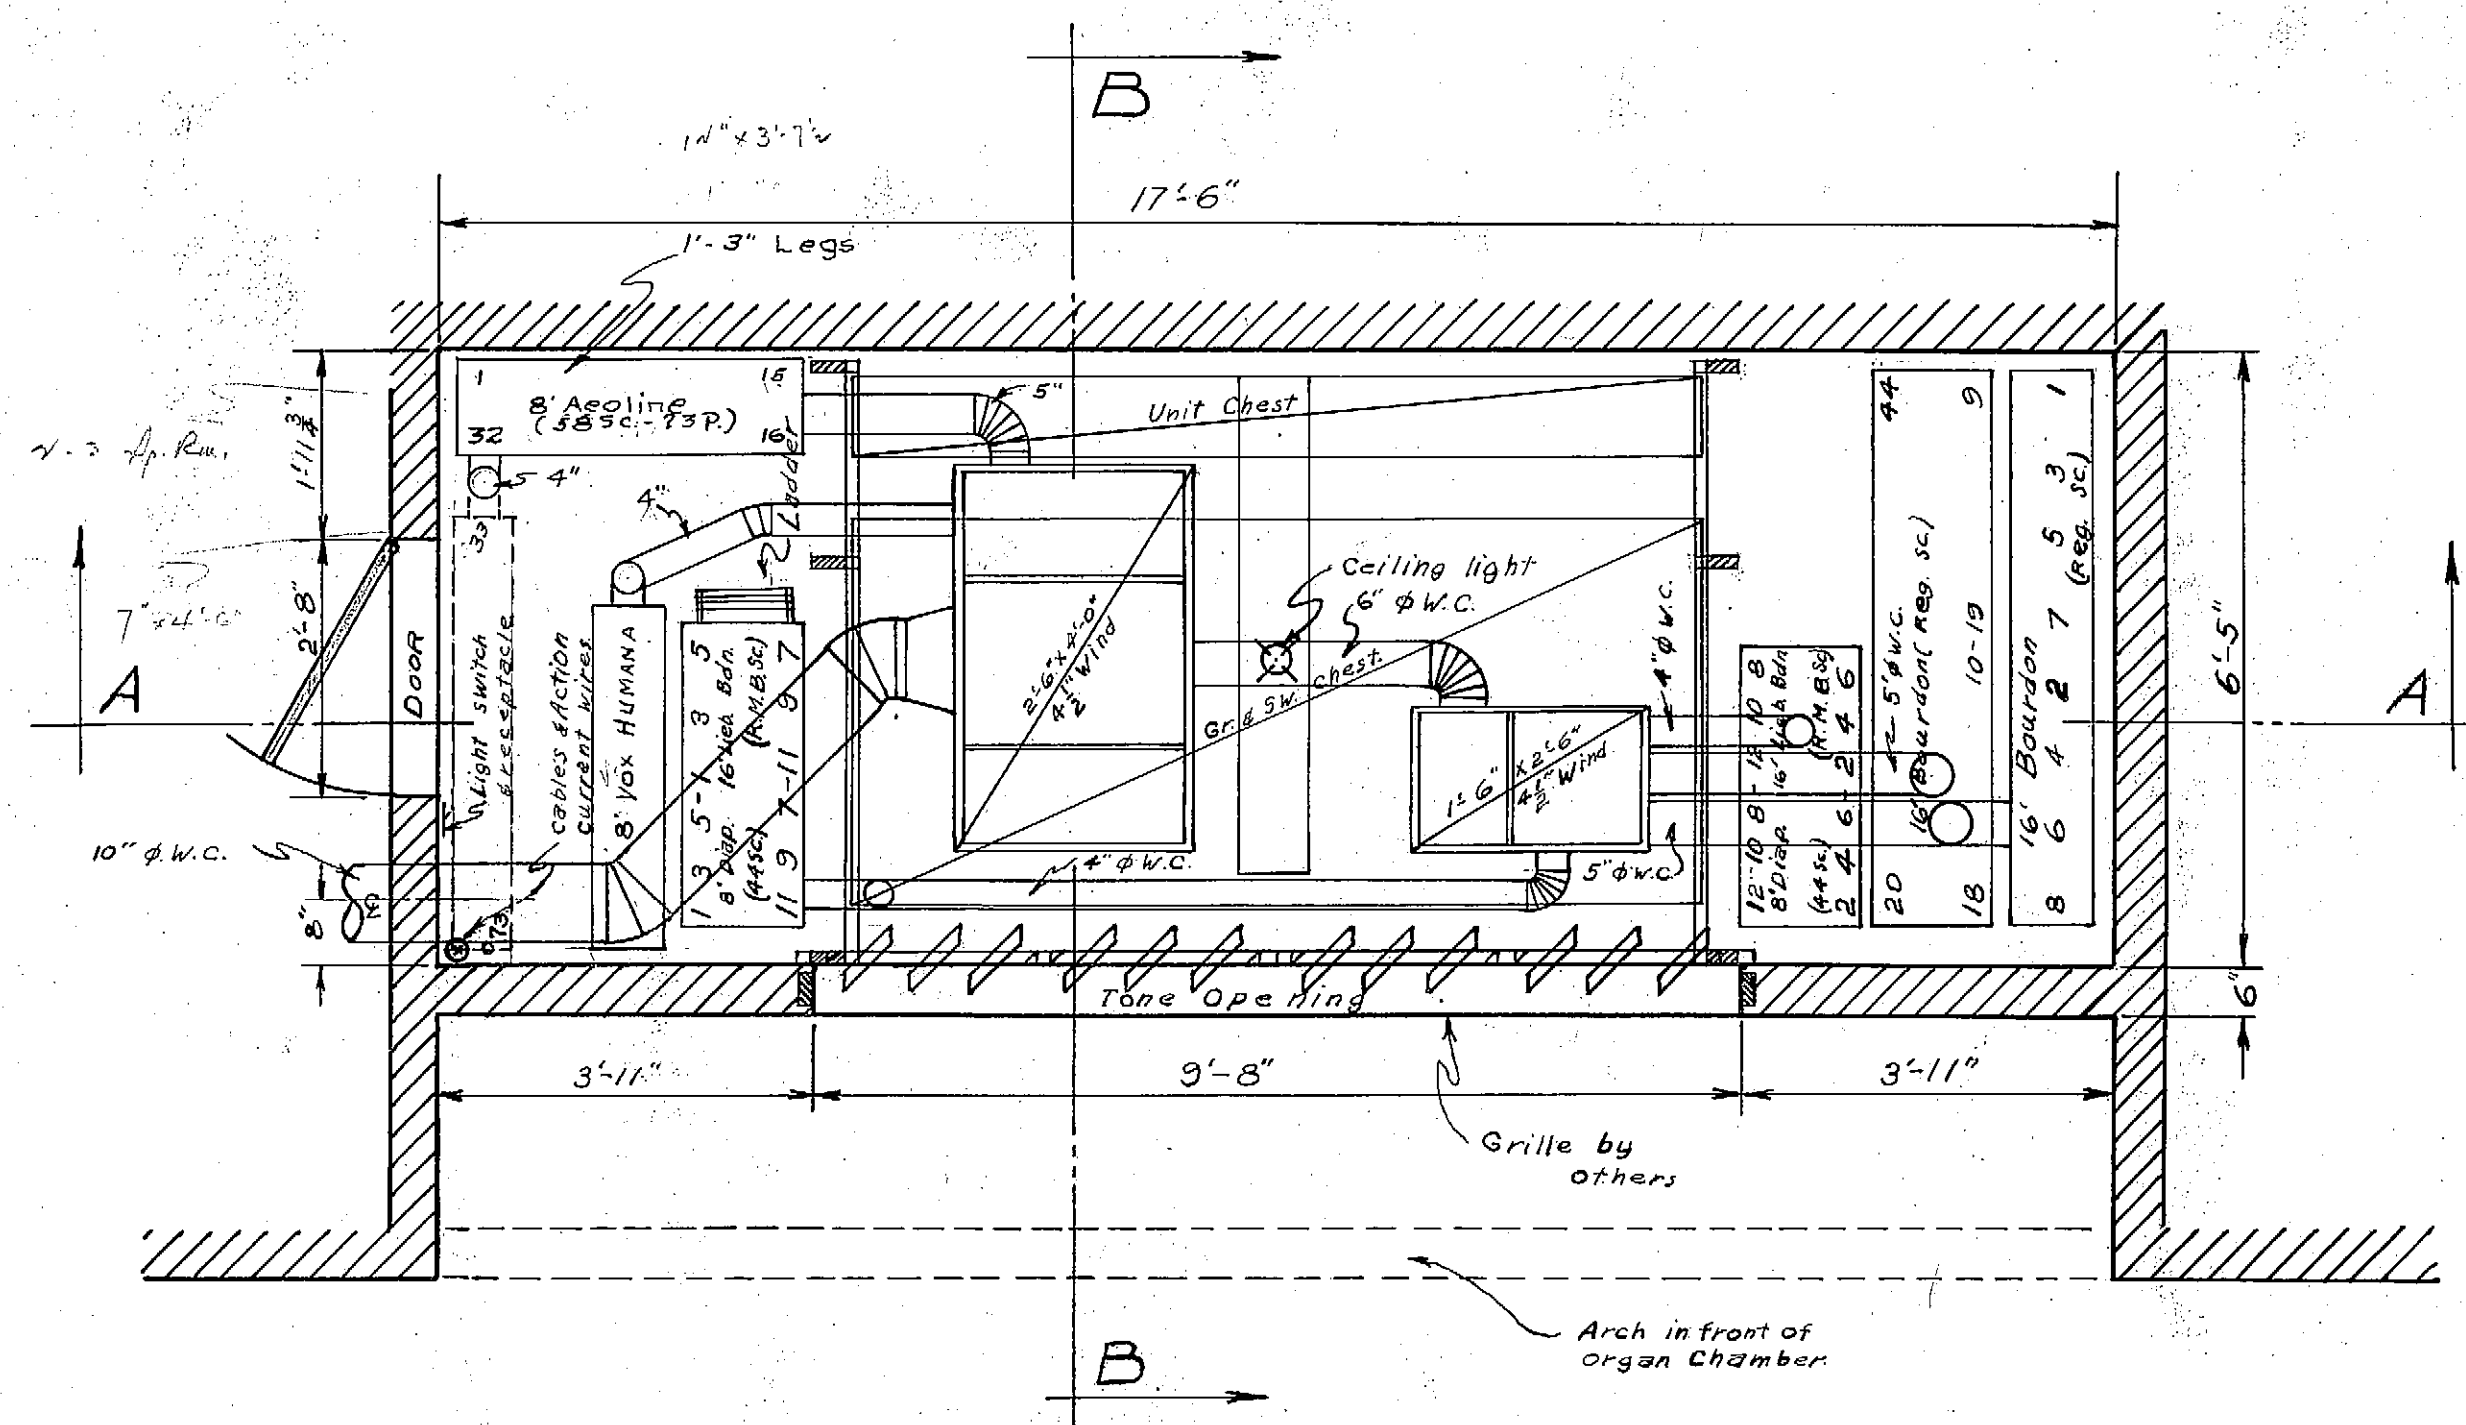

FLOOR PLAN

CONSOLE

AUDITORIUM

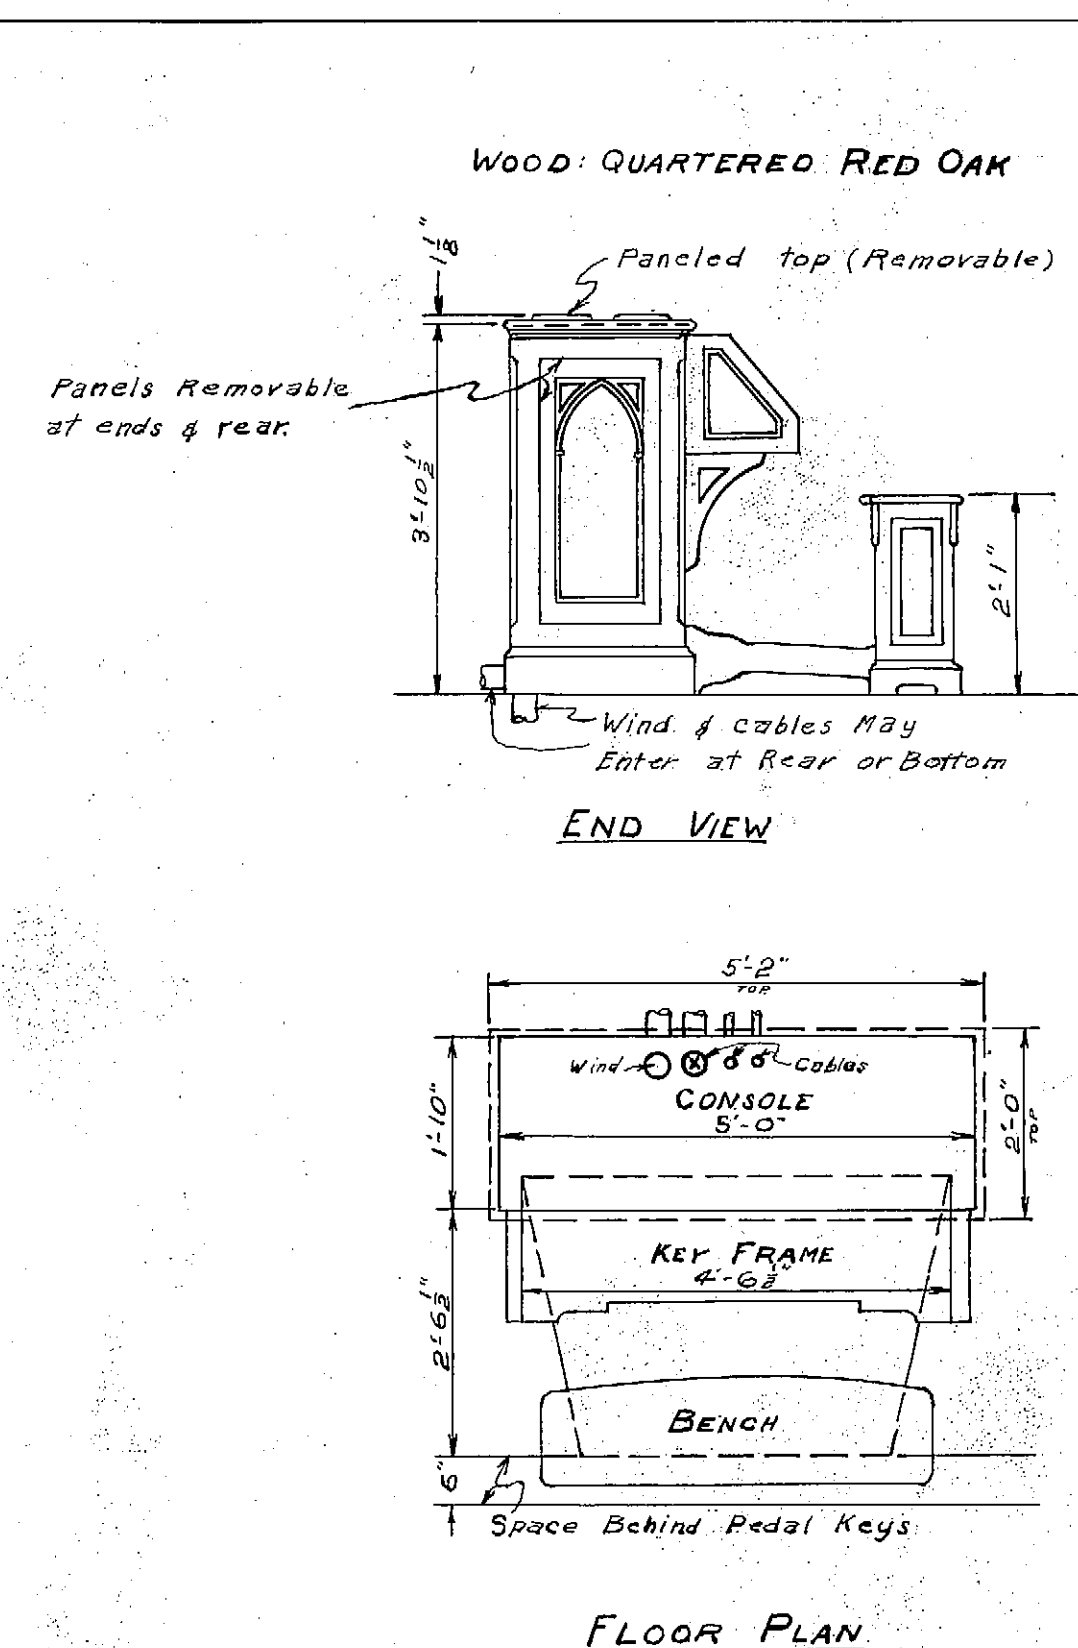

Blower Size - Style 3P2722 1 H.P. Motor 10" Outlet
6'-0" Long 2'-5" Wide 3'-0" High.
Supply Baffle Box.

25 feet of cables will be required from @ in console to @ in organ.
Cables required: Great station 77 Cond. Swell station 77 Cond.
Great & Swell stops, shades & tremolo 33 Cond.
16' Bourdon 44 Cond. 16' Lieblich Bourdon 66 Cond.

One 10" diameter galvanized iron wind conductor from blower to organ.
One 3" diameter galvanized iron wind conductor from nearest wind supply to console.
One 2 1/2" diameter conduit from console to organ for cables.
One 3/4" diameter conduit from console to motor for starter wires.
One 1" diameter conduit from generator to console & to organ for action current wires.

Pull boxes should be placed at all sharp bends of large conduits. If conduits are not required by building codes, provide equivalent space.

Action _____ Electric
Casing _____ None
Display Pipes _____ None
Manuals _____ Two
Console _____ Detached-Quartered Red Oak.
Stop Controls _____ Stop Keys
Wind Pressure _____ 4 1/2" @ 2200 ft. Elevation
Pitch _____ A-440 @ 70°F

Blower pipe, conduits & all electrical wiring to motor including starter wires & switch at console by purchaser.

CONSOLE APPROVED BY: H.S. HOFFMANN DATE: 4-29-45
DIMENSIONS OK BY: G.A. GRAHAM DATE: 3-15-45

KNOX PRESBYTERIAN CHURCH
SPOKANE, WASH.

Scale: 1/8" = 1'-0"
Layout/Traced/Ch' & d/ Date
Rev. 7-8-46 C.L.C. K.R.A. C.L.C. 2-11-46 M.P. MÖLLER, Inc. Hagerstown, Md. 7179 Drawing #102