
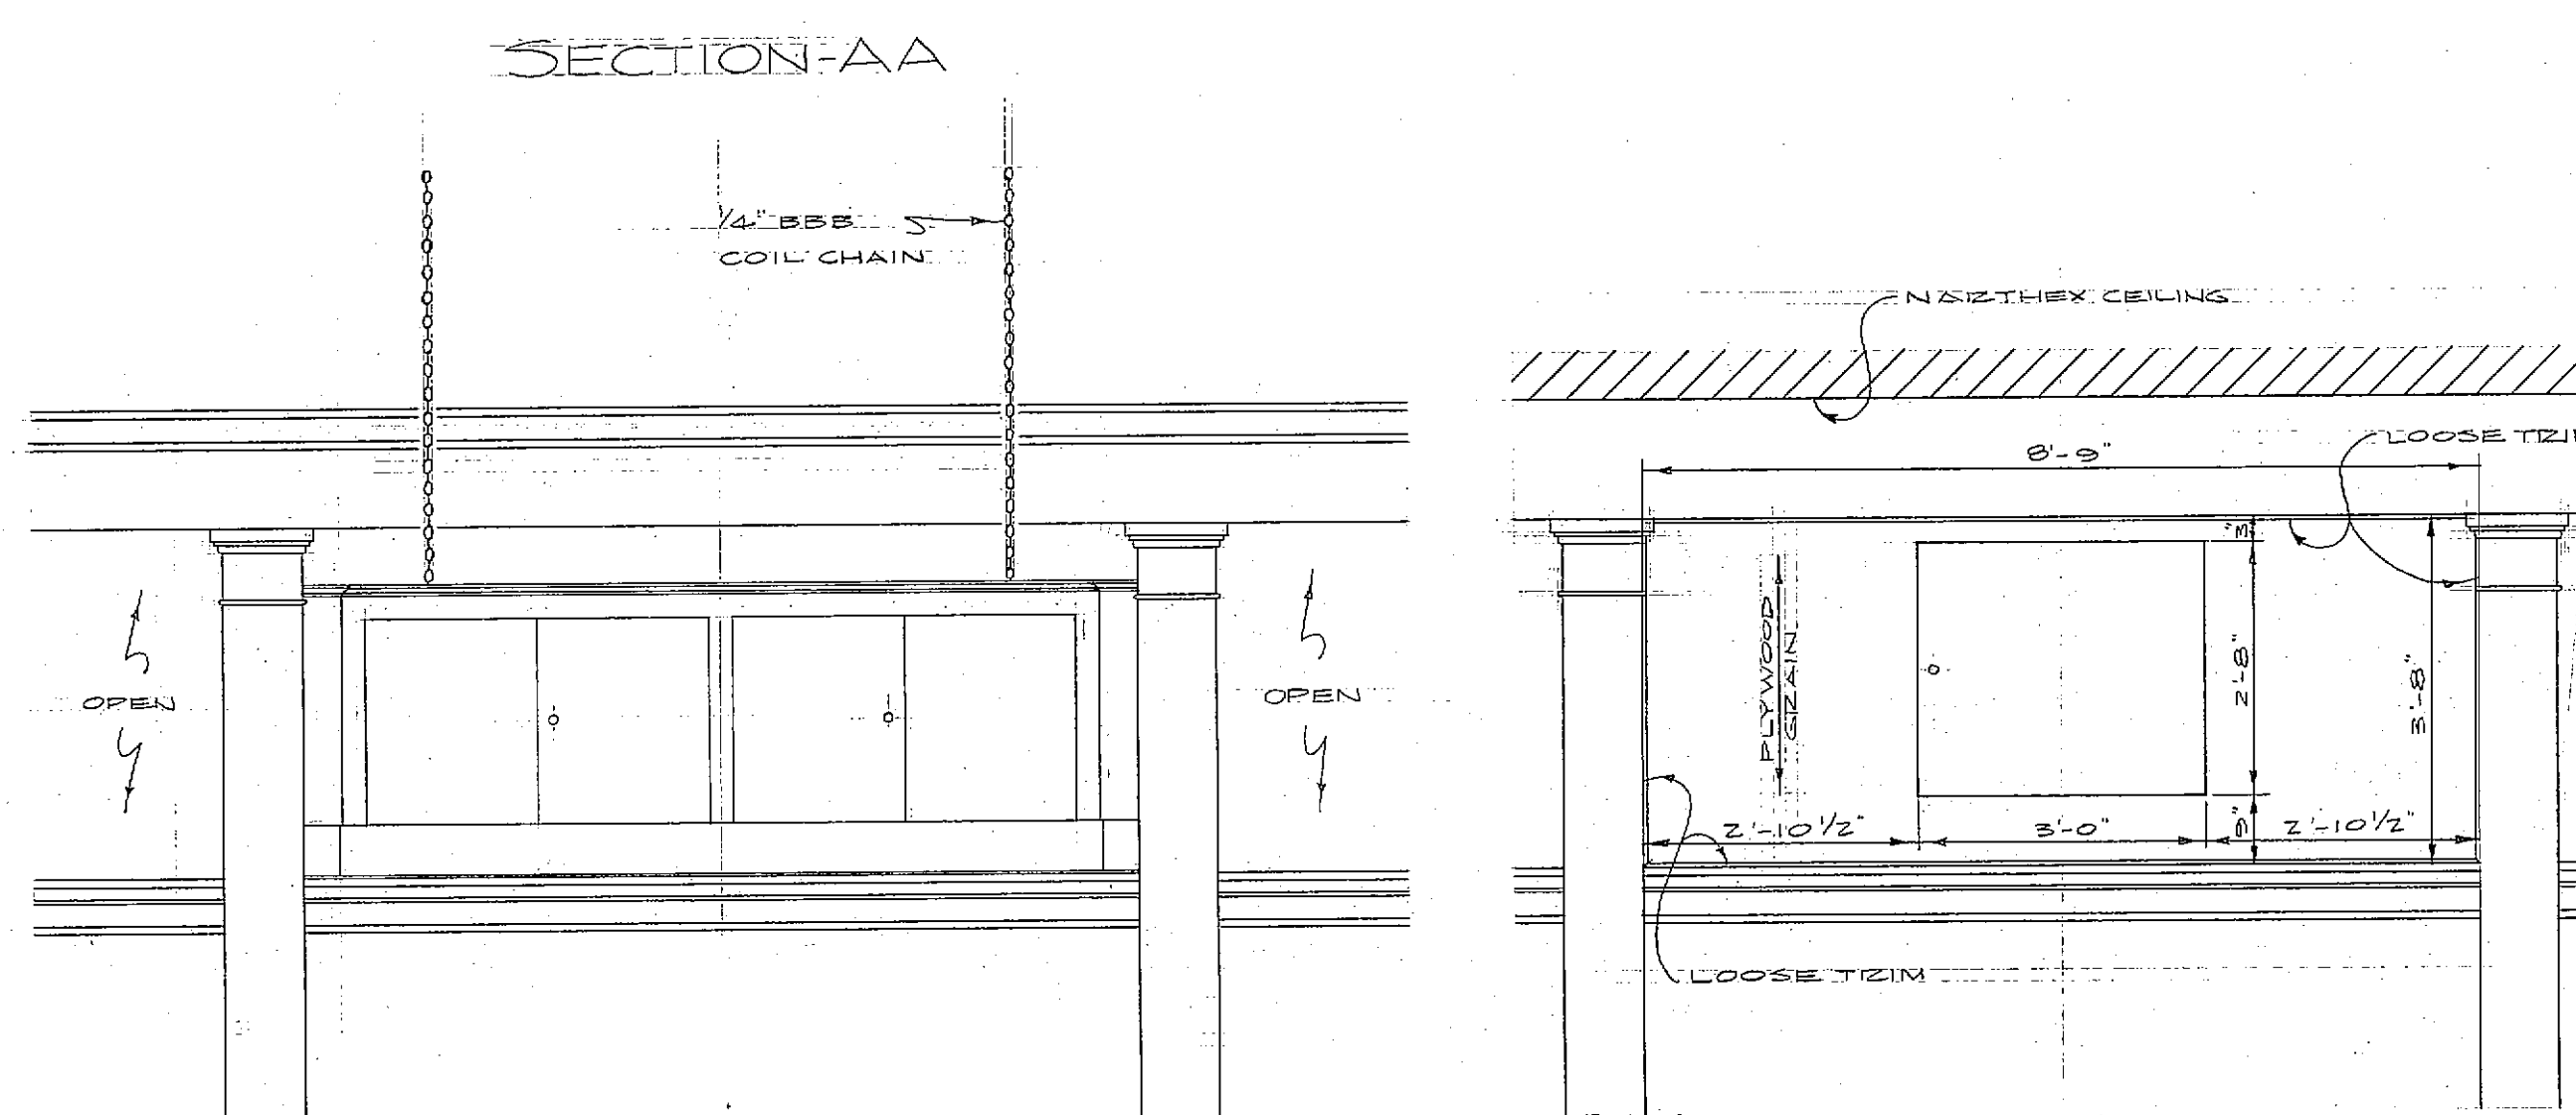
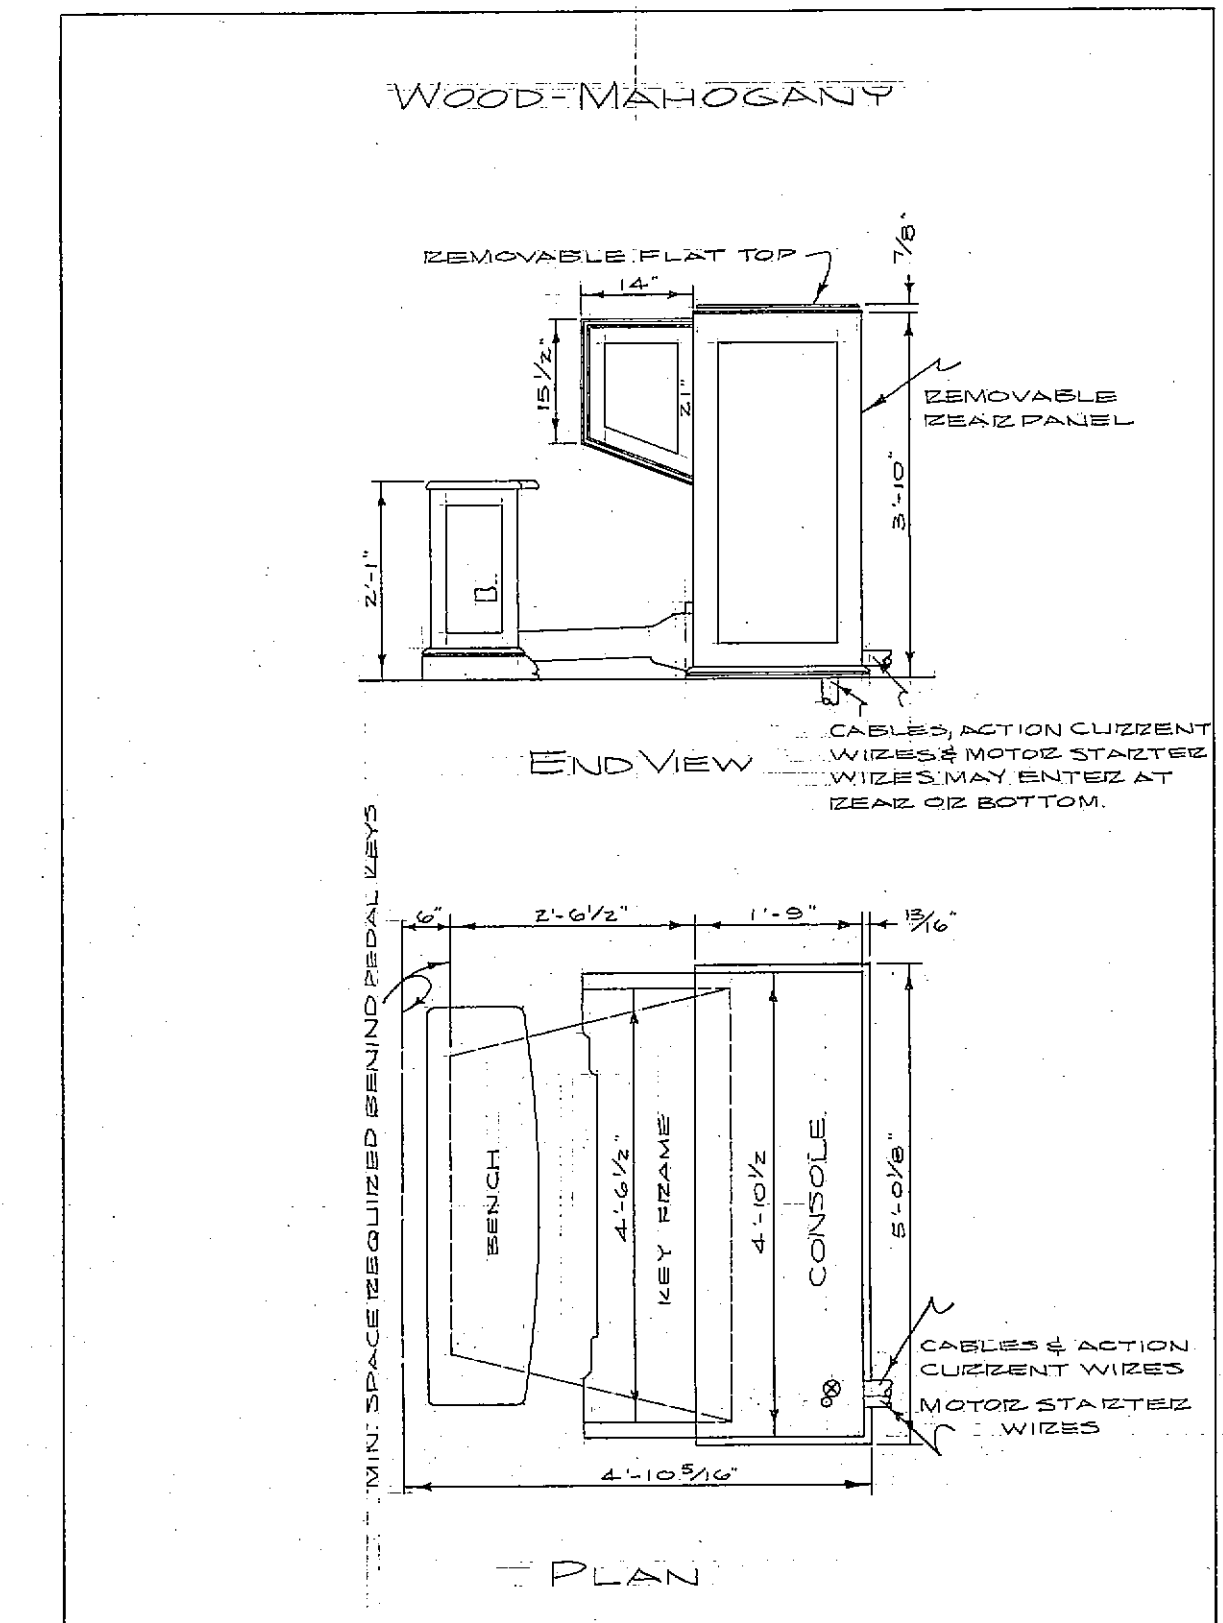
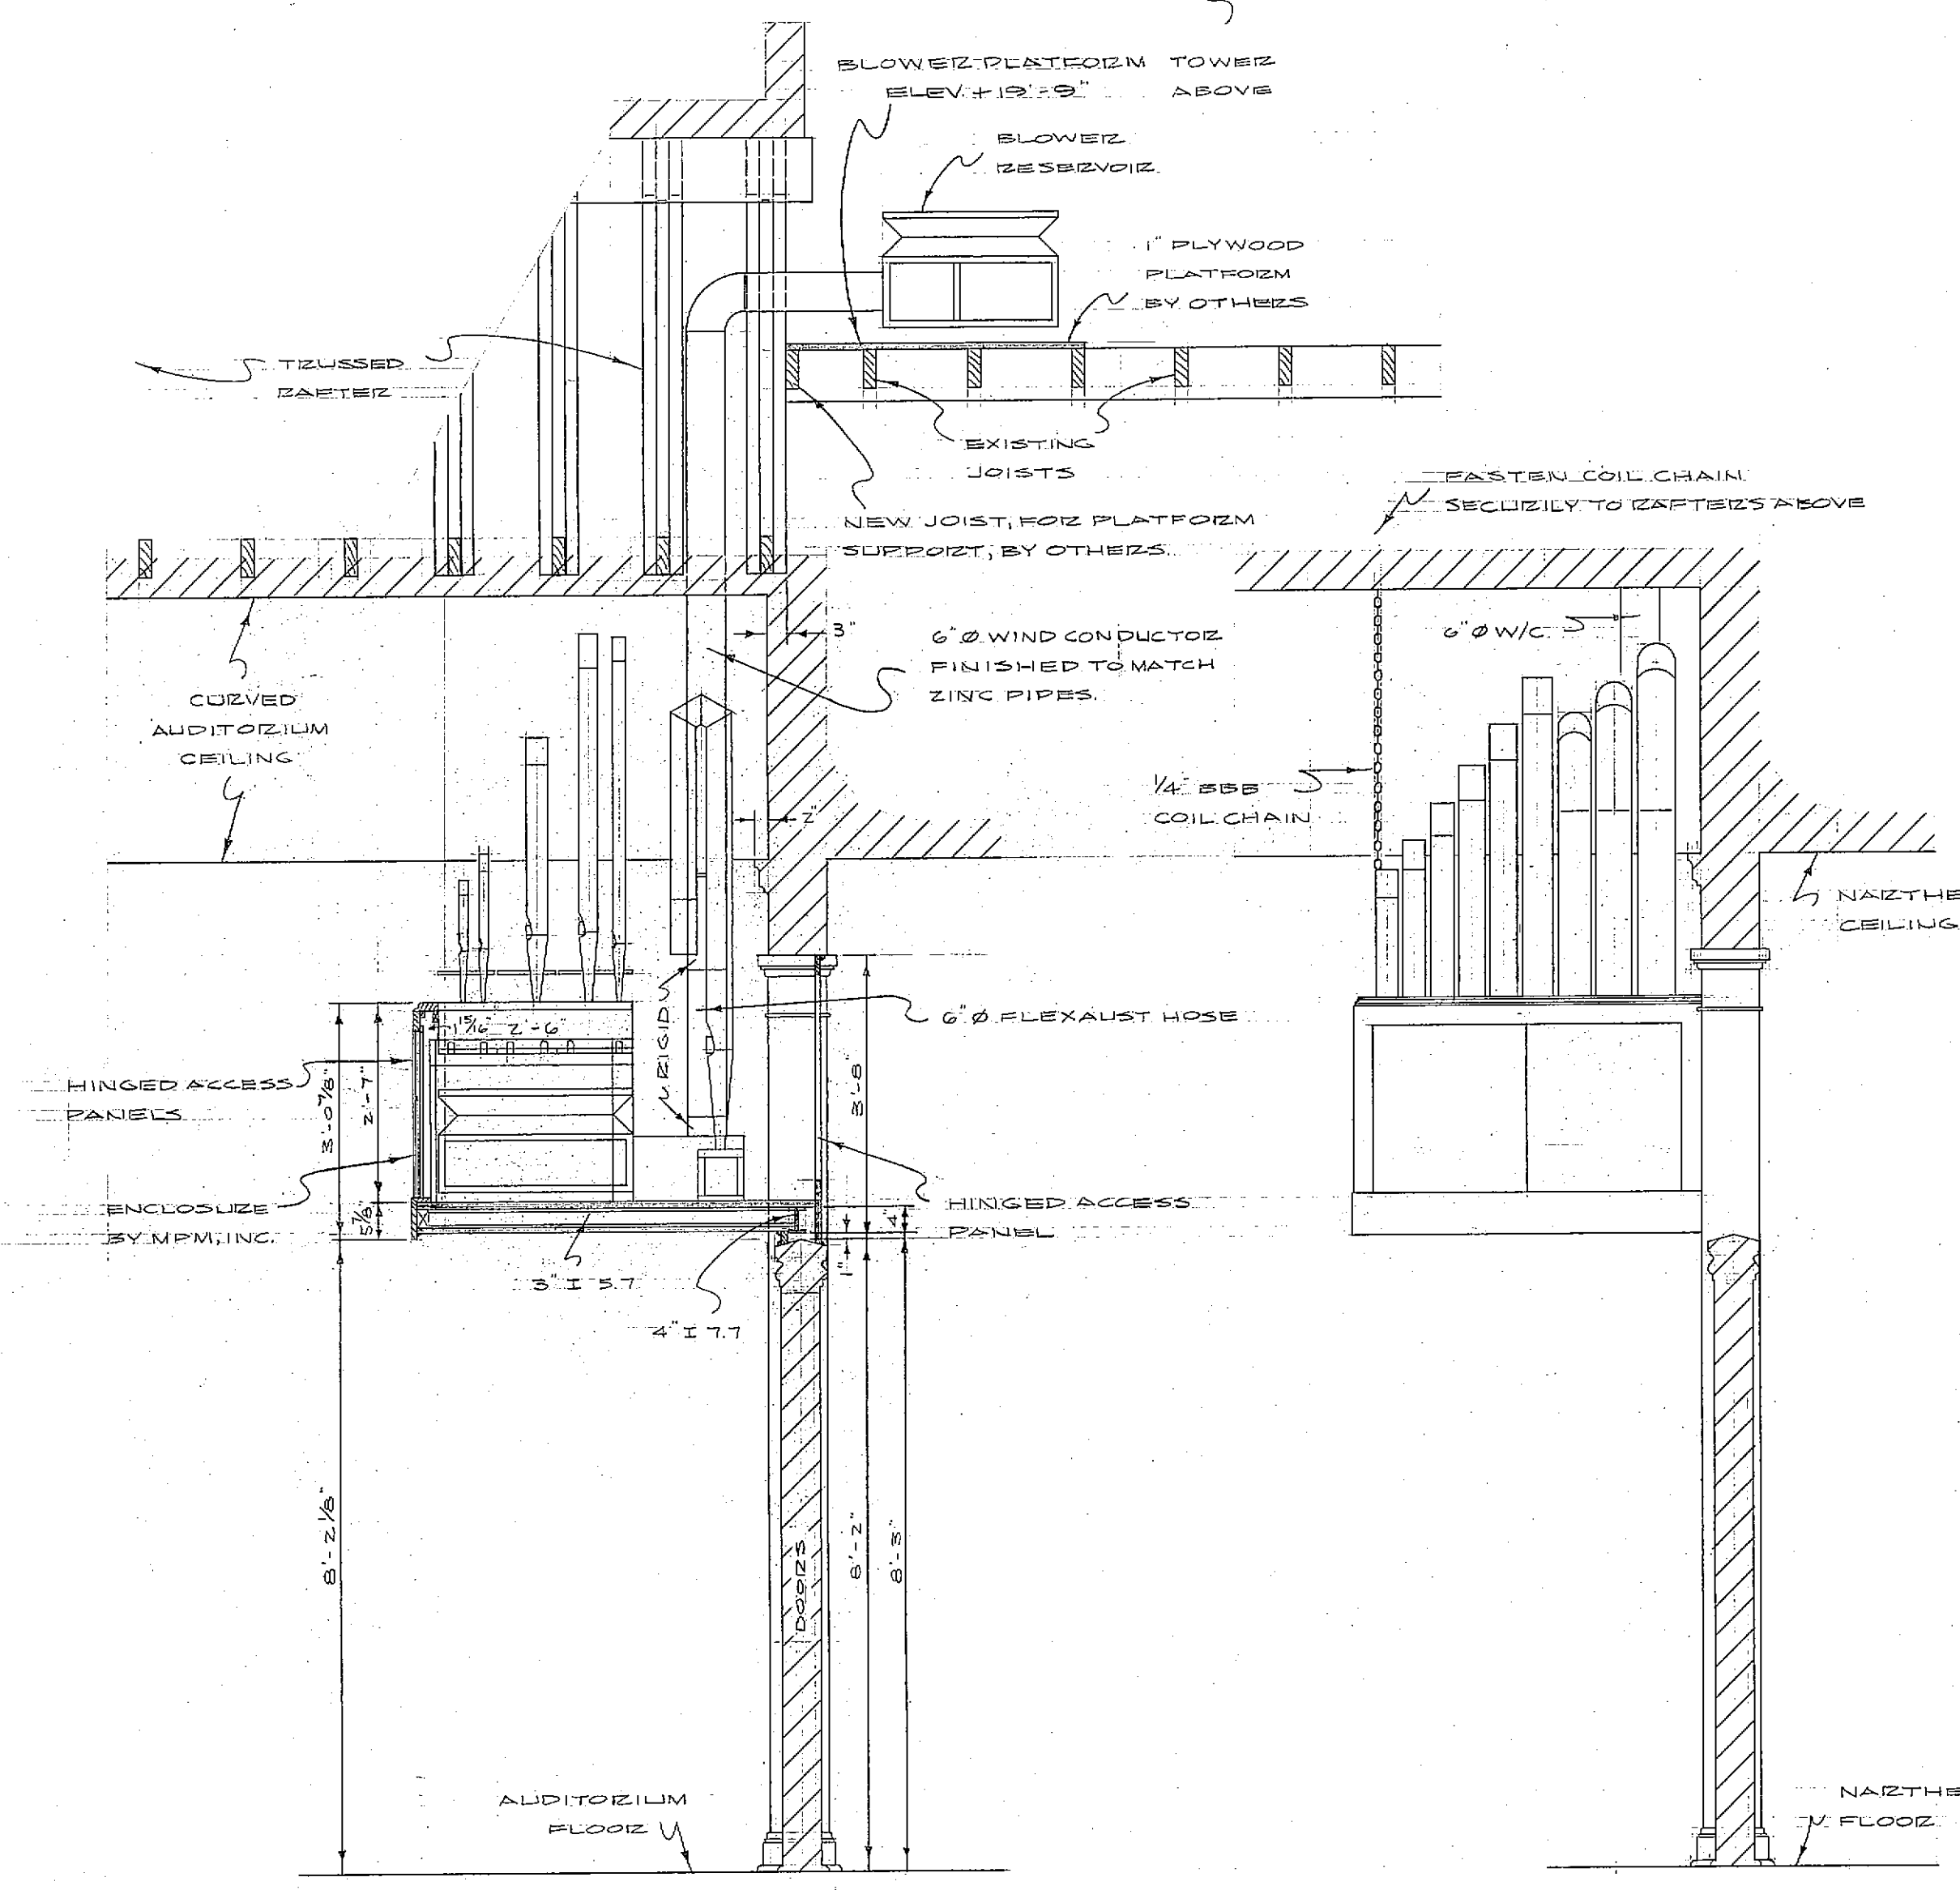


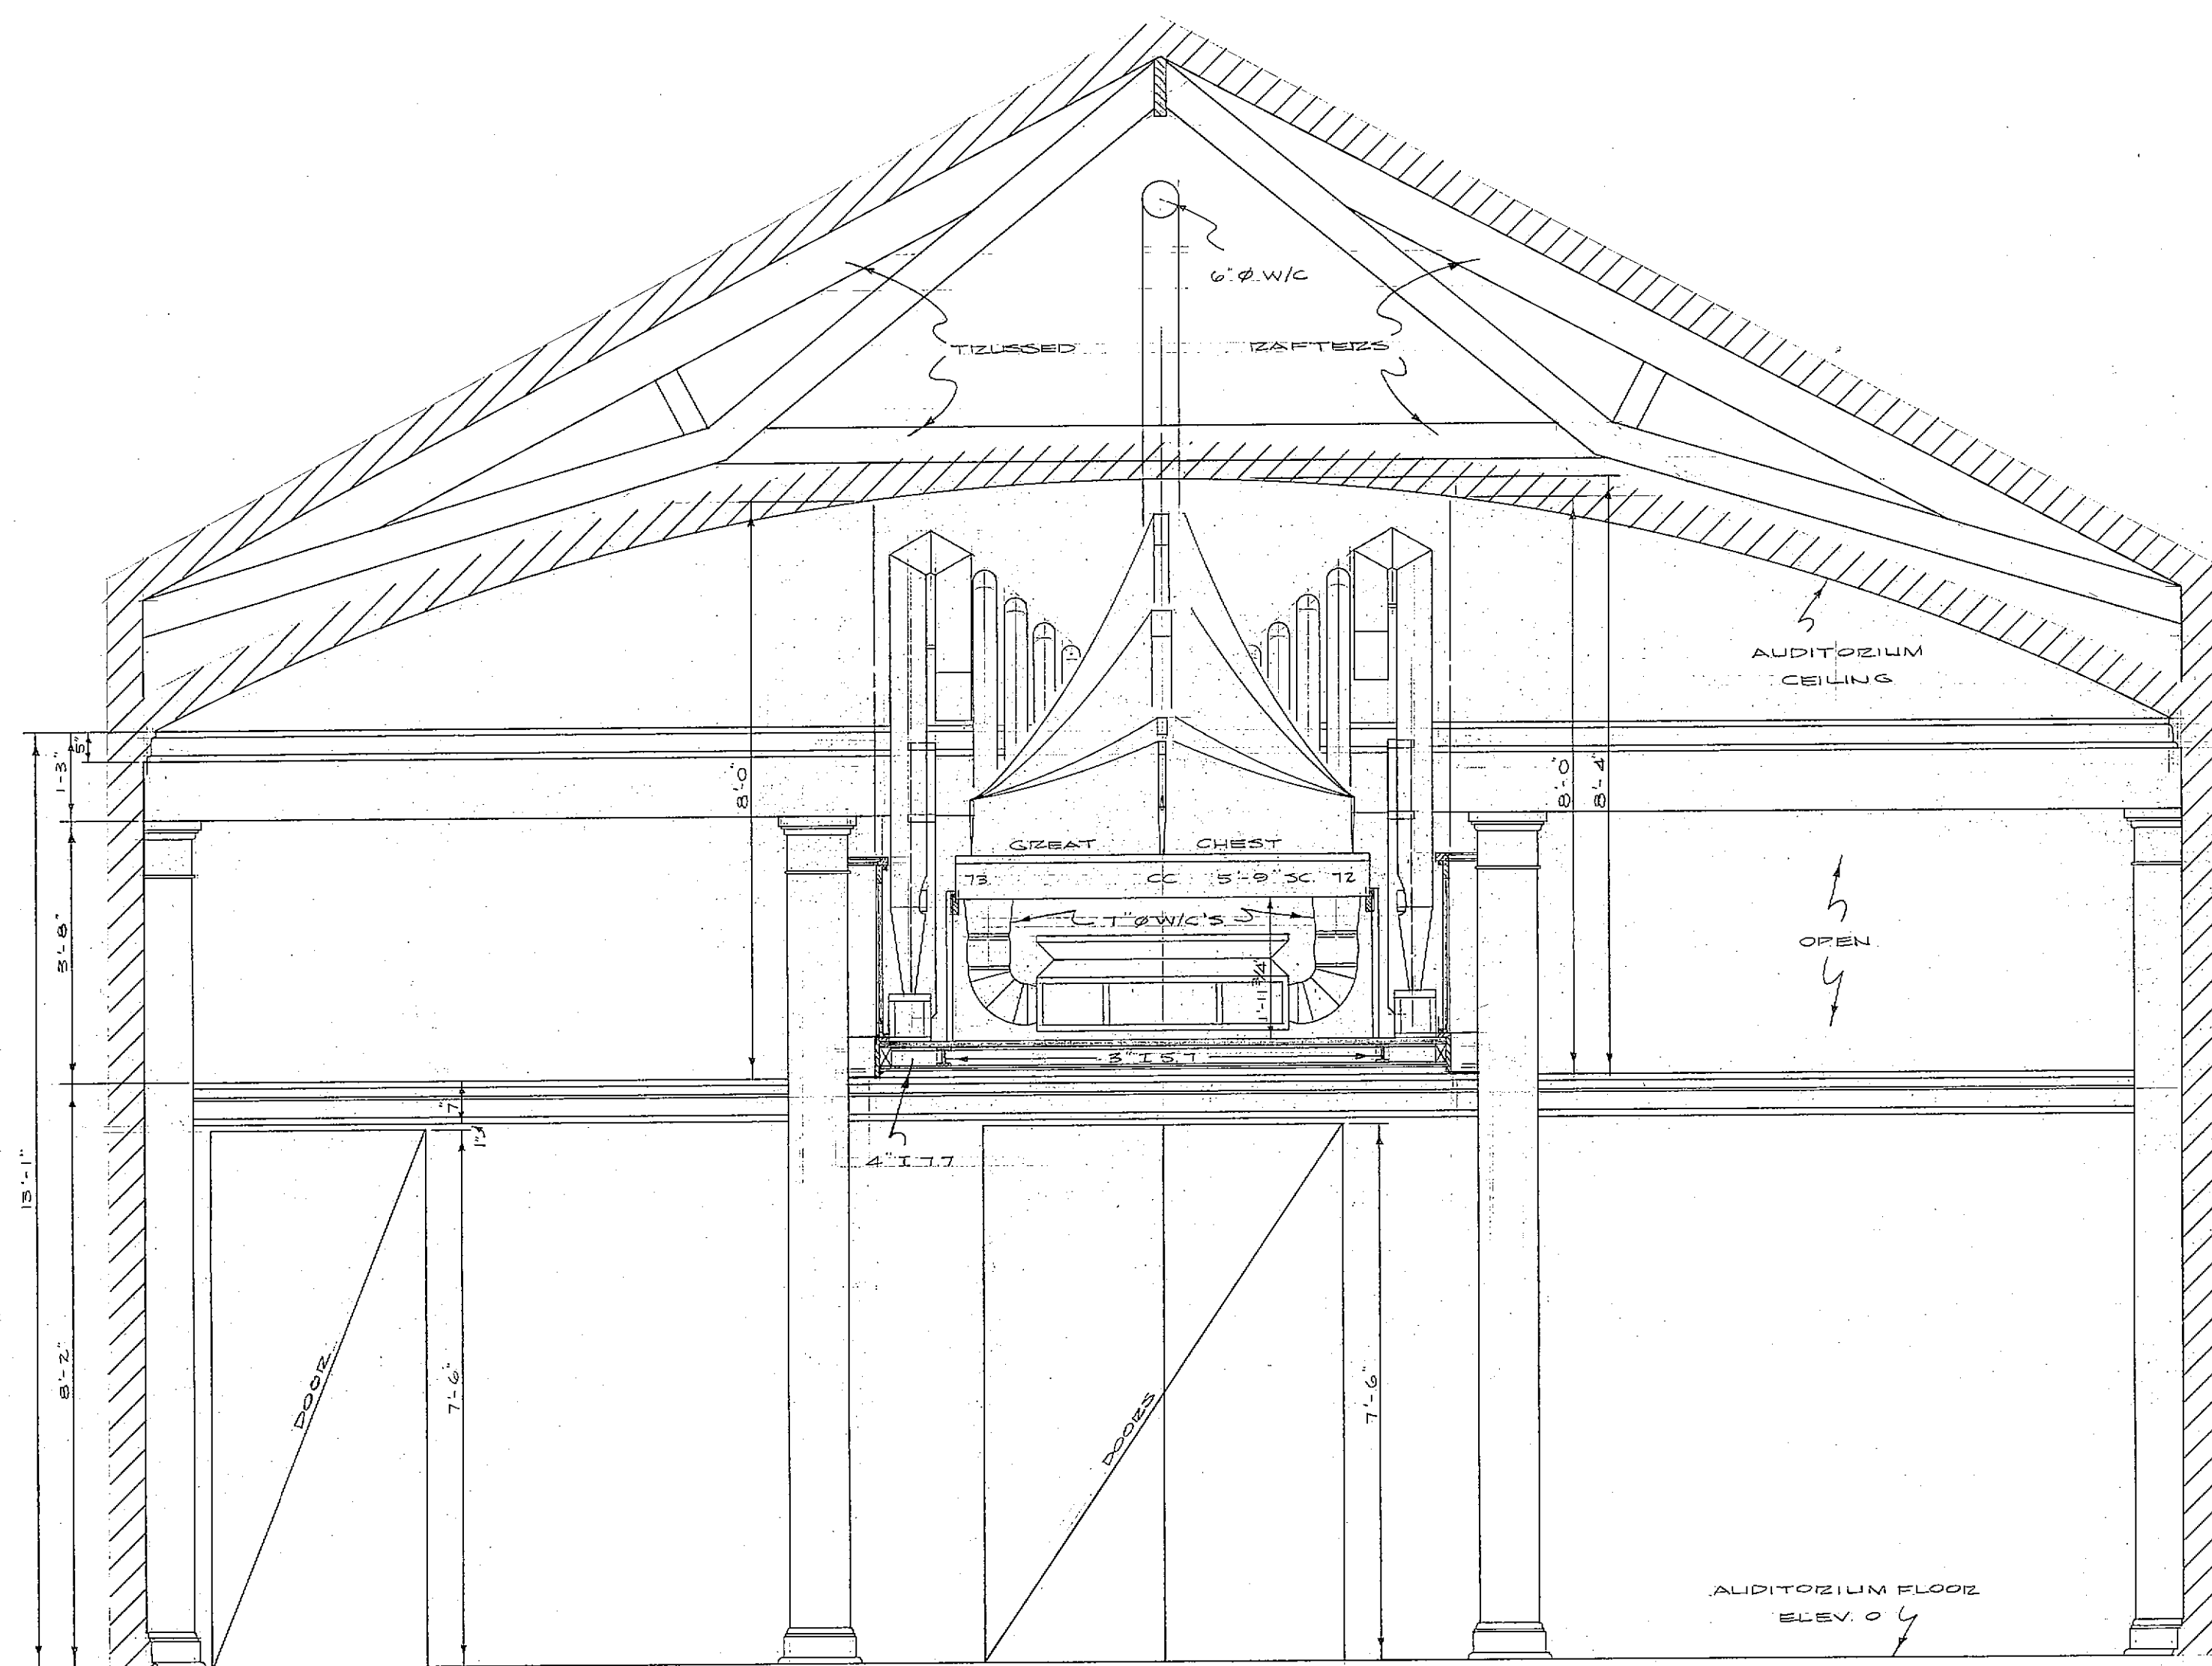

SECTION-BB

END VIEW OF ENCLOSURE

BLOWER SIZE: STYLE 1P2117 1/4 HP MOTOR 6\"/>

20 FEET OF CABLE ACTION CURRENT WIRES WILL BE REQUIRED FROM 6\"/>


ONE 6\"/>

PULL BOXES SHOULD BE PLACED AT ALL SHARP BENDS OF LARGE CONDUITS. IF CONDUITS ARE NOT REQUIRED BY BUILDING CODE PROVIDE EQUIVALENT SPACE.


ACTION — ELECTED-PNEUMATIC — ALL UNITS
CASING — MAHOGANY
DISPLAY PIPES — GREAT ORGAN EXPOSED
MANUALS — TWO & PEDAL
CONSOLE — DETACHED-MAHOGANY — ALL ELECTRIC
STOP CONTROLS — TILTING TABLETS
WIND PRESSURE — 5\"/>

MPM, INC. TO SUPPLY & INSTALL THE FOLLOWING:
ORGAN CABLES & ACTION CURRENT WIRES
WIND CONDUCTOR FROM BLOWER TO ORGAN. SUPPLY 8\"/>



PURCHASER TO SUPPLY & INSTALL THE FOLLOWING:
AC CURRENT SOURCE FOR 3/4 HP MOTOR 1 PH. 60 CY. 220V. 52 AMPS.
1 PC ORGAN POWER UNIT 1 PH. 160 CY. 220V. 17.5 AMPS.
ELECTRICAL CONDUITS LISTED ABOVE, & REQUIRED BY LOCAL CODE.
STEEL FRAMING & COIL CHAIN FOR EXPOSED GREAT ORGAN.

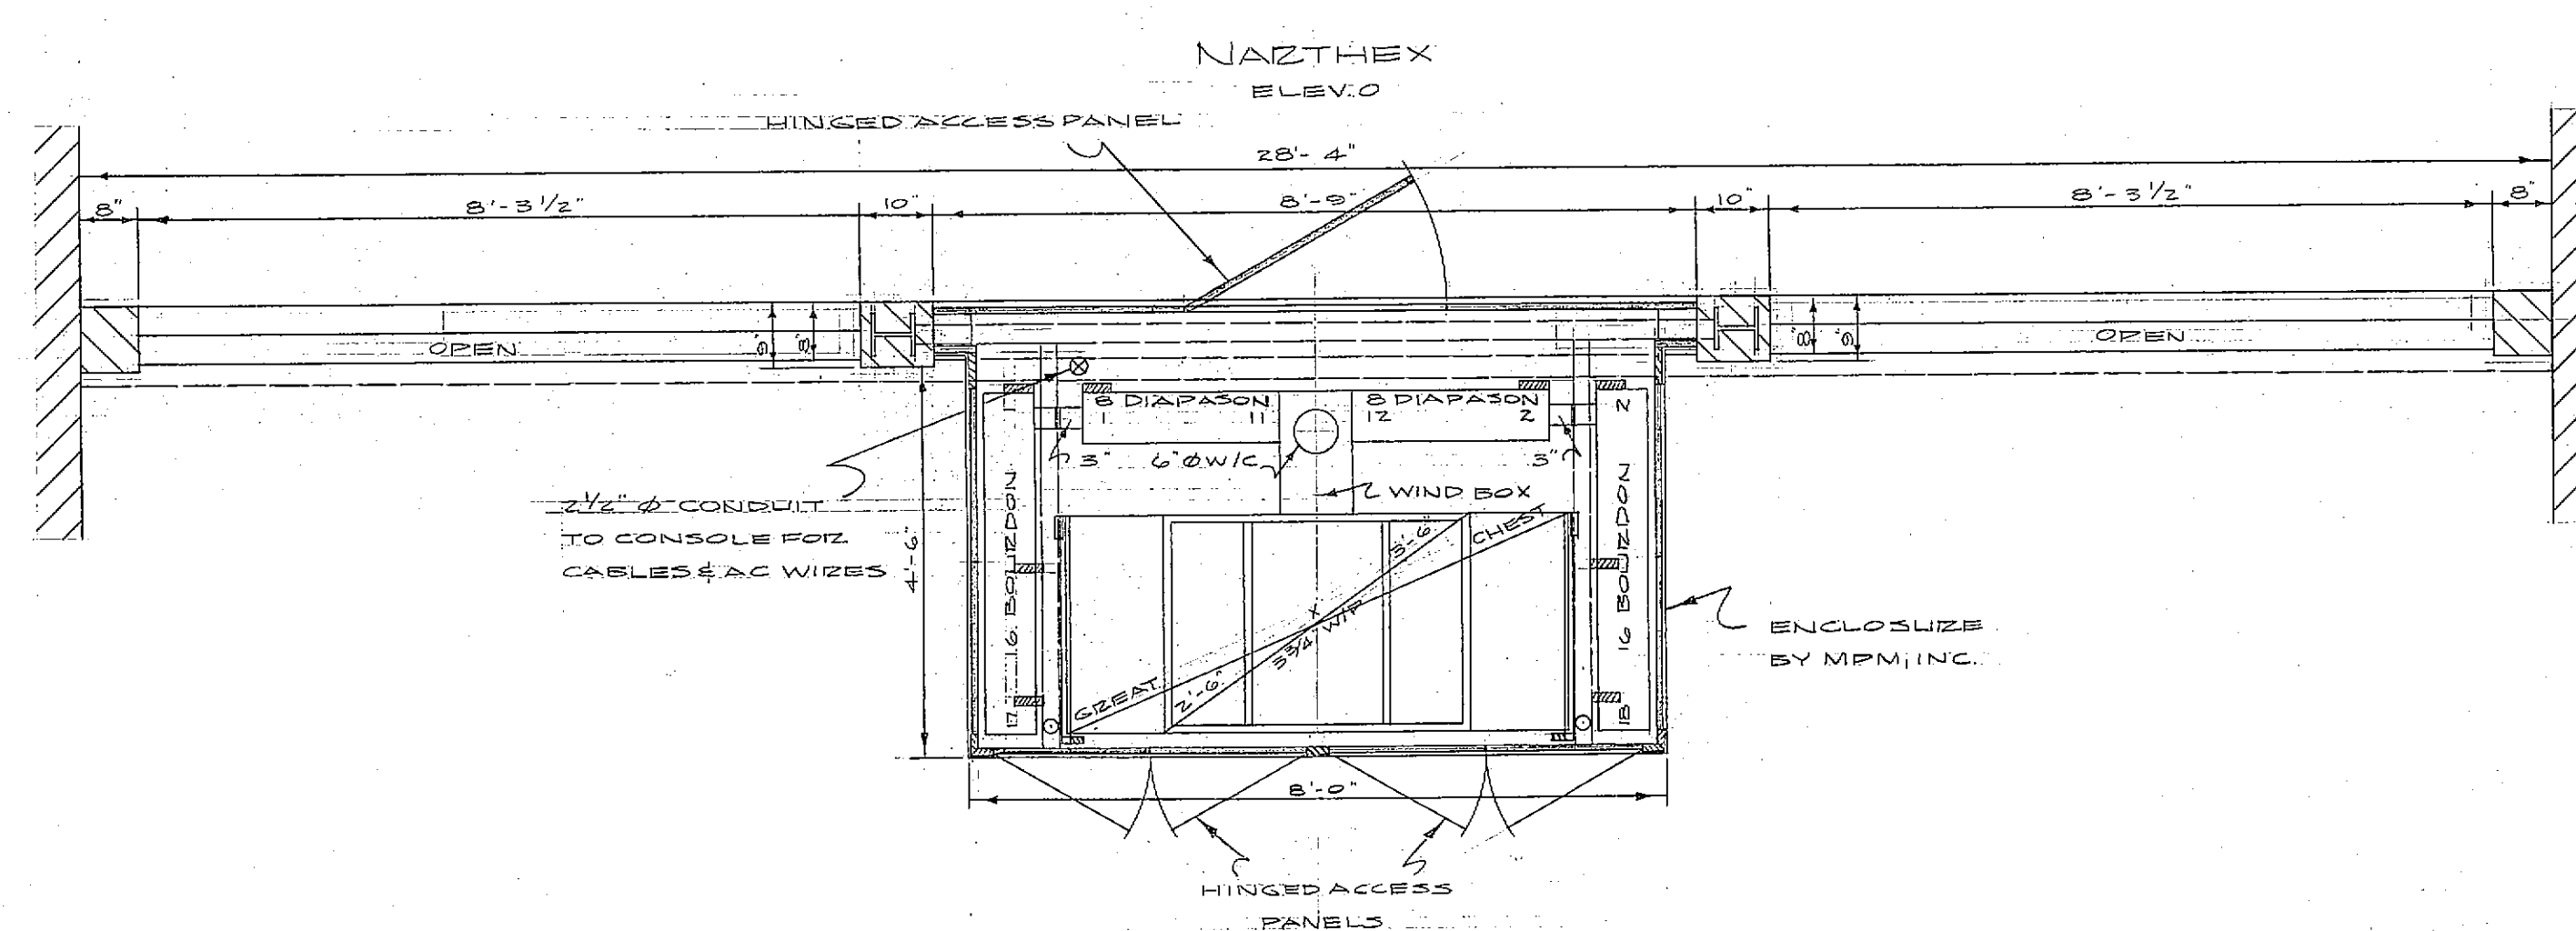

VIEW FROM NAZTHEX

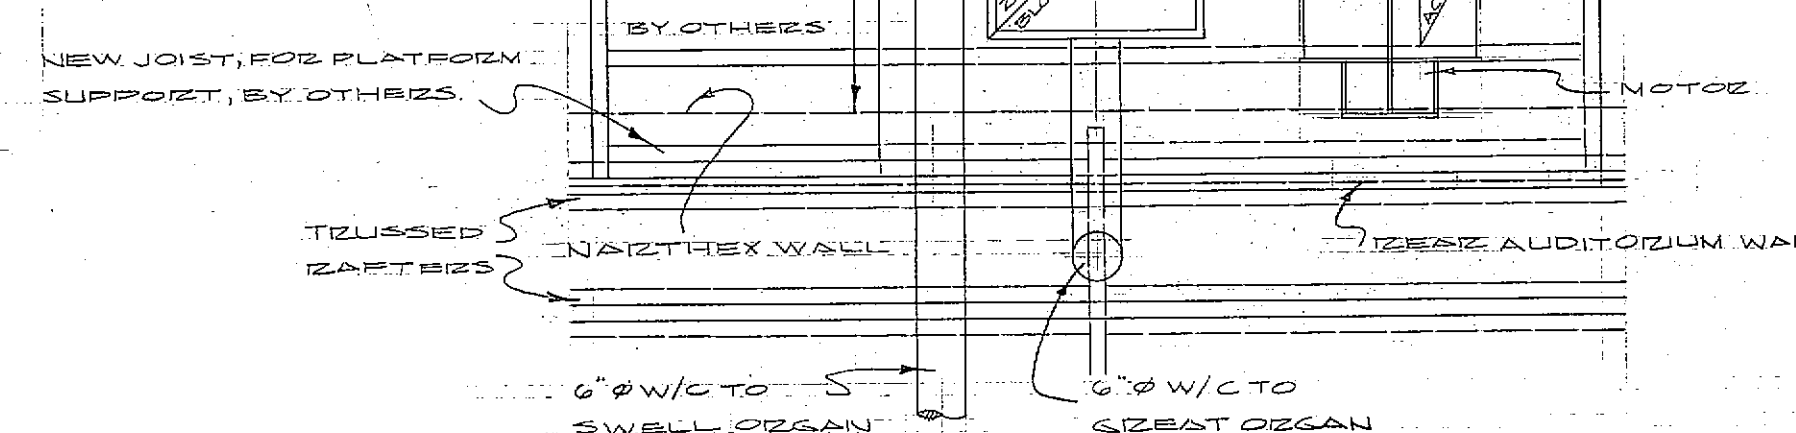


PLAN OF BLOWER

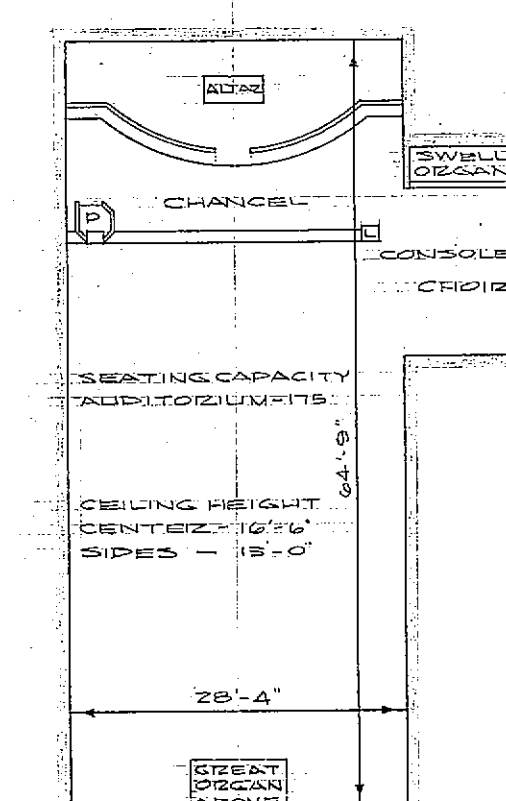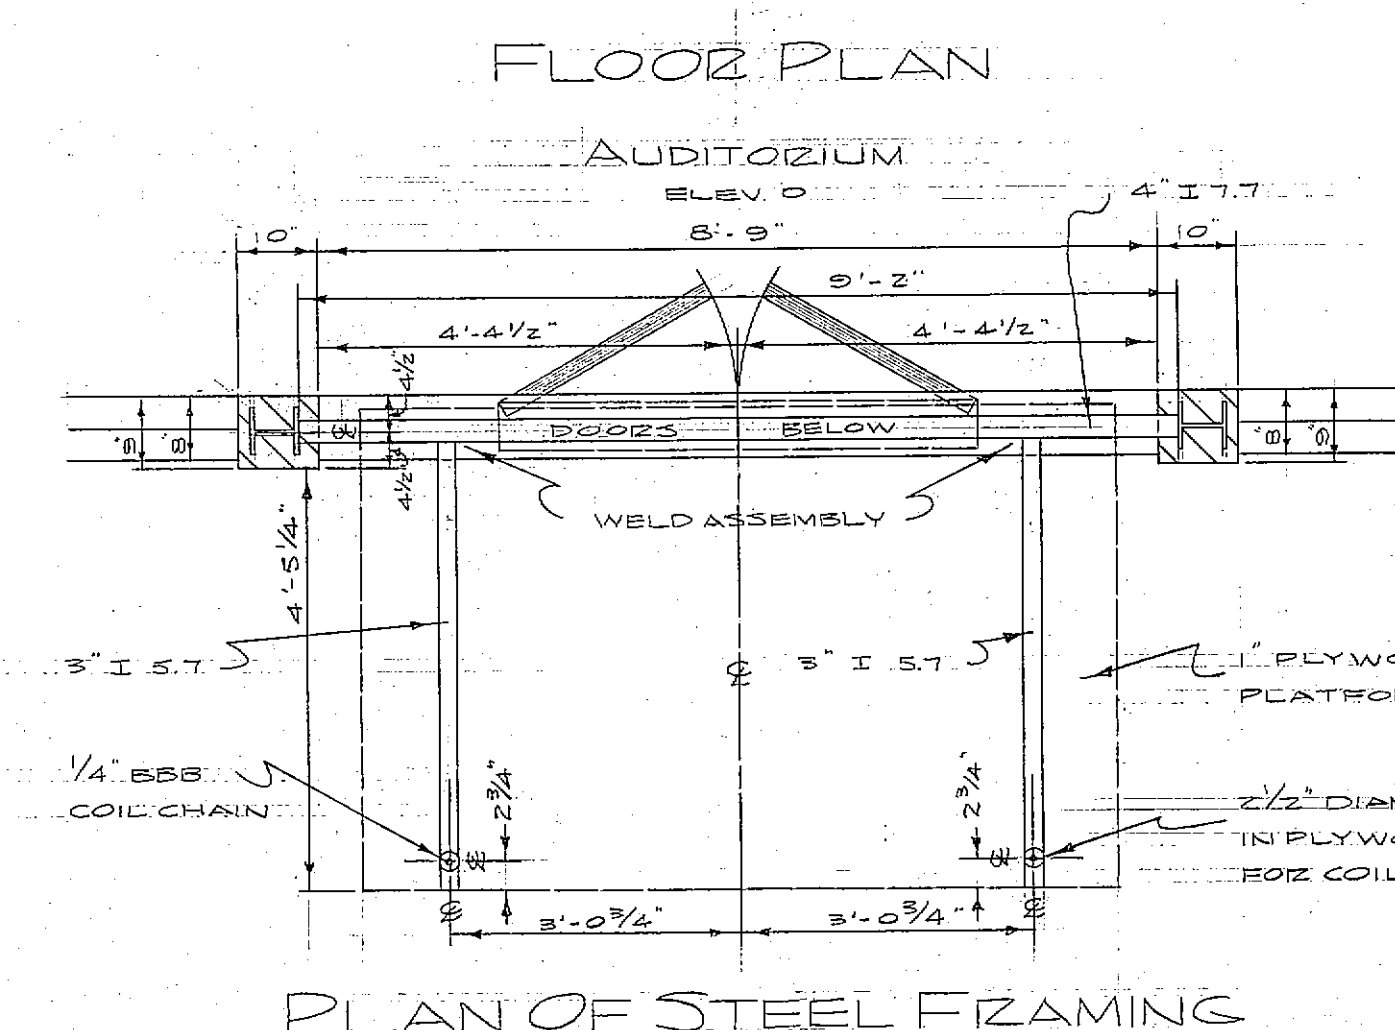


AUDITORIUM PLAN SCALE 1/8\"/>

EXPOSED GREAT ORGAN

DESIGN APPROVED BY MC CORBETTS DATE 12-8-01
DIMENSIONS OK BY V.I. ZUCK DATE 5-28-01
ST. MICHAEL'S OF THE VALLEY,
EPISCOPAL CHURCH,
LIGONIER, PA.
SCALE 1/8\"/>

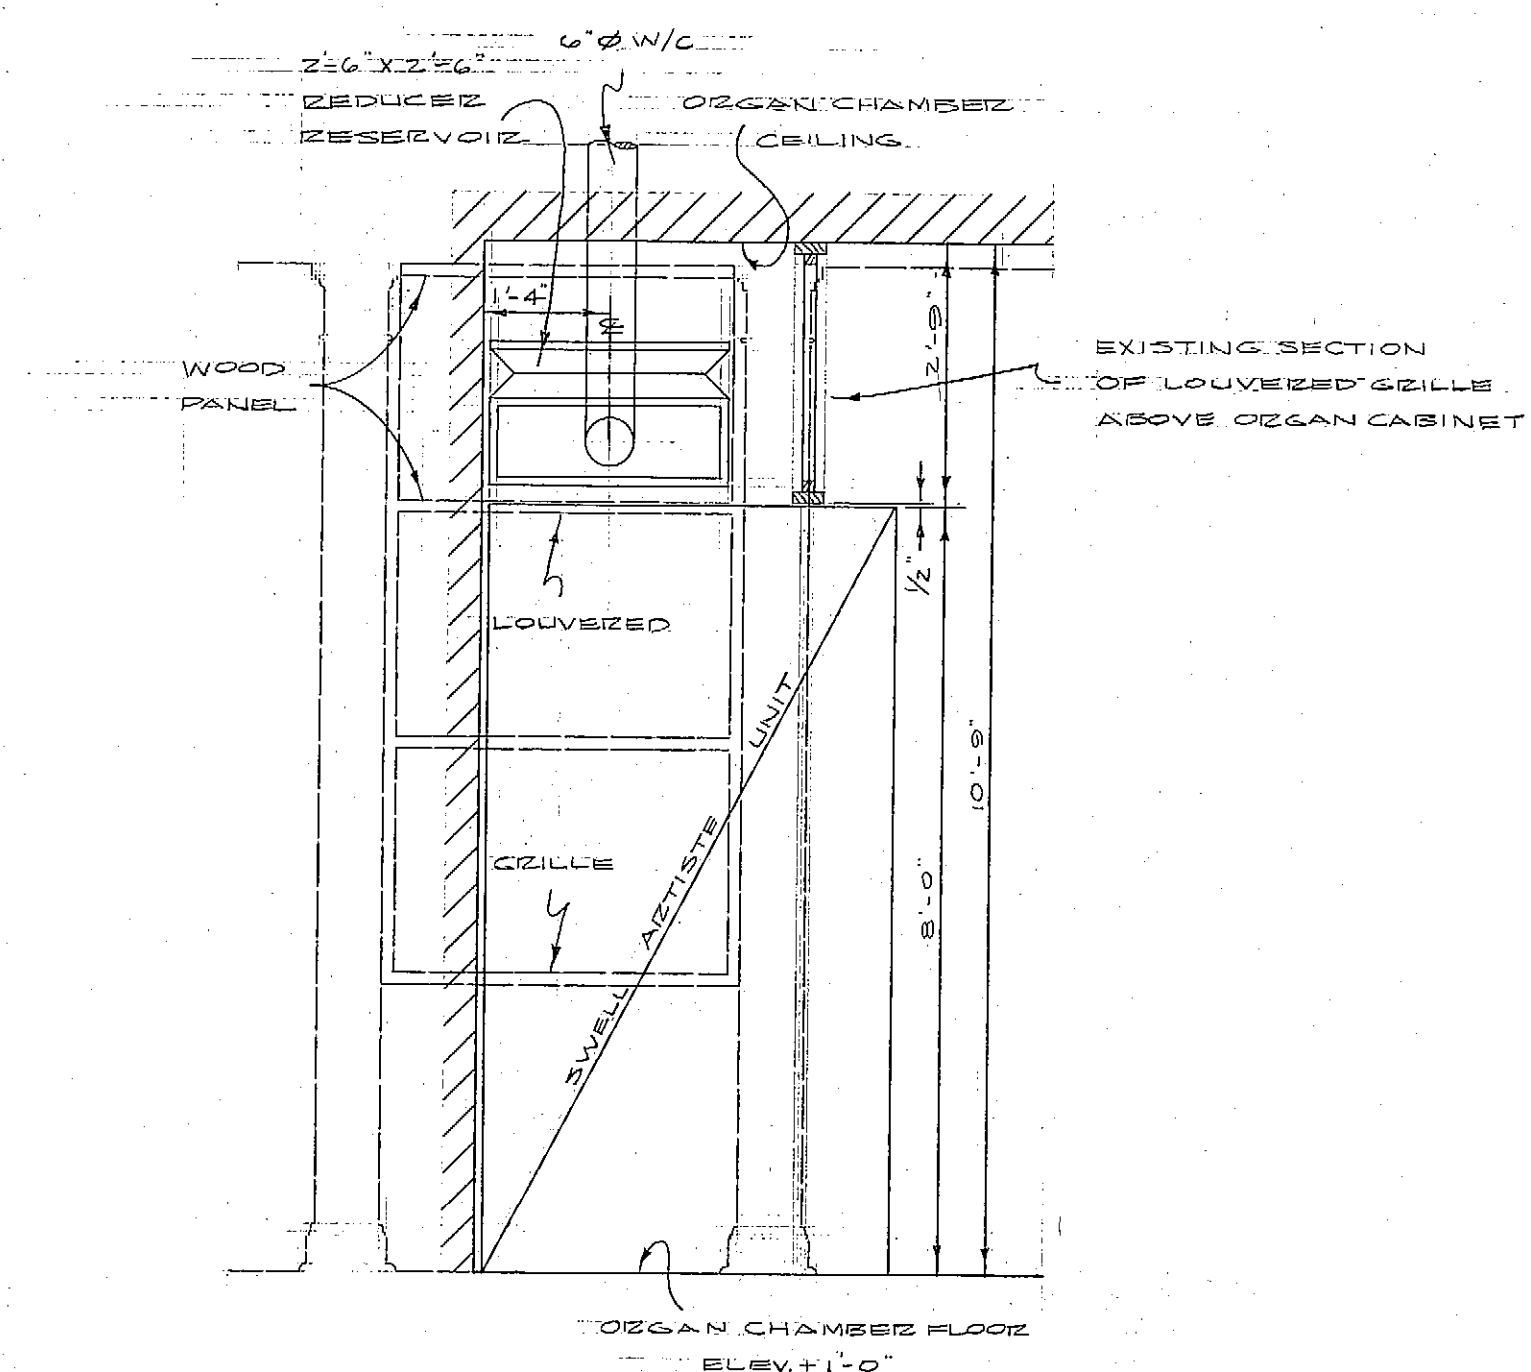


SECTION-BB

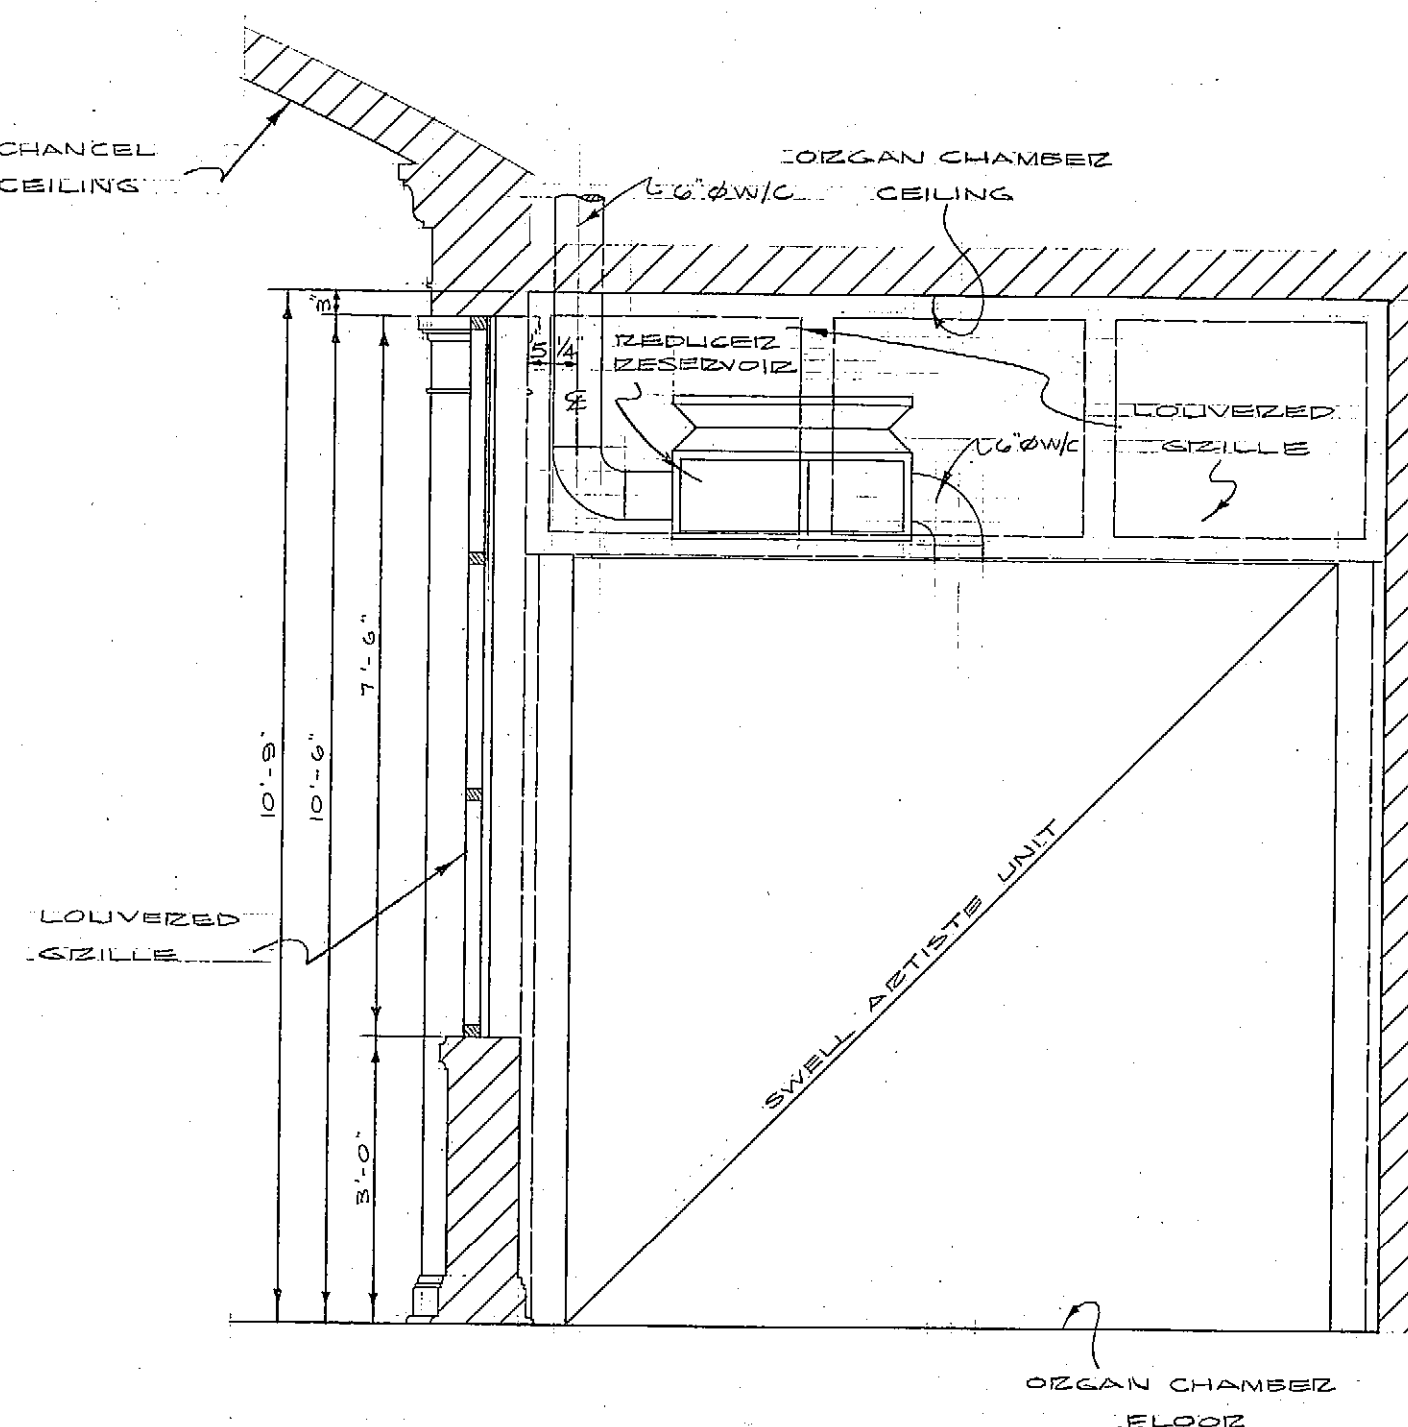


SECTION-AA

SEE DRAWING NO. 101 FOR EXPOSED GREAT ORGAN & ADDITIONAL NOTES.

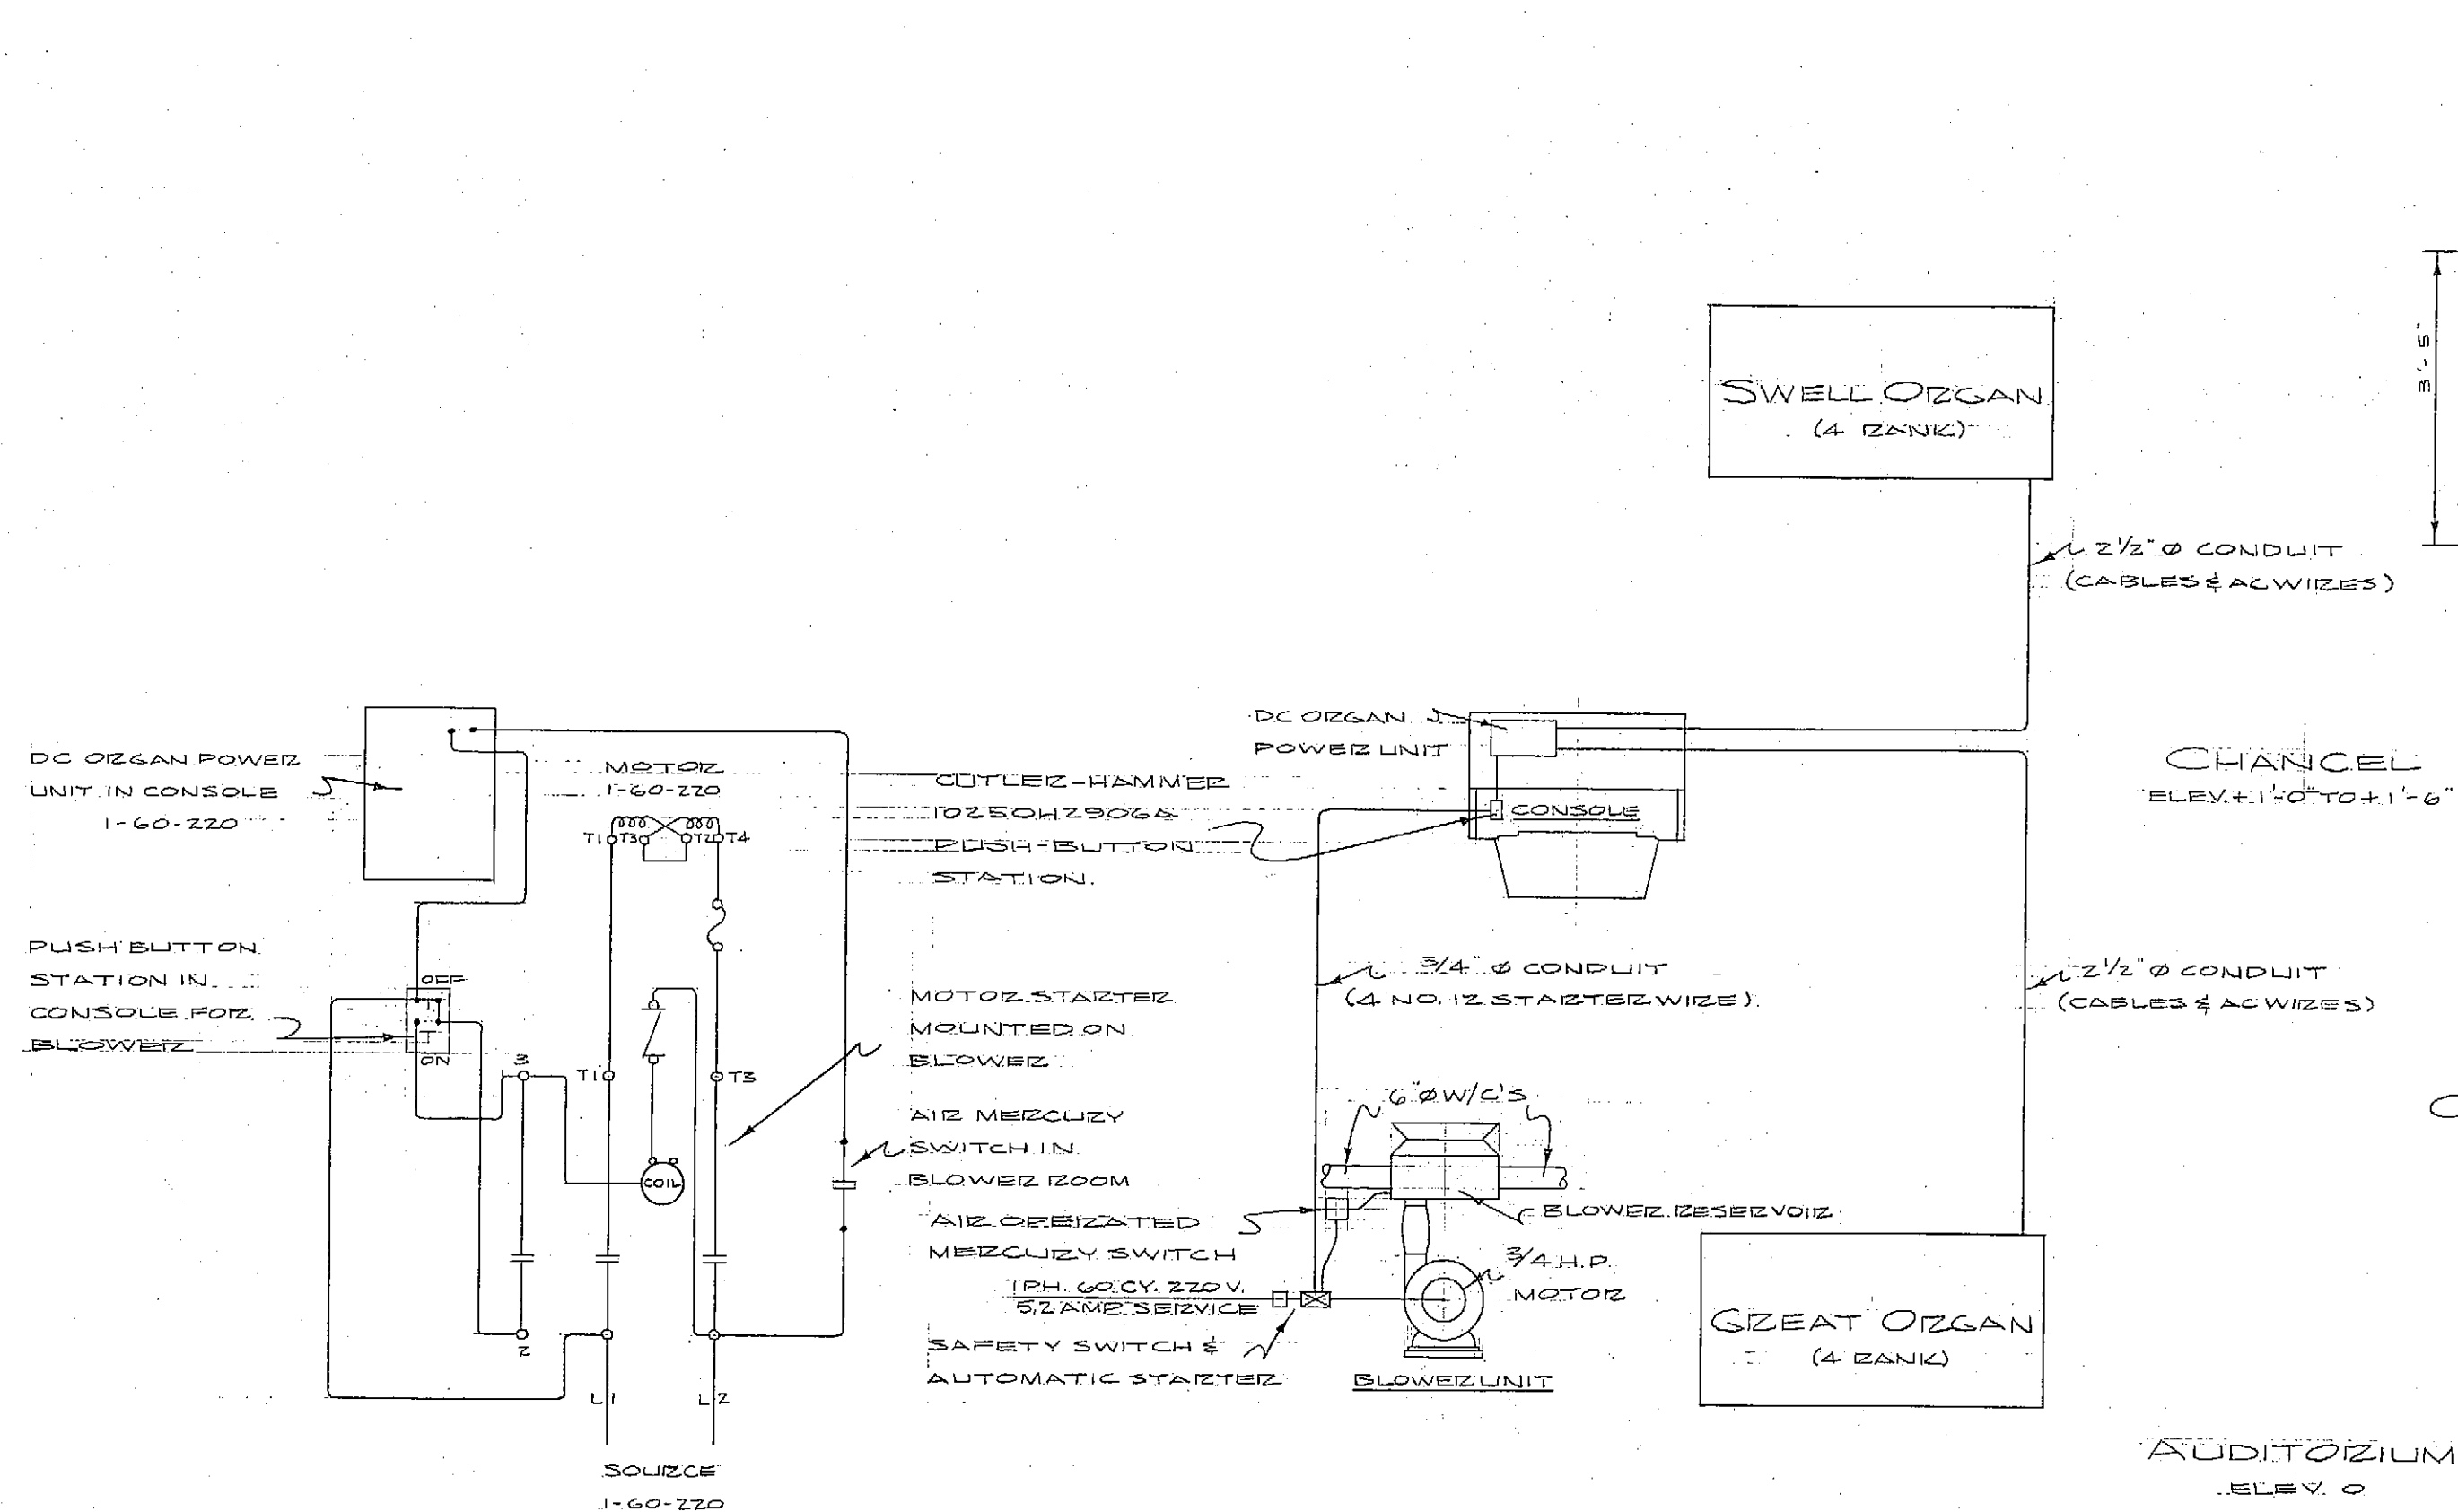

WIRING SCHEMATIC FOR
DC ORGAN POWER UNIT

WIRING & WIND
CONDUCTOR SCHEMATIC

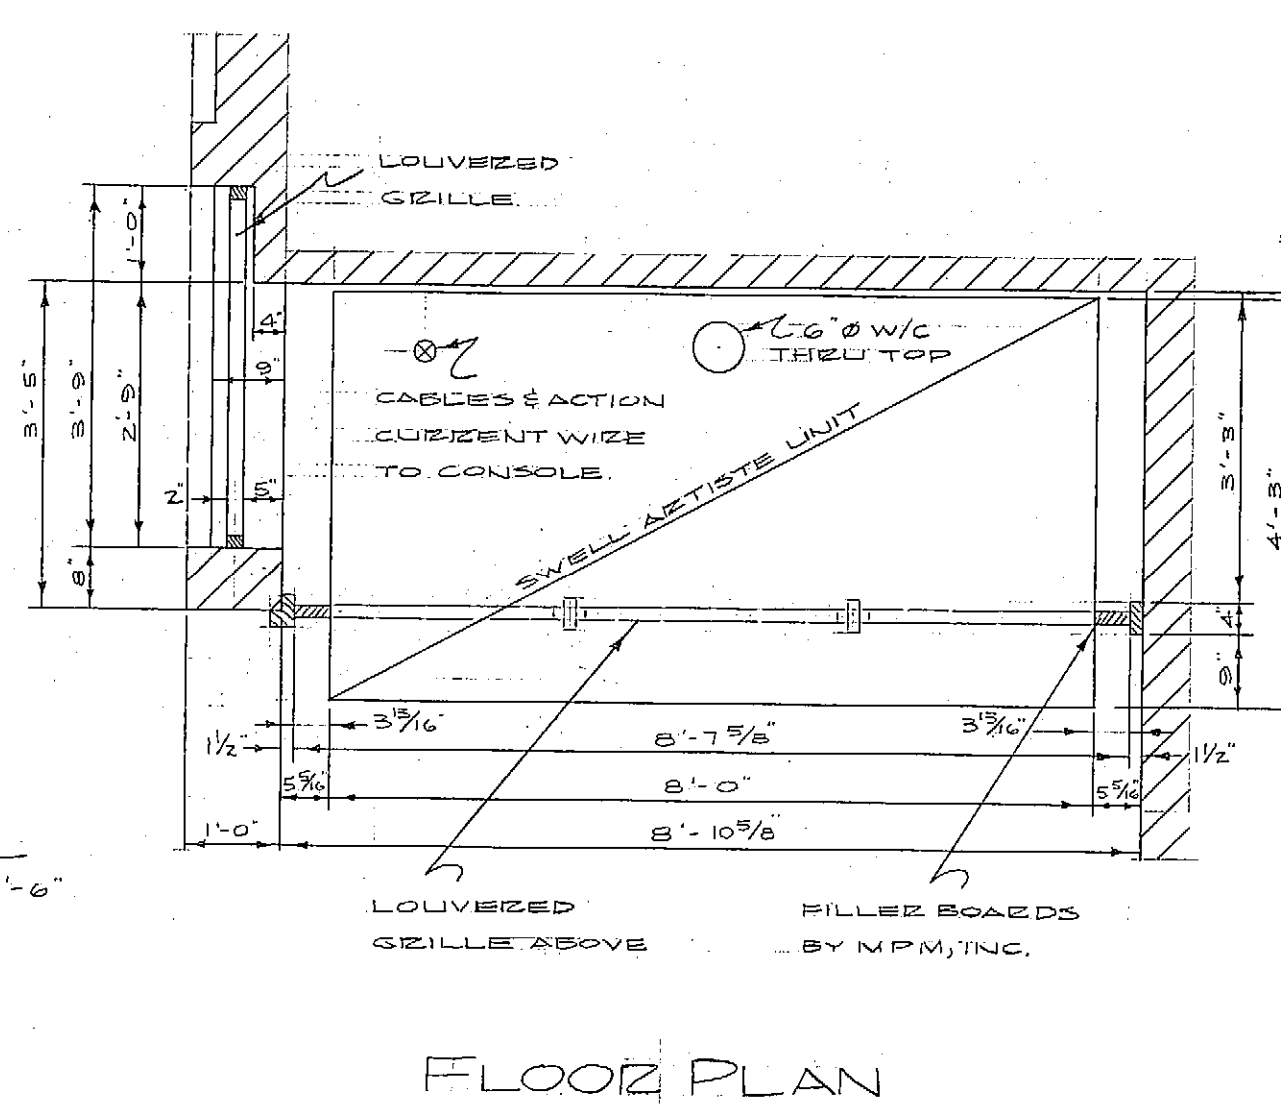

FLOOR PLAN

CONSOLE
ELEV. +1'-0"


CEILING
ELEV. +1'-0"

SWELL ORGAN


DIMENSIONS OK BY V.I. ZUCKER DATE 6-28-61

ST. MICHAEL'S OF THE VALLEY,
EPISCOPAL CHURCH,
LIGONIER, PA.

SCALE - 1/2" = 1'-0"
REV. CH. 12/20 DATE 12/20/61
724-61 J.L.G. N. S.W.D. 5316
M.P. MOULDER, INC.
HAGERSTOWN, MD.
9596
DRAWING NO. 102

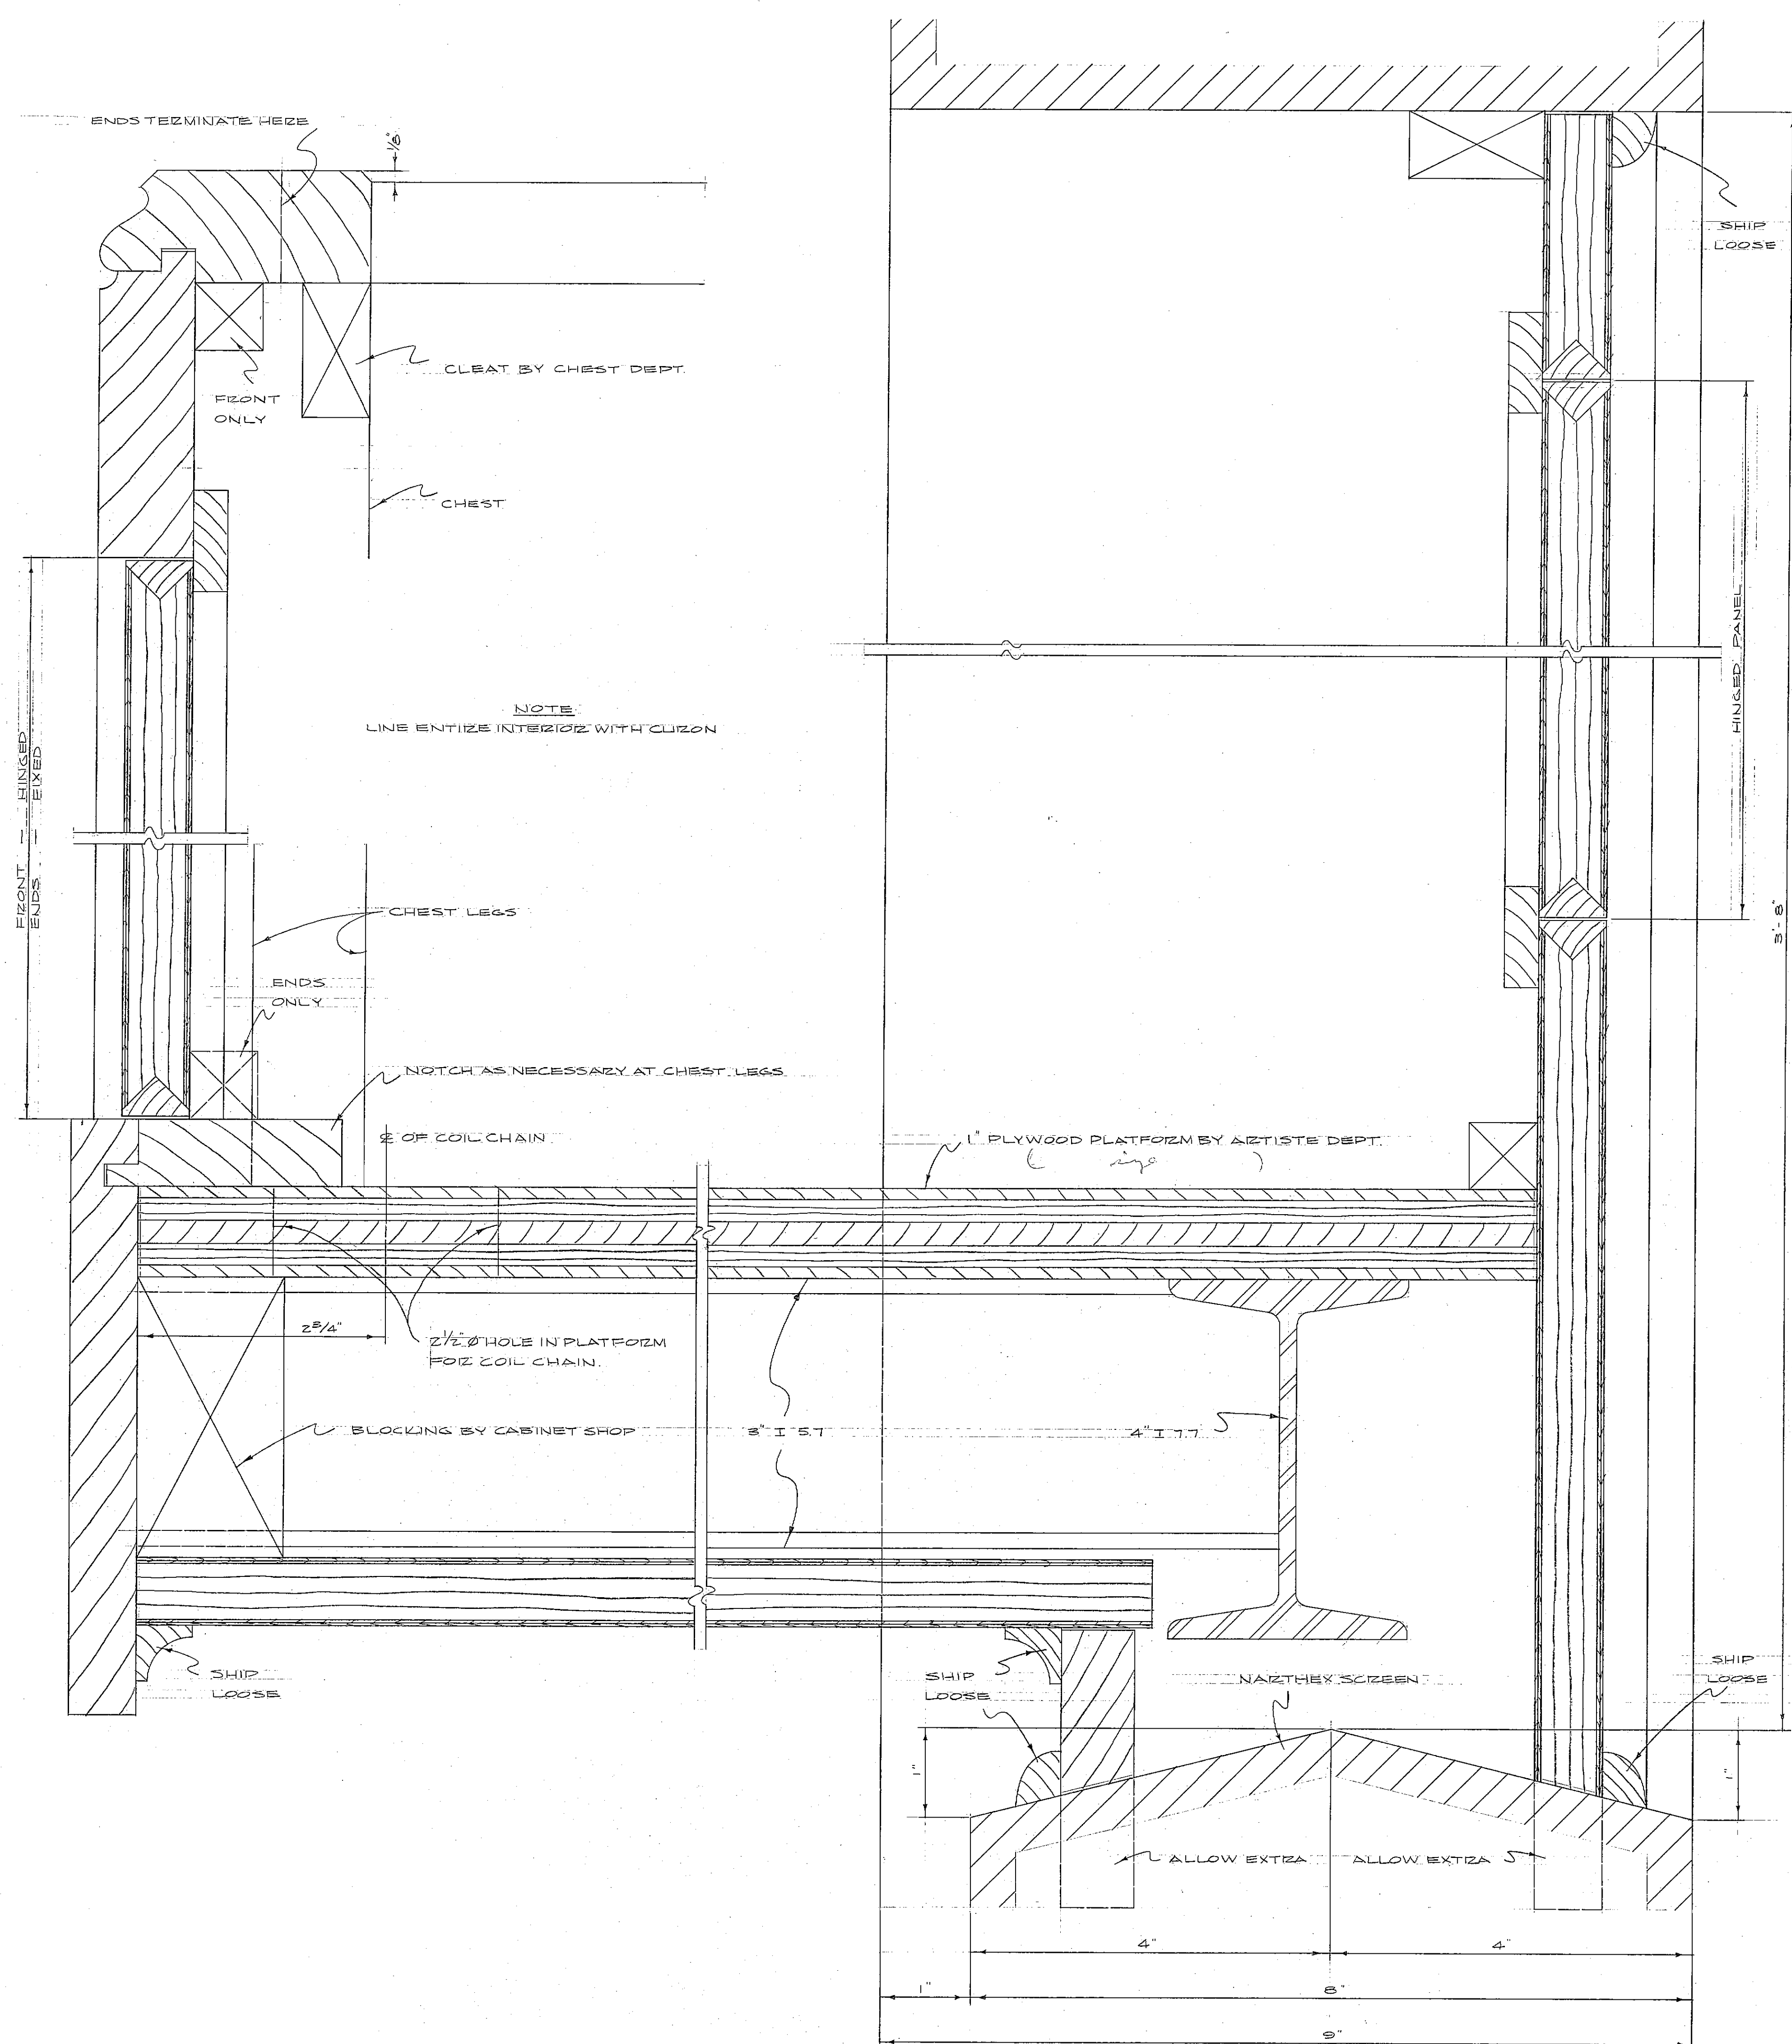

SECTION FRONT & ENDS

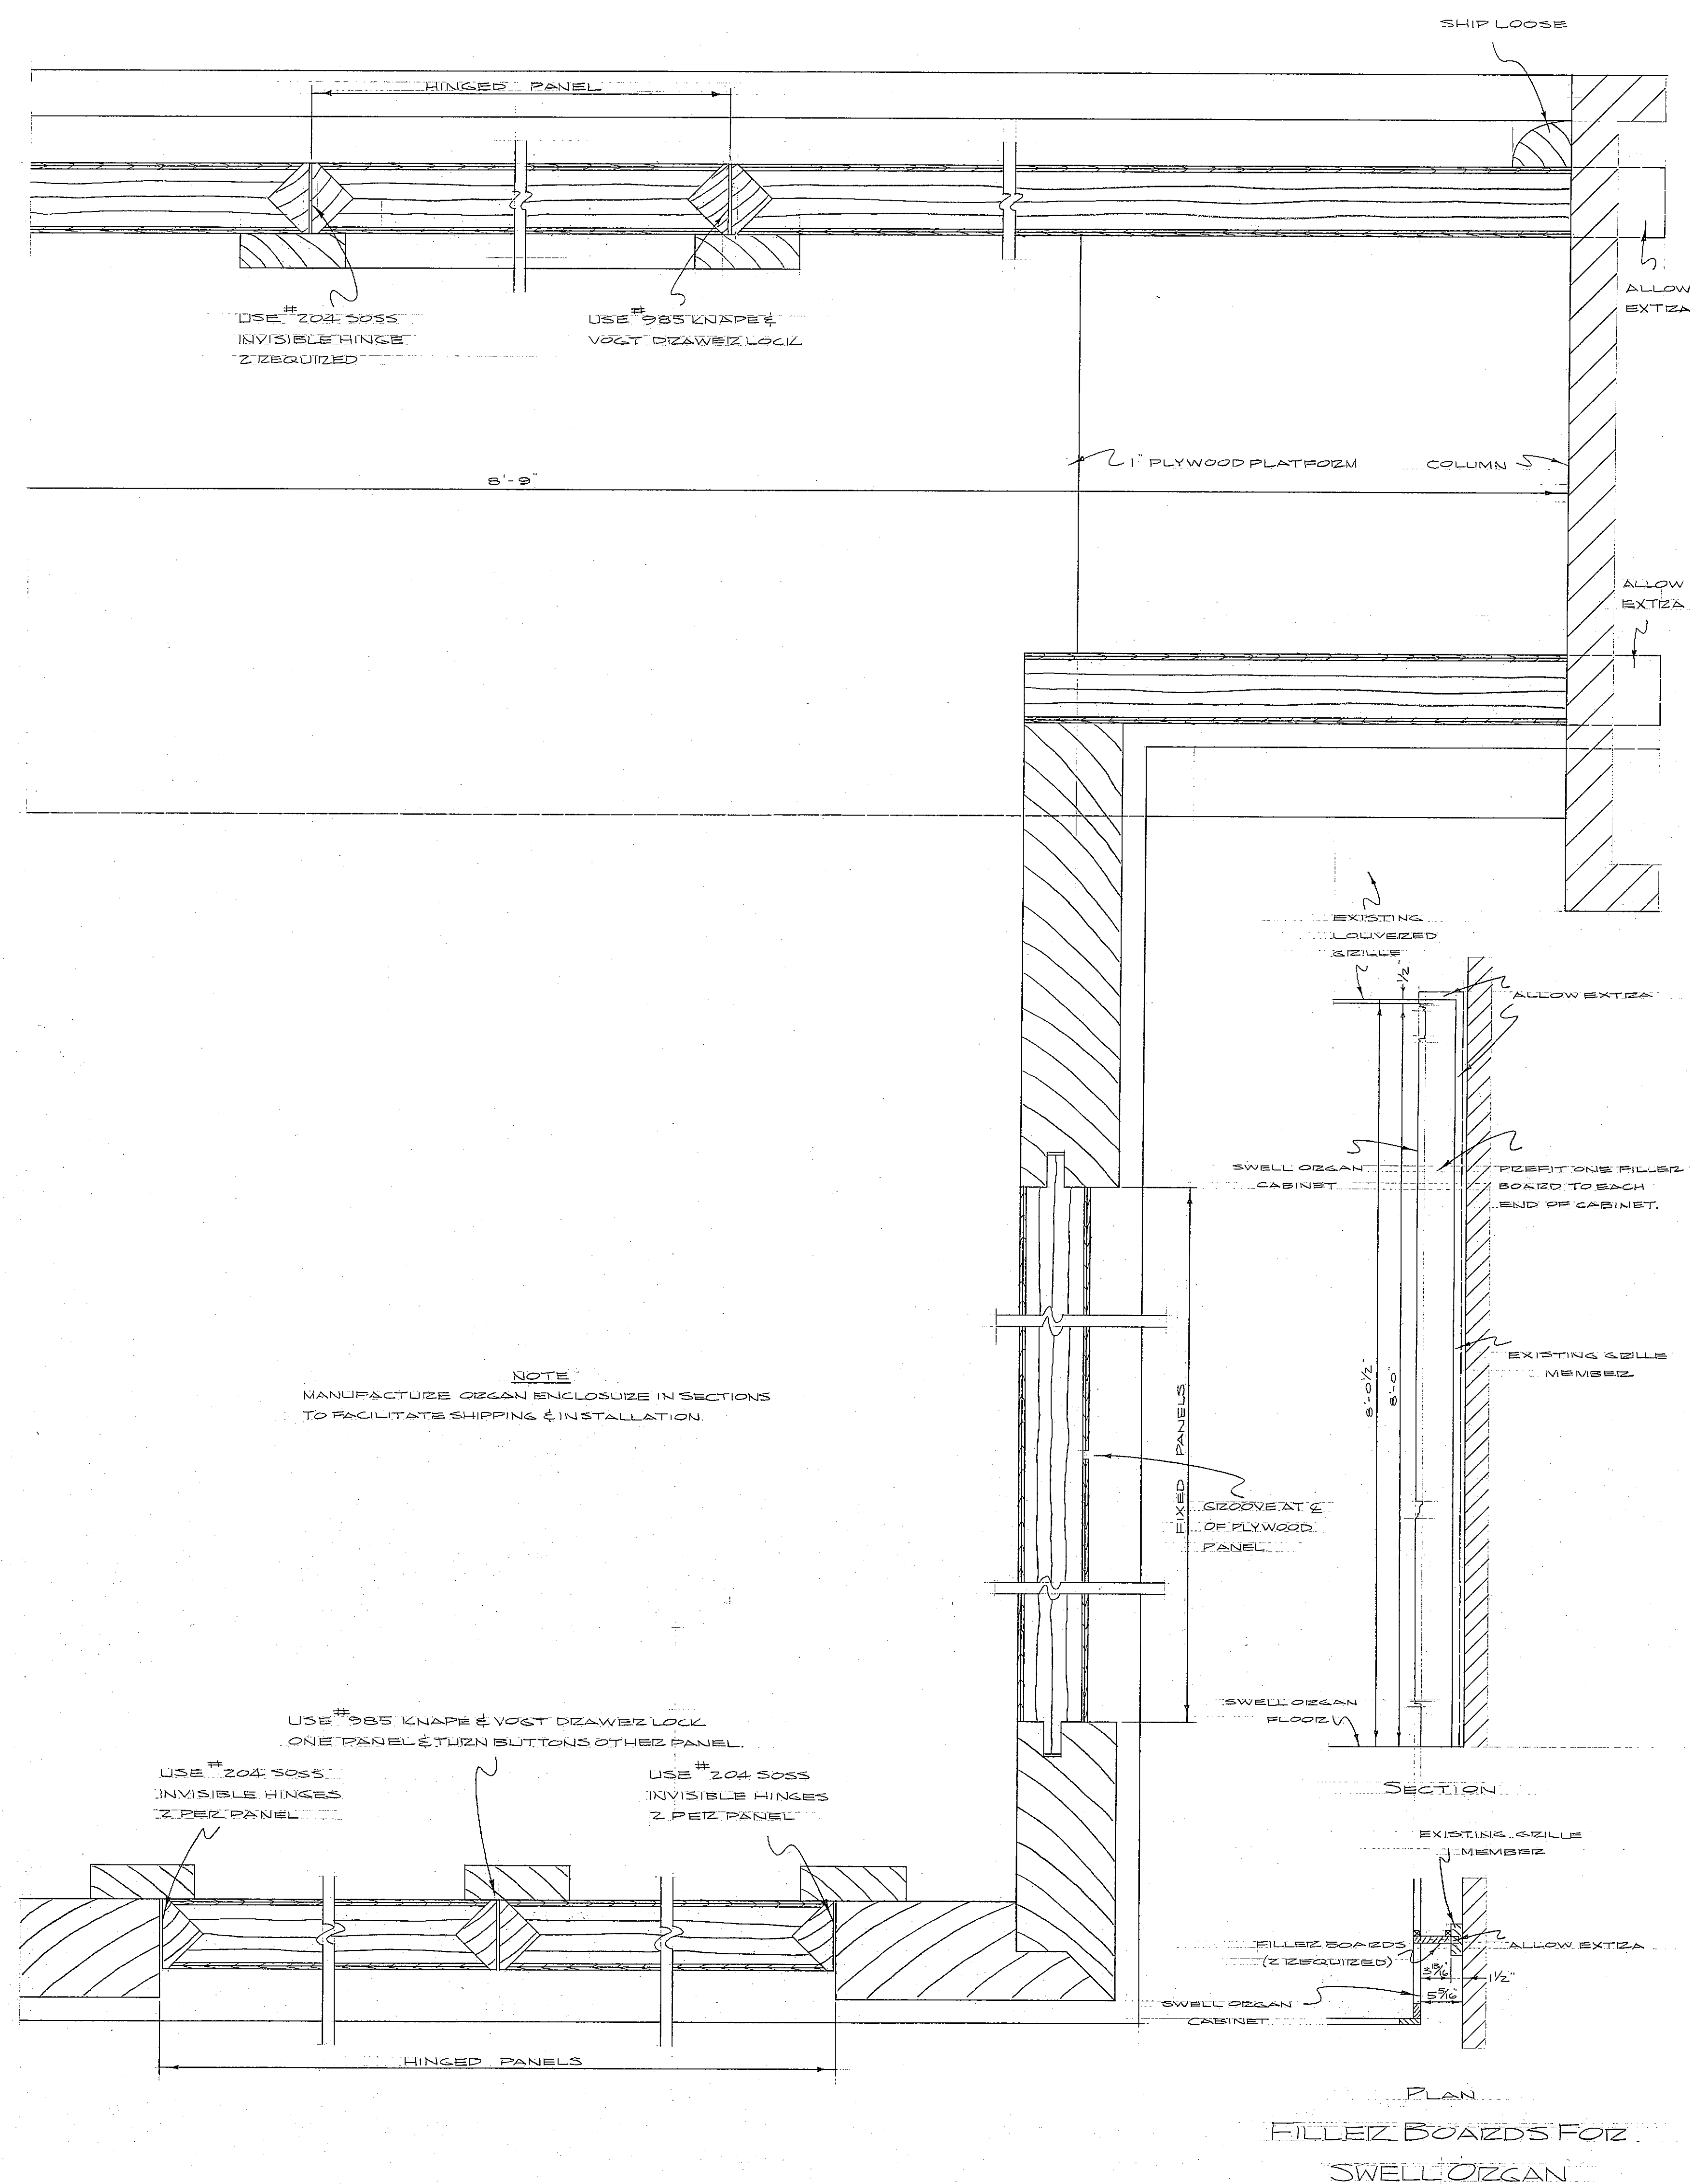

PLAN

ST. MICHAEL'S OF THE VALLEY,
EPISCOPAL CHURCH,
LIGONIER, PA.

SCALE - FULL SIZE				M. P. MOLLER, INC.		9596
REV.	CH'KD	DRAWN	DATE	HAGERSTOWN, MD		
		K. W. C. W.	7-11-61			DRAWING NO. 10