




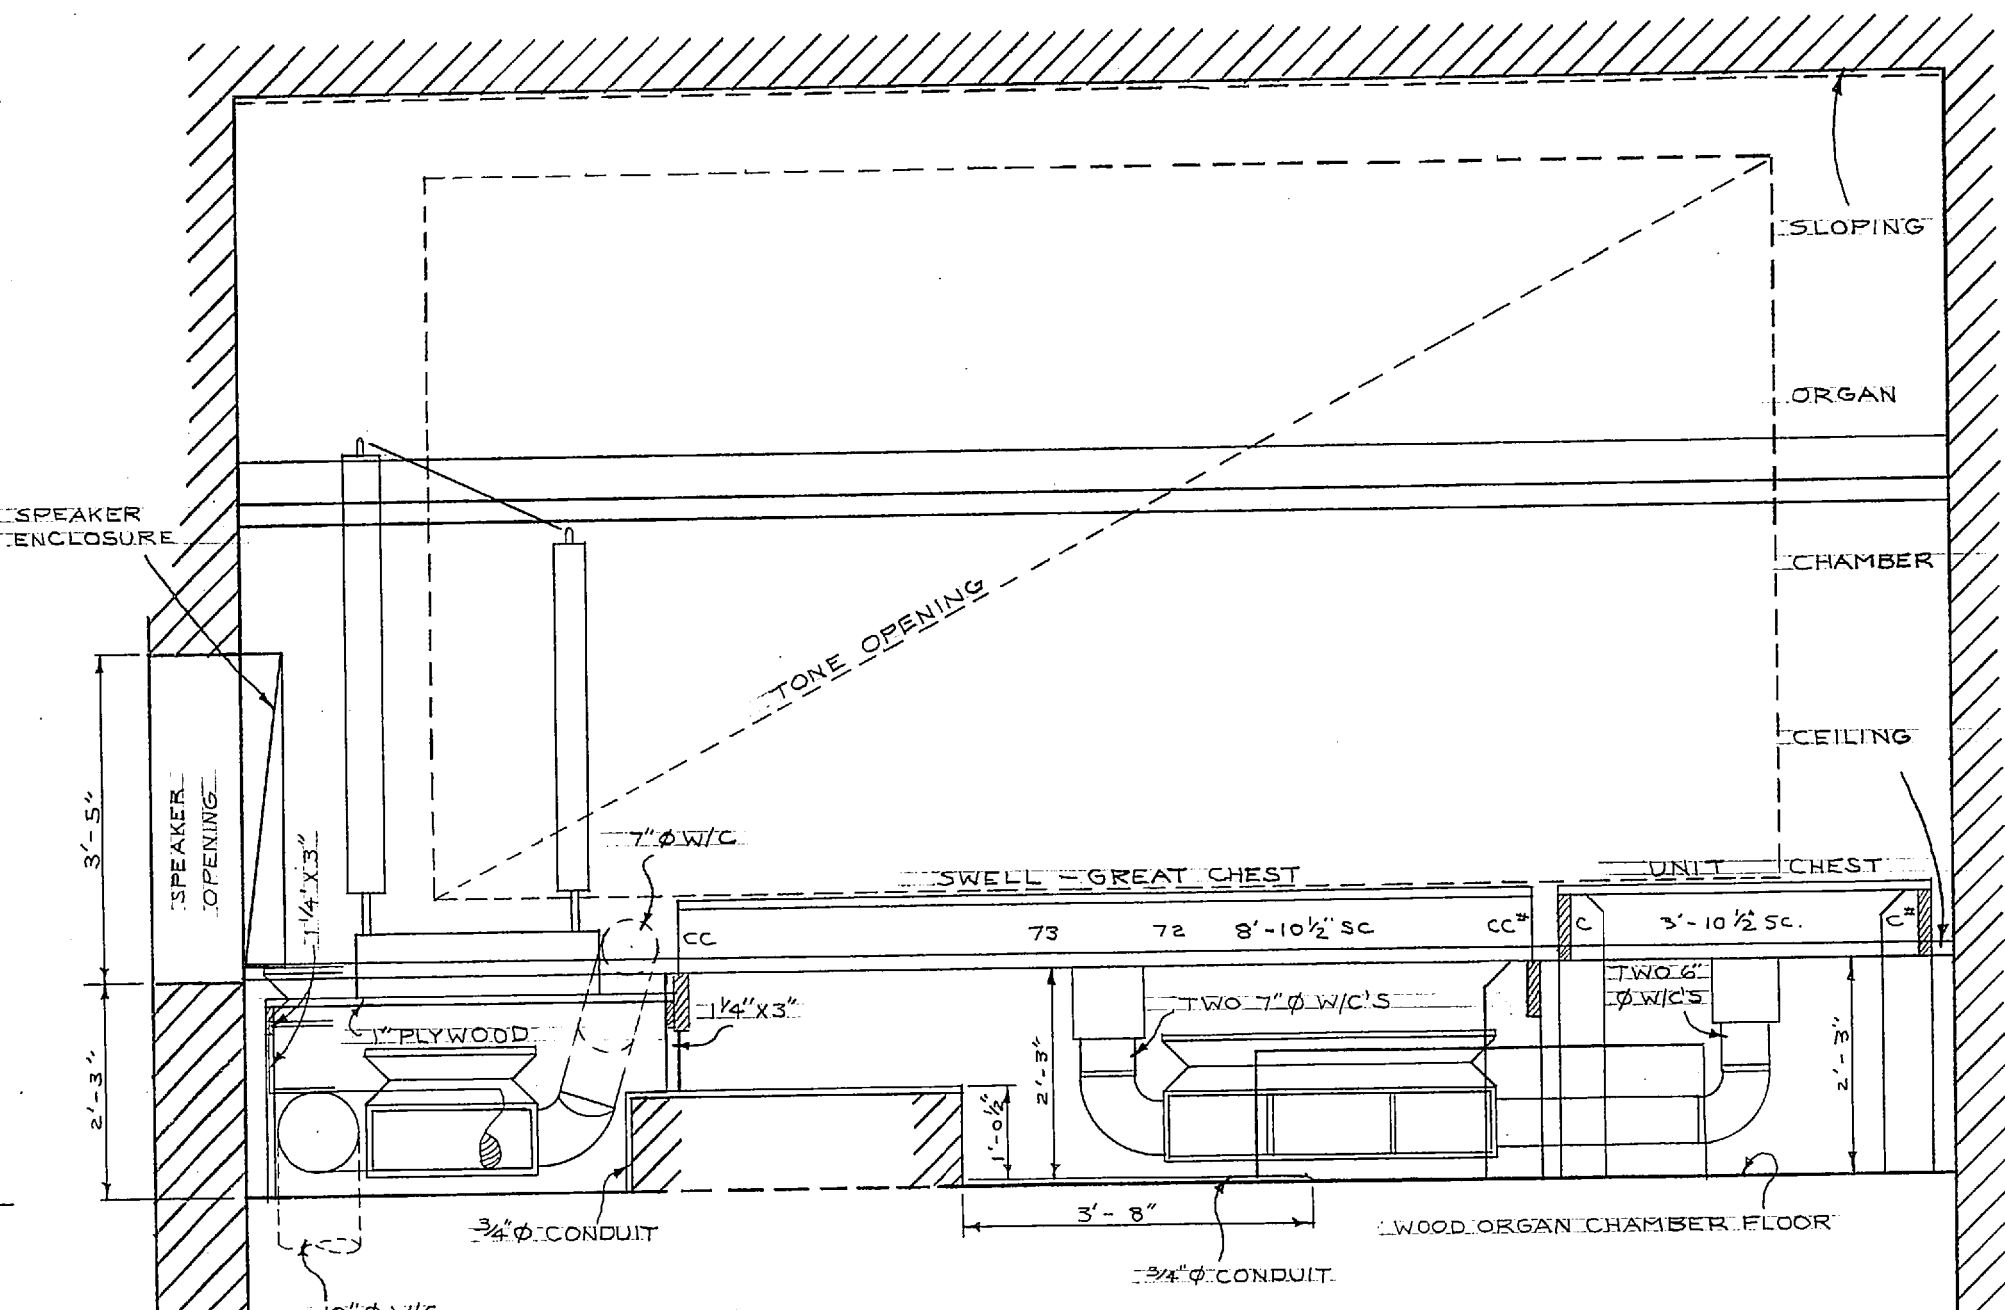

SECTION BB

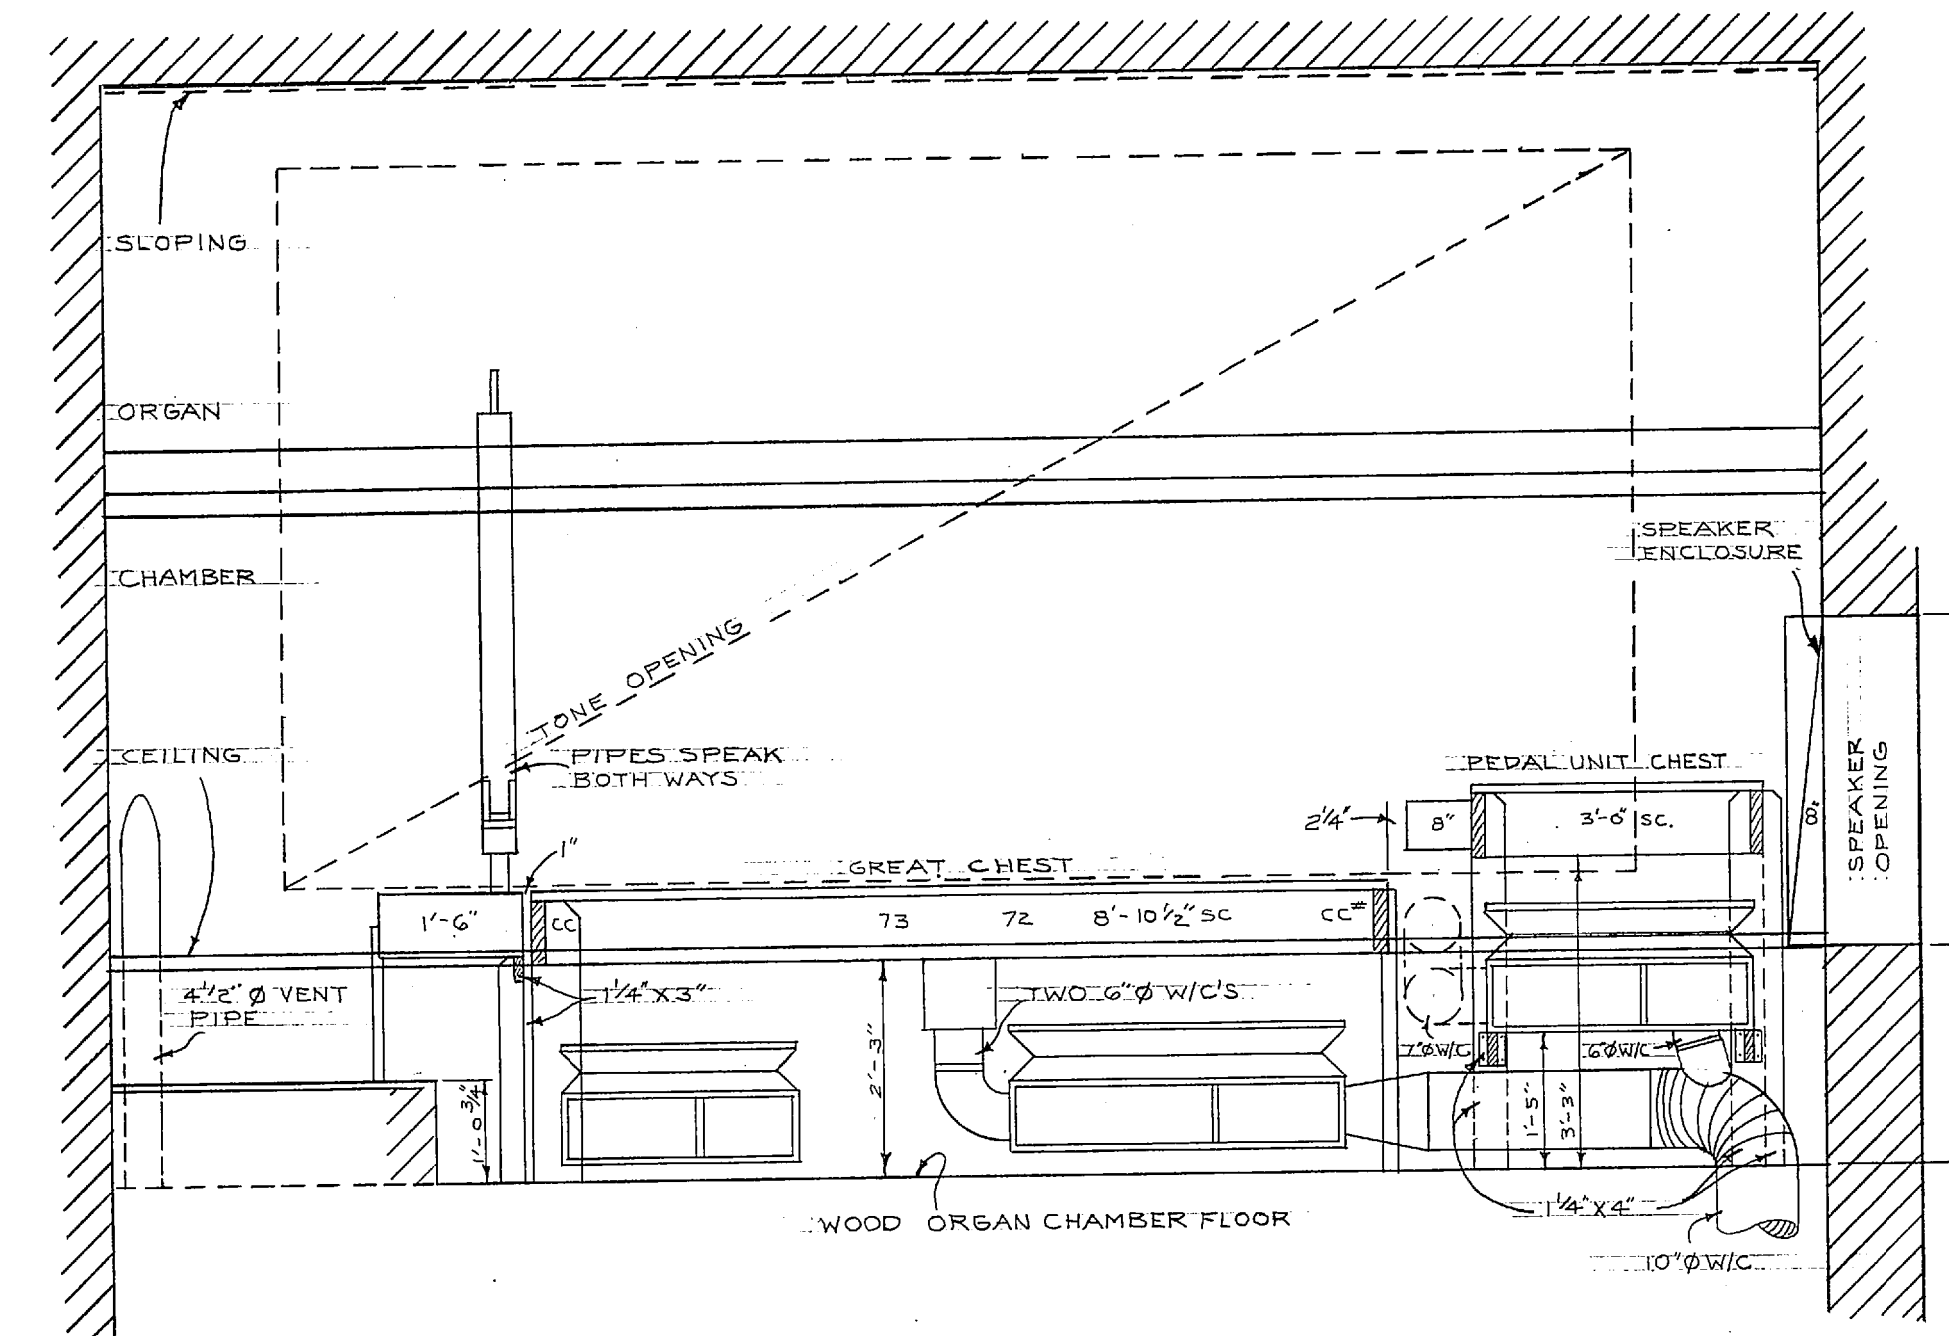


SECTION CC

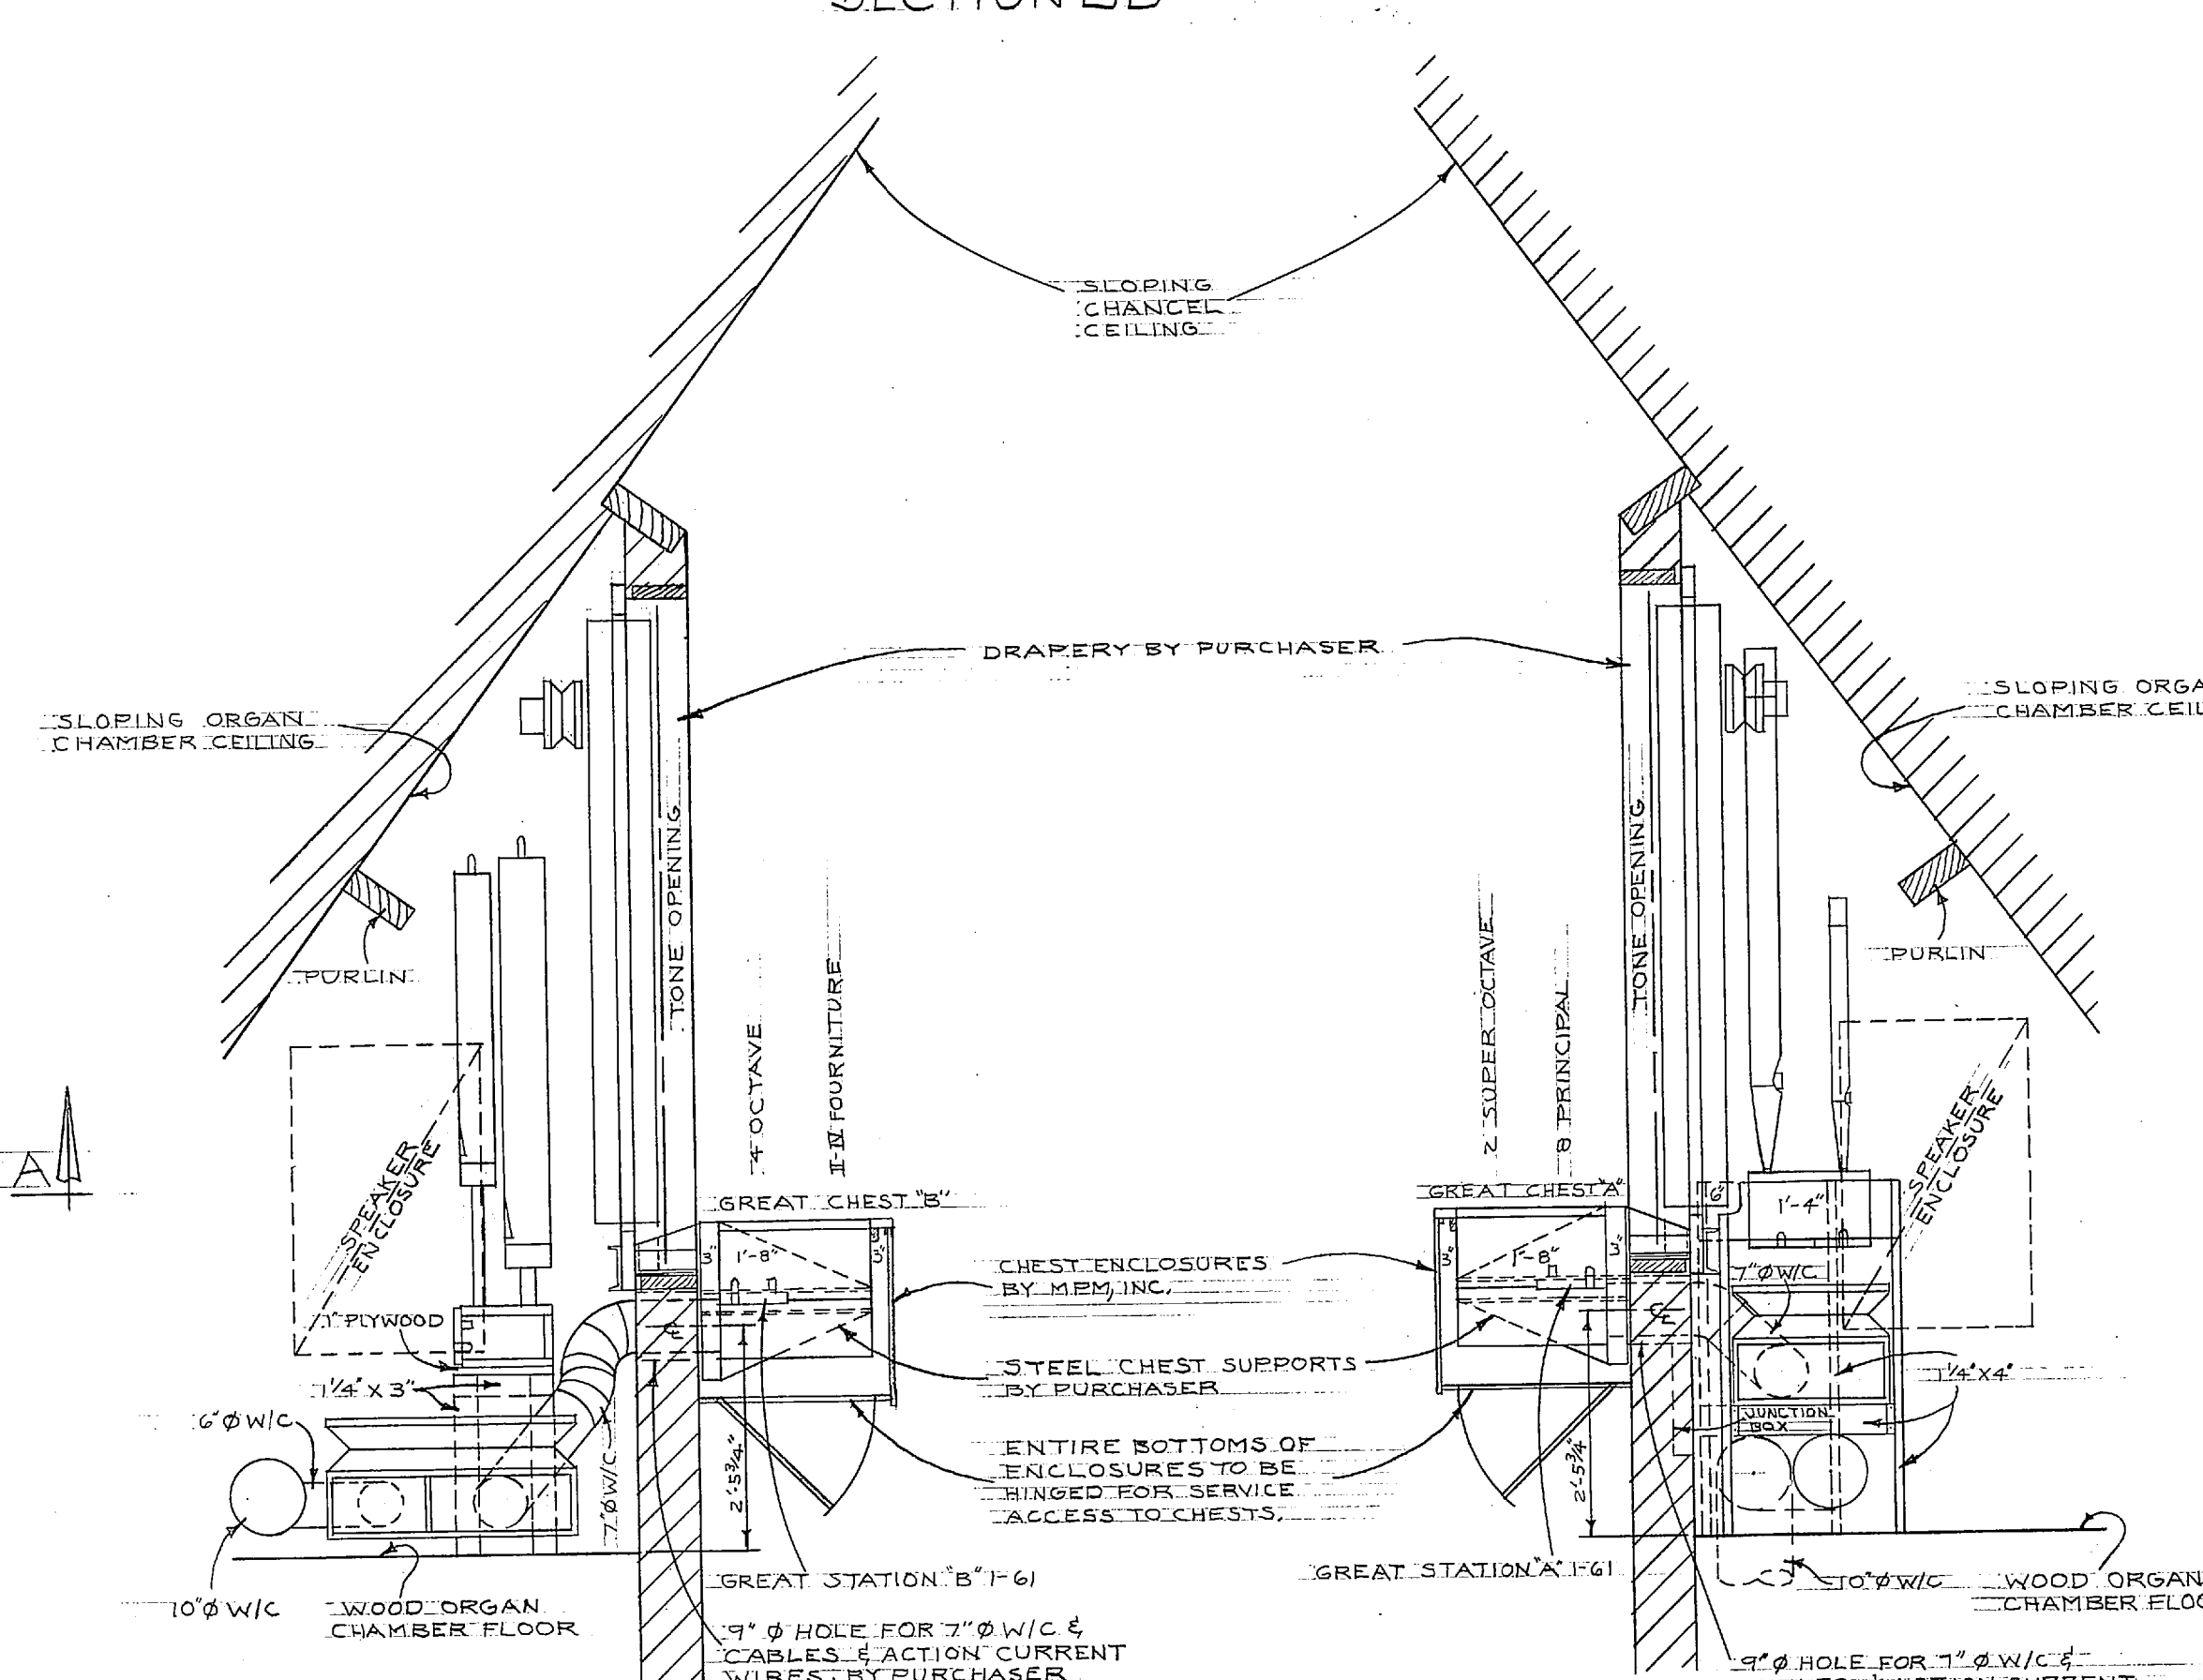


## SECTION D

SECTION E

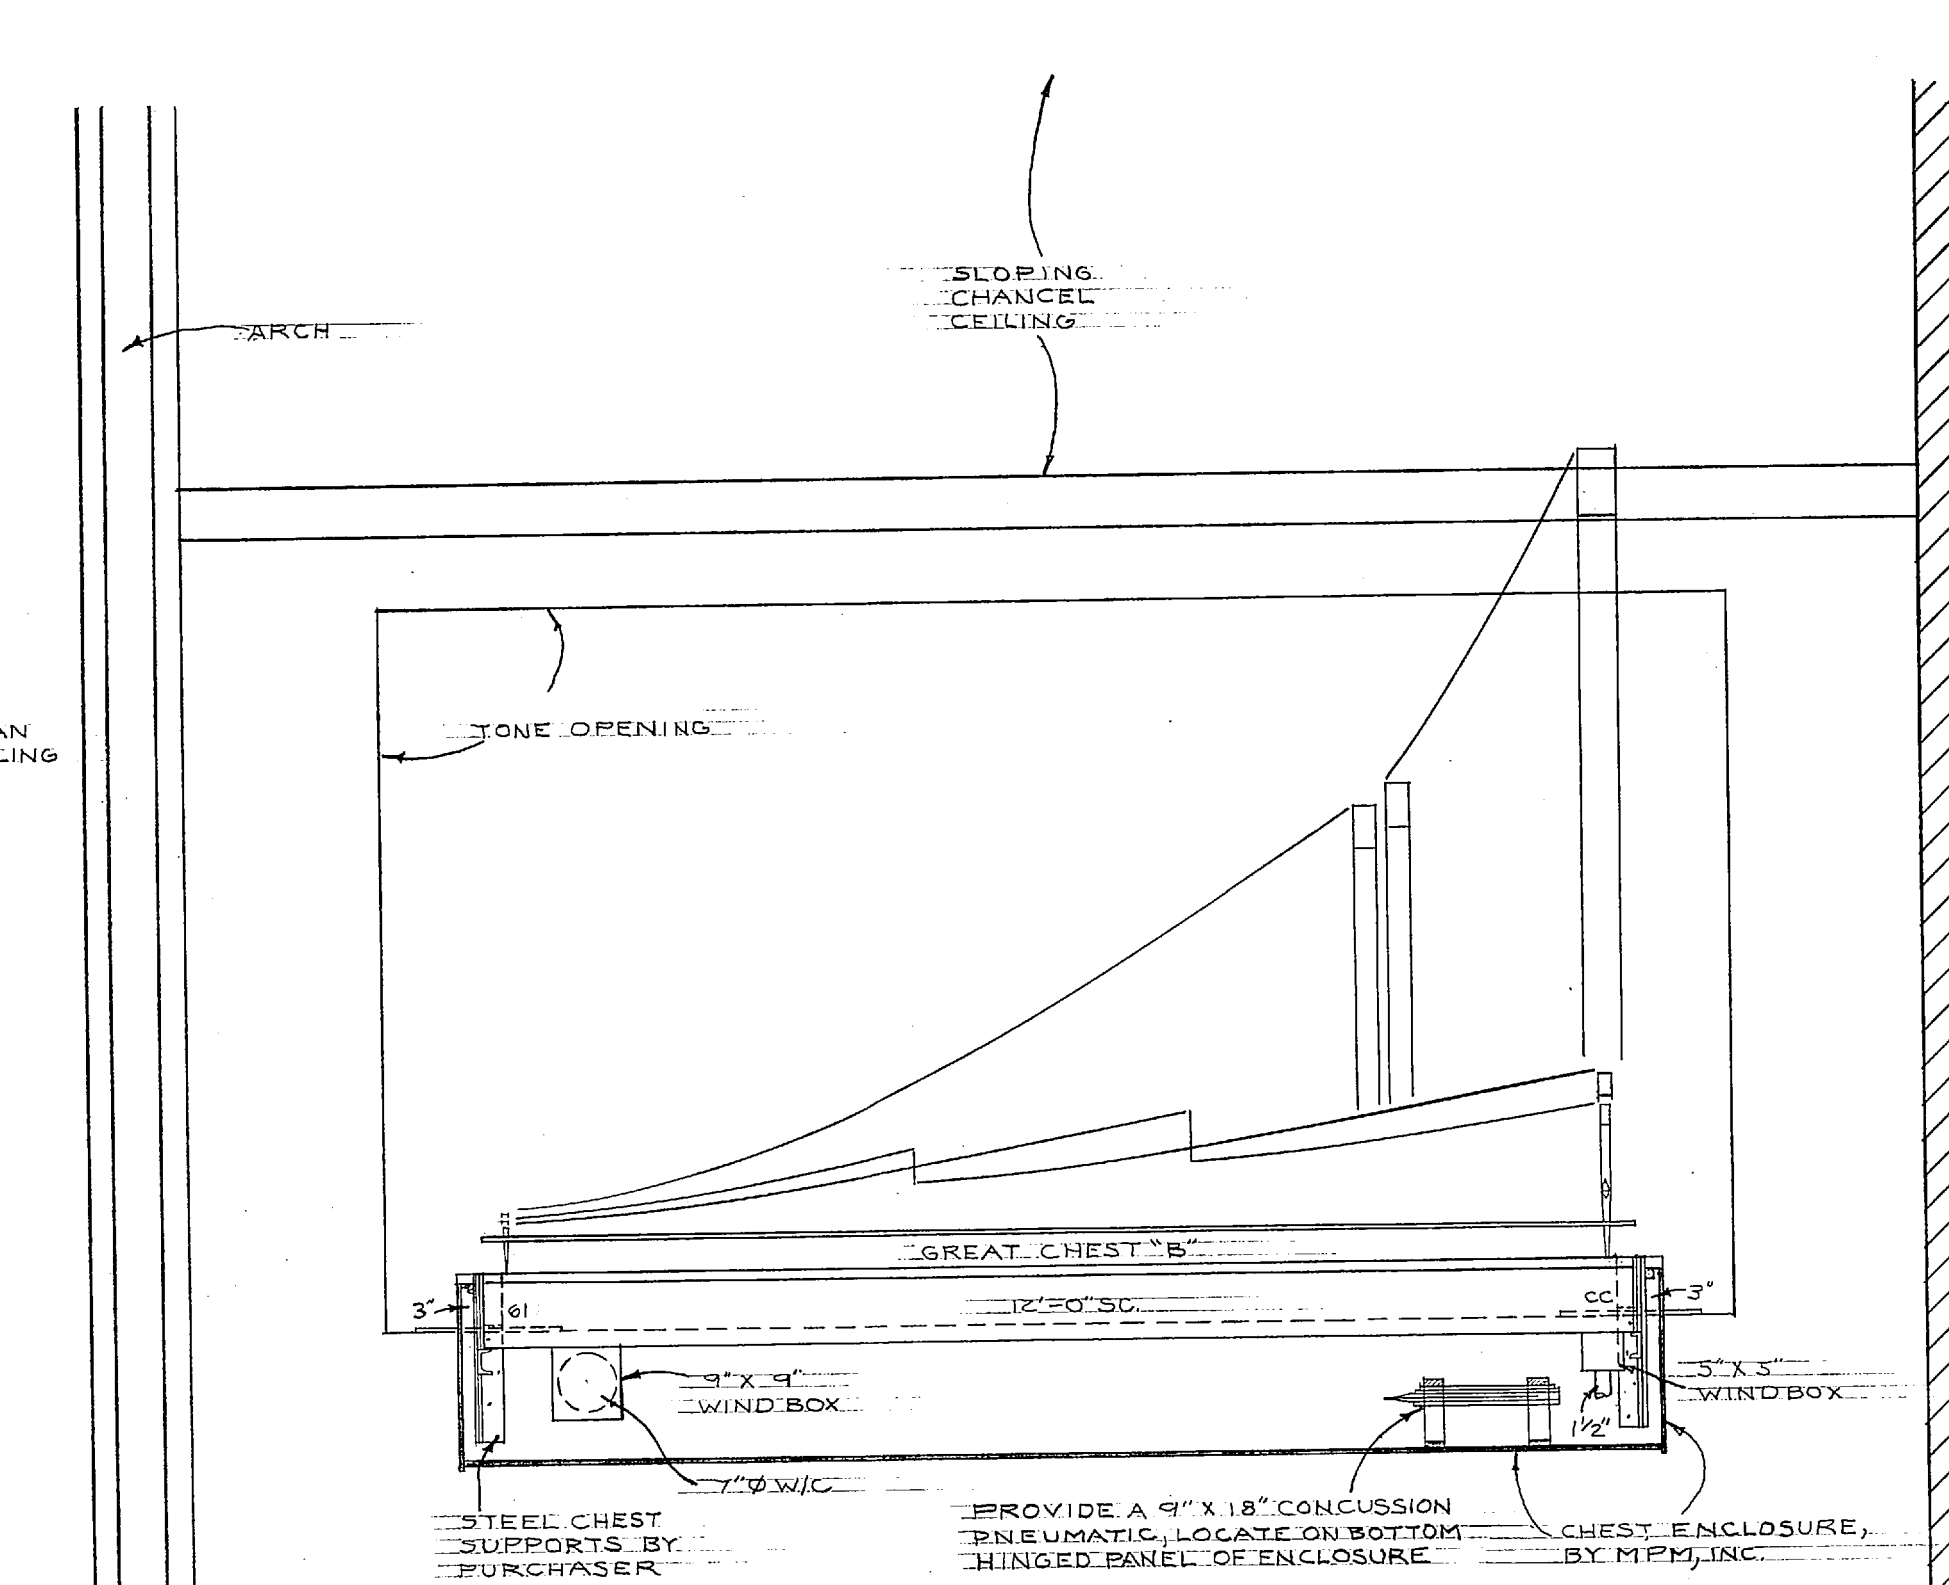


SECTION THRU EXPOSED  
GREAT CHEST "B"

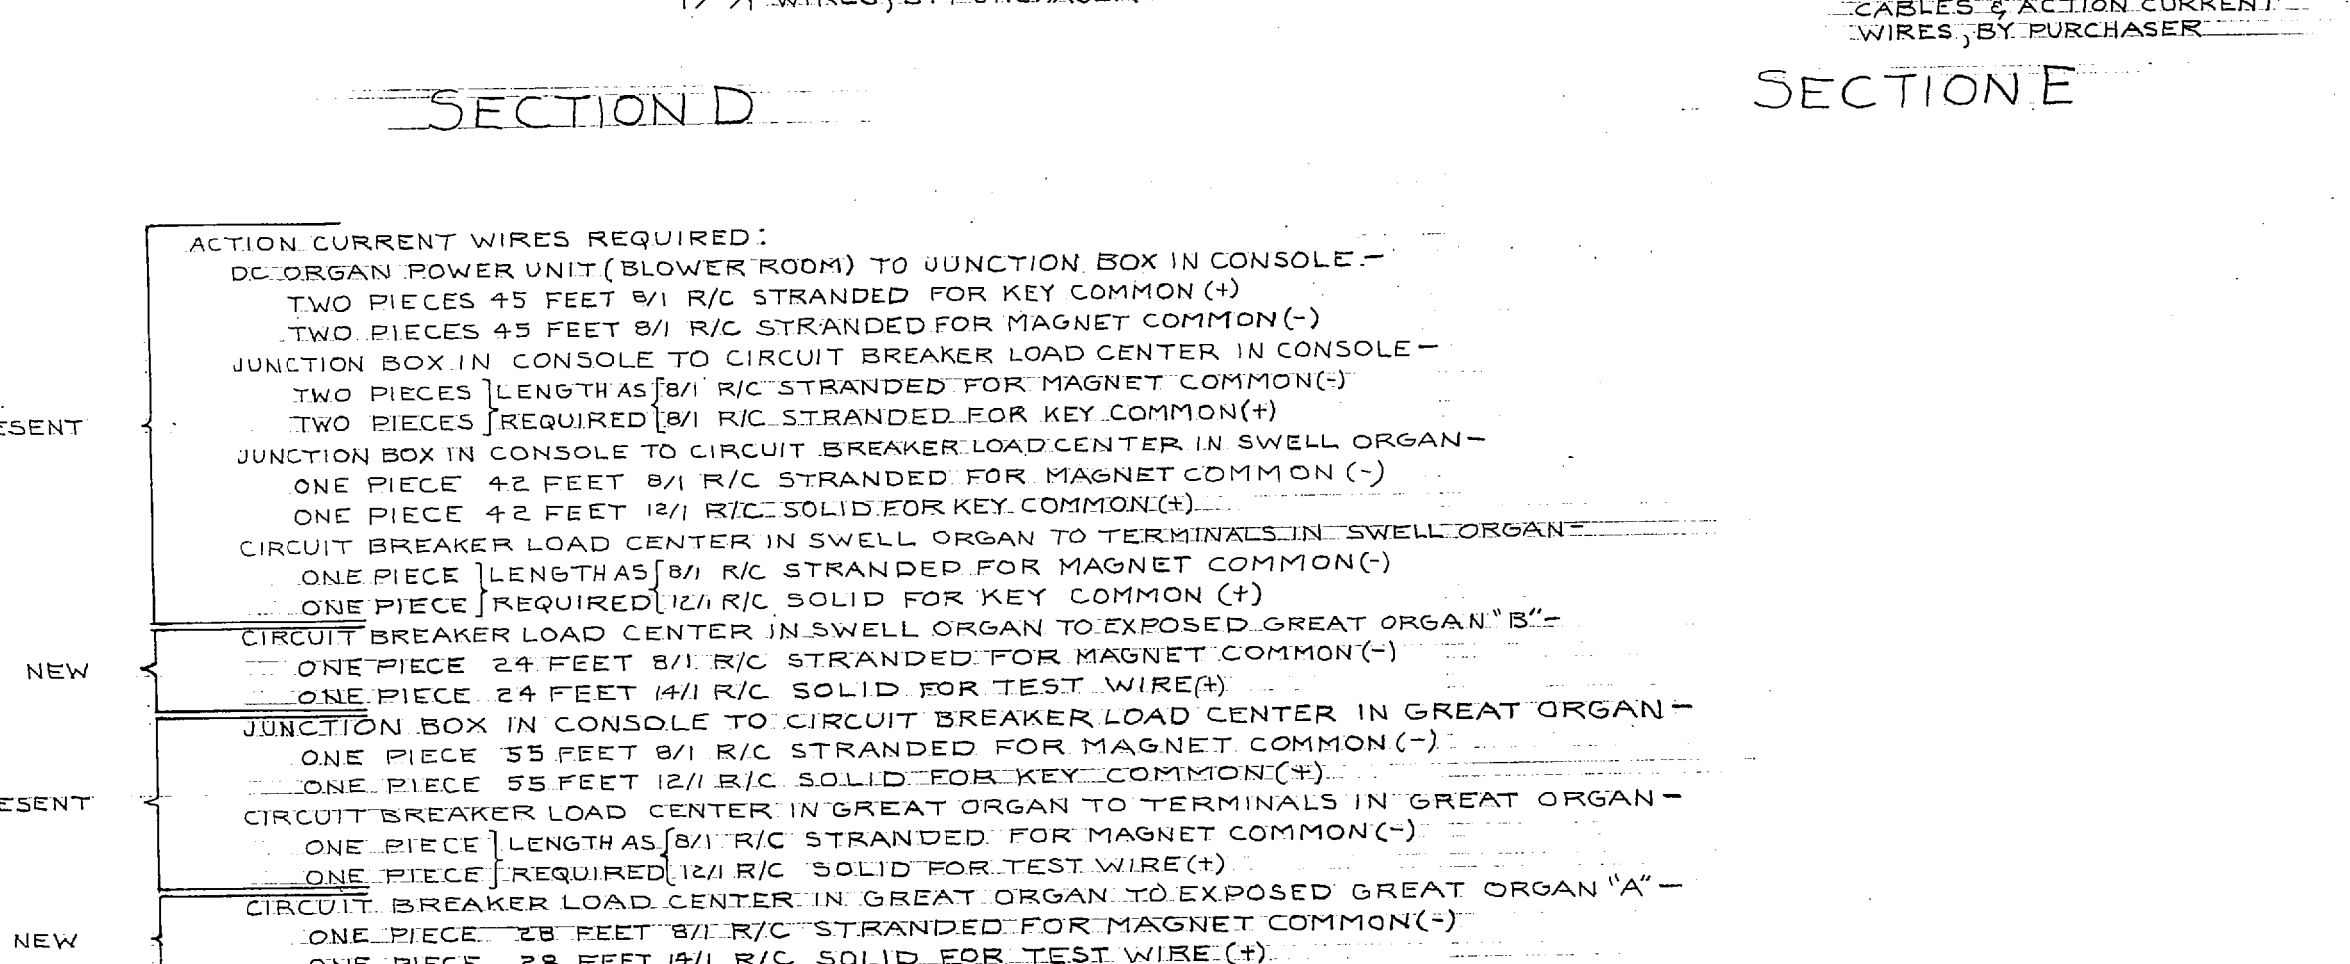


## FLOOR PLAN

AUDITORIUM  
ELEY-O

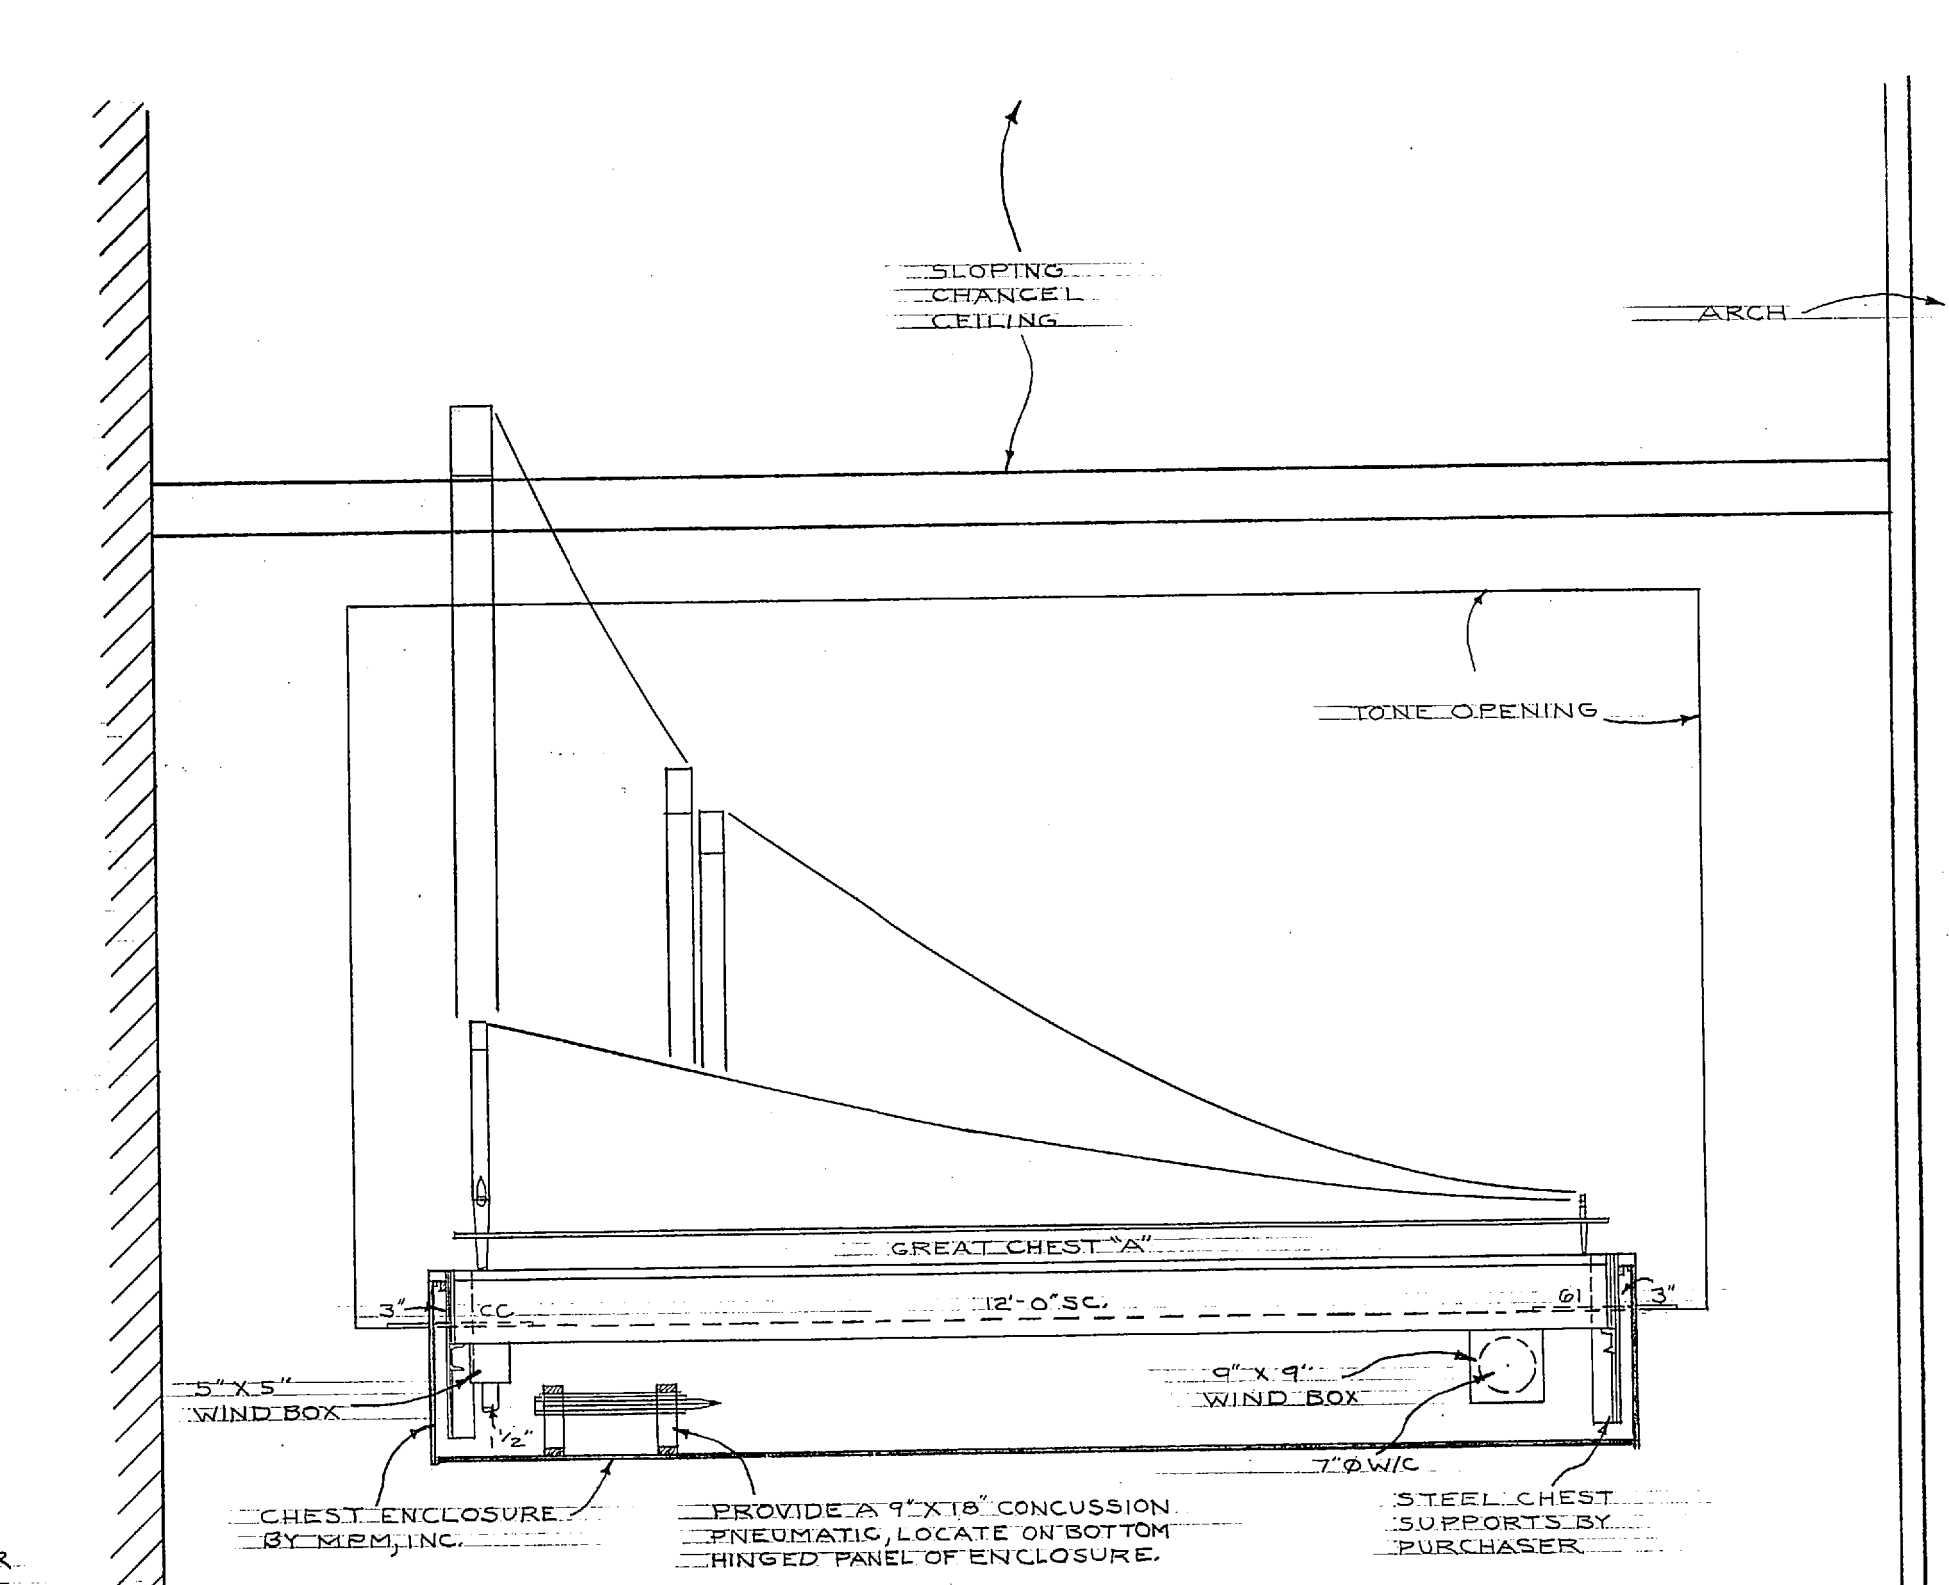


SECTION THRU EXPOSE  
GREAT CHEST "A"

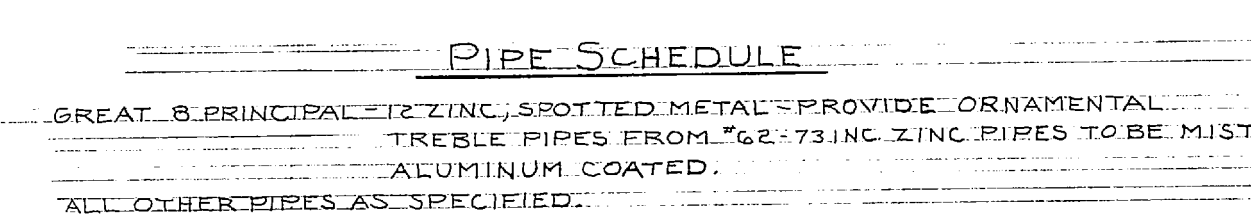

PIPE SCHEDULE

## FINISH SCHEDULE

RACKBOARDS, 4 RACKPINS FOR EXPOSED GREAT CHESTS "A" & "B" TO BE OF PLAIN WHITE OAK, 2" STAIN FINISHED TO MATCH ENCLOSURE. DO NOT PROVIDE BACK BOARD BRACKETS FOR THESE CHESTS. RACKPOSTS FOR 4 PRINCIPAL TO BE OF ALUMINUM TUBING WITH PLYWOOD PIPERACKS & FINISHED CHARCOAL GRAY. REFER TO MEMO DATED 6-25-59 FOR ADDITIONAL DETAILS.

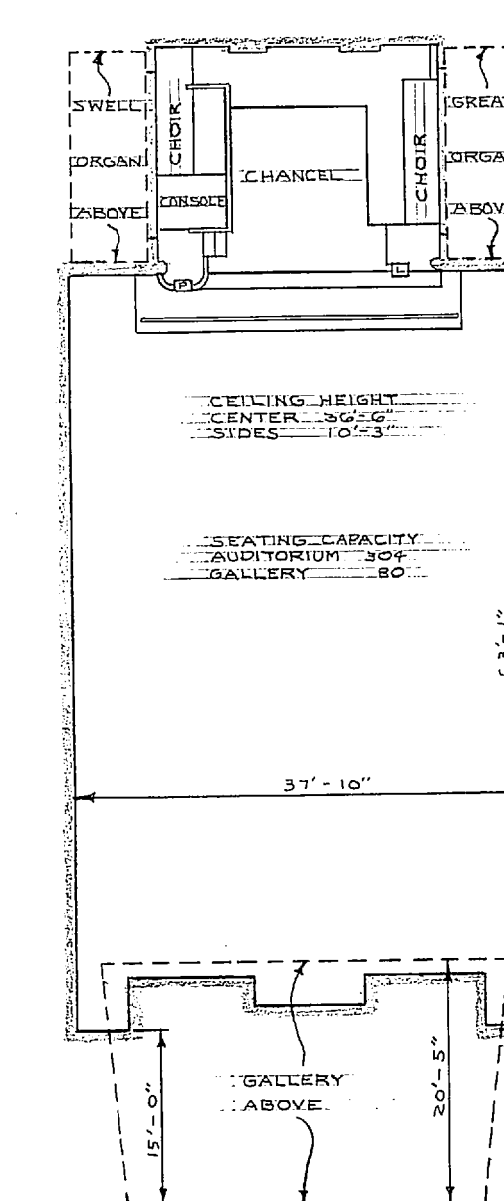

AUDITORIUM PLAN  
SCALE=1/4"=1'-0"

NEW GREAT CABLE JUNCTION IN SWELL ORGAN TO EXPOSED GREAT ORGAN'S  
GREAT STATION "B" C STOPS ——— DNE 66 COND.

PULL BOXES SHOULD BE PLACED AT ALL SHARP BENDS OF LARGE CONDUITS. IF CONDUITS ARE NOT  
 MAINTAIN 18 INCHES PROVIDE EQUIVALENT SPACE.

ACTION \_\_\_\_\_ ELECTRO-PNEUMATIC  
CASING \_\_\_\_\_ NONE  
DISPLAY PIPES \_\_\_\_\_ NONE  
MANUALS \_\_\_\_\_ TWO 1/2 PEDAL  
CONSOLE \_\_\_\_\_ DETERMINED \*PAIN WHITE OAK \*COLOR BLOK \*R-534  
STOP CONTROLS \_\_\_\_\_ TILTING TABLETS  
WIND PRESSURE \_\_\_\_\_ 4"  
PITCH \_\_\_\_\_ A-440 @ 70°F

WIND CONDUCTORS, CONDUITS, ALL ELECTRICAL WIRING TO BLOWER MOTOR, & ORGAN POWER UNIT INCLUDING NECESSARY POWER SUPPLIES, AC SAFETY SWITCHES, & MOTOR STARTERS, CONDUITS & AC WIRING TO ORGAN POWER UNIT TO BE SUPPLIED & INSTALLED BY PURCHASER. LIGHT OUTLETS, LIGHT CONTROLS, SIGNAL SYSTEM DESIRED AT CONSOLE INCLUDING CONDUITS, WIRING, ETC TO BE SUPPLIED & INSTALLED BY PURCHASER. LIGHT OUTLETS, BULBS, WALL SWITCHES & RECEPTACLES WITHIN ORGAN SPACE INCLUDING CONDUITS, WIRING, ETC. TO BE SUPPLIED & INSTALLED BY PURCHASER.

CONSOLE APPROVED BY EUGENE TROTH DATE 8-27-57  
DIMENSIONS OK BY D. WALSH DATE 1-17-58

WEST SIDE METHODIST CHURCH,  
ANN ARBOR, MICHIGAN

|                      |      |           |                 |                 |
|----------------------|------|-----------|-----------------|-----------------|
| SCALE = 1/2" = 1'-0" |      |           | MPMÖLLER, INC.  | A-9161          |
| REV.                 | REV. | REV. DATE |                 |                 |
|                      |      | 8-2-81    | HAGERSTOWN, MD. | DRAWING NO. 105 |

3 FOLD - MEMO  
6/11/69

2 FOLIO MEMO  
6/11/69