

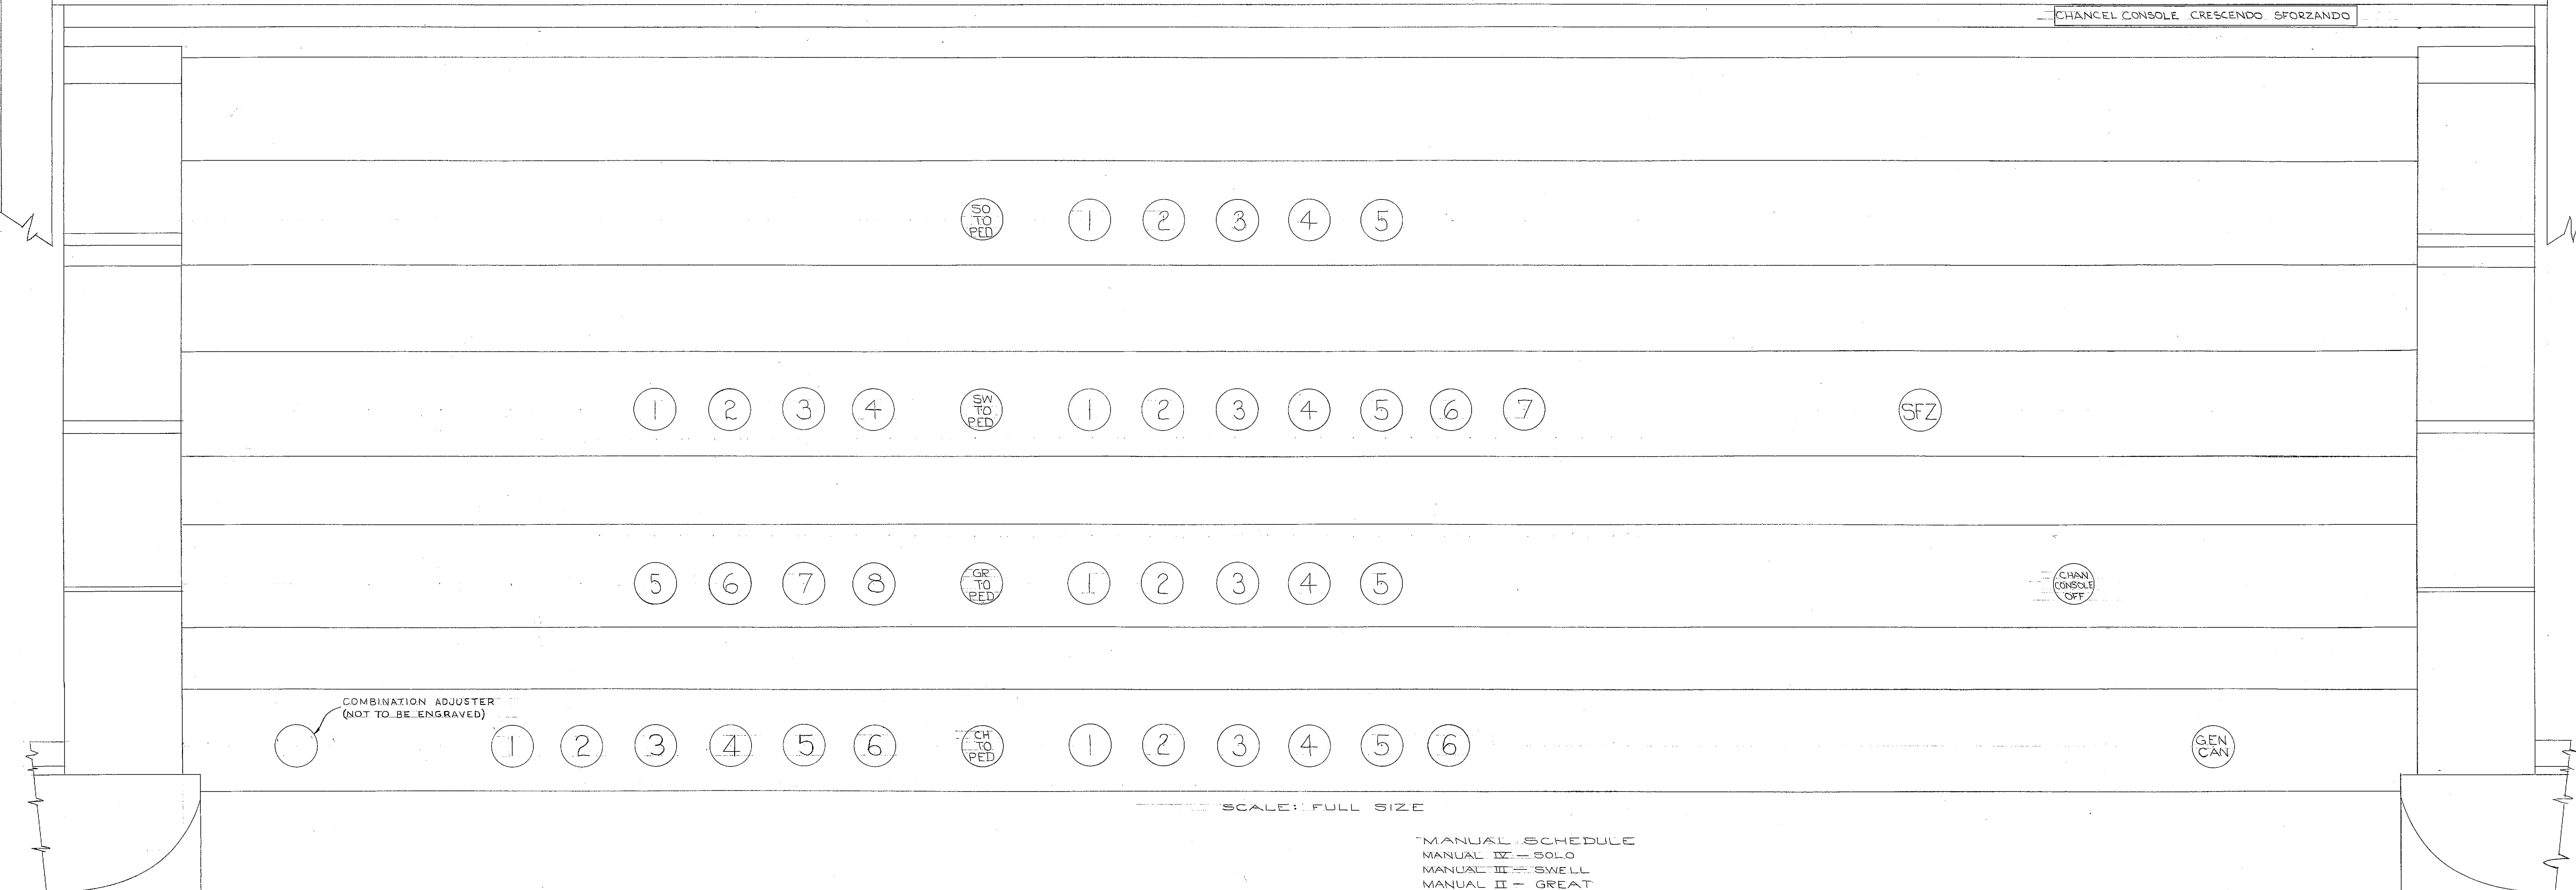
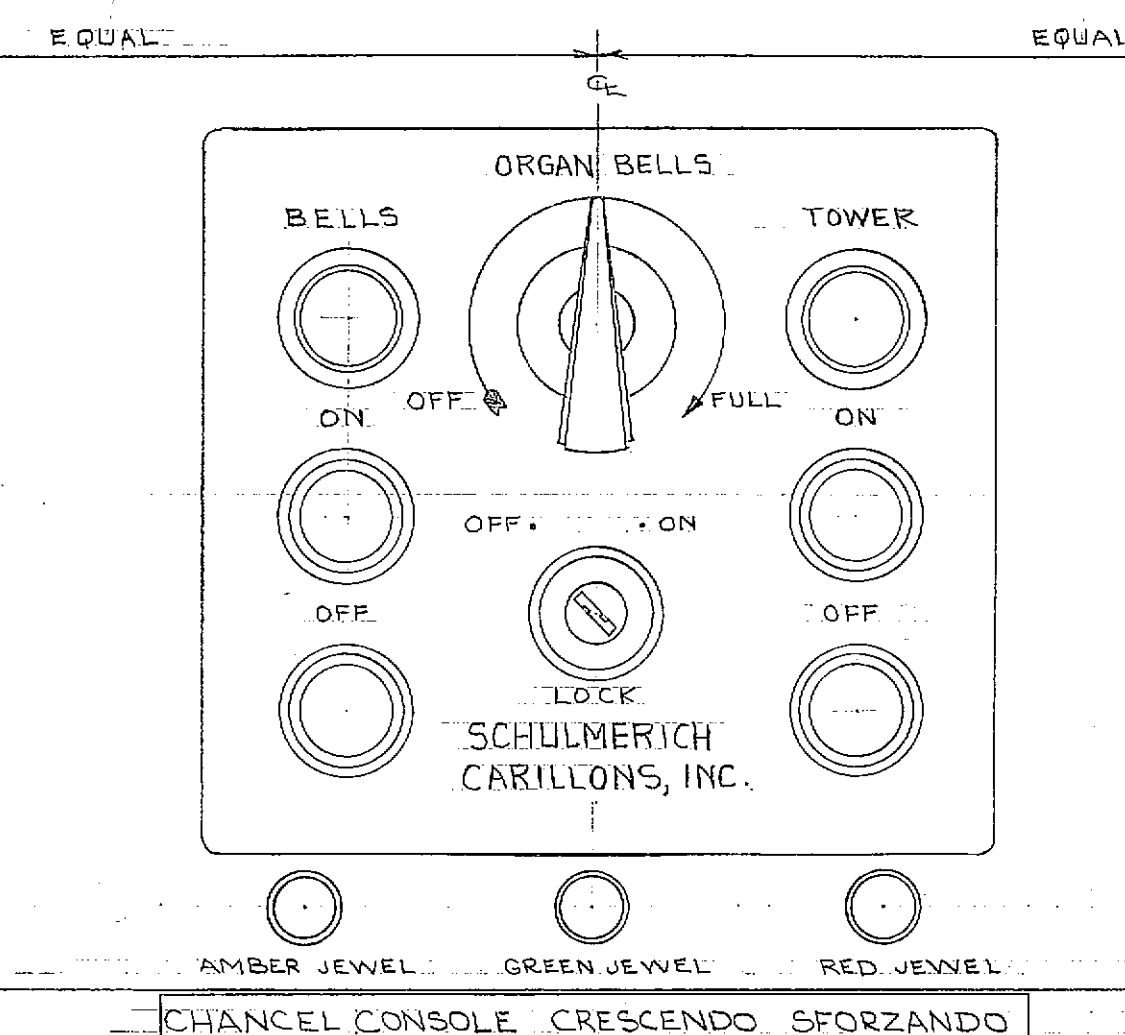
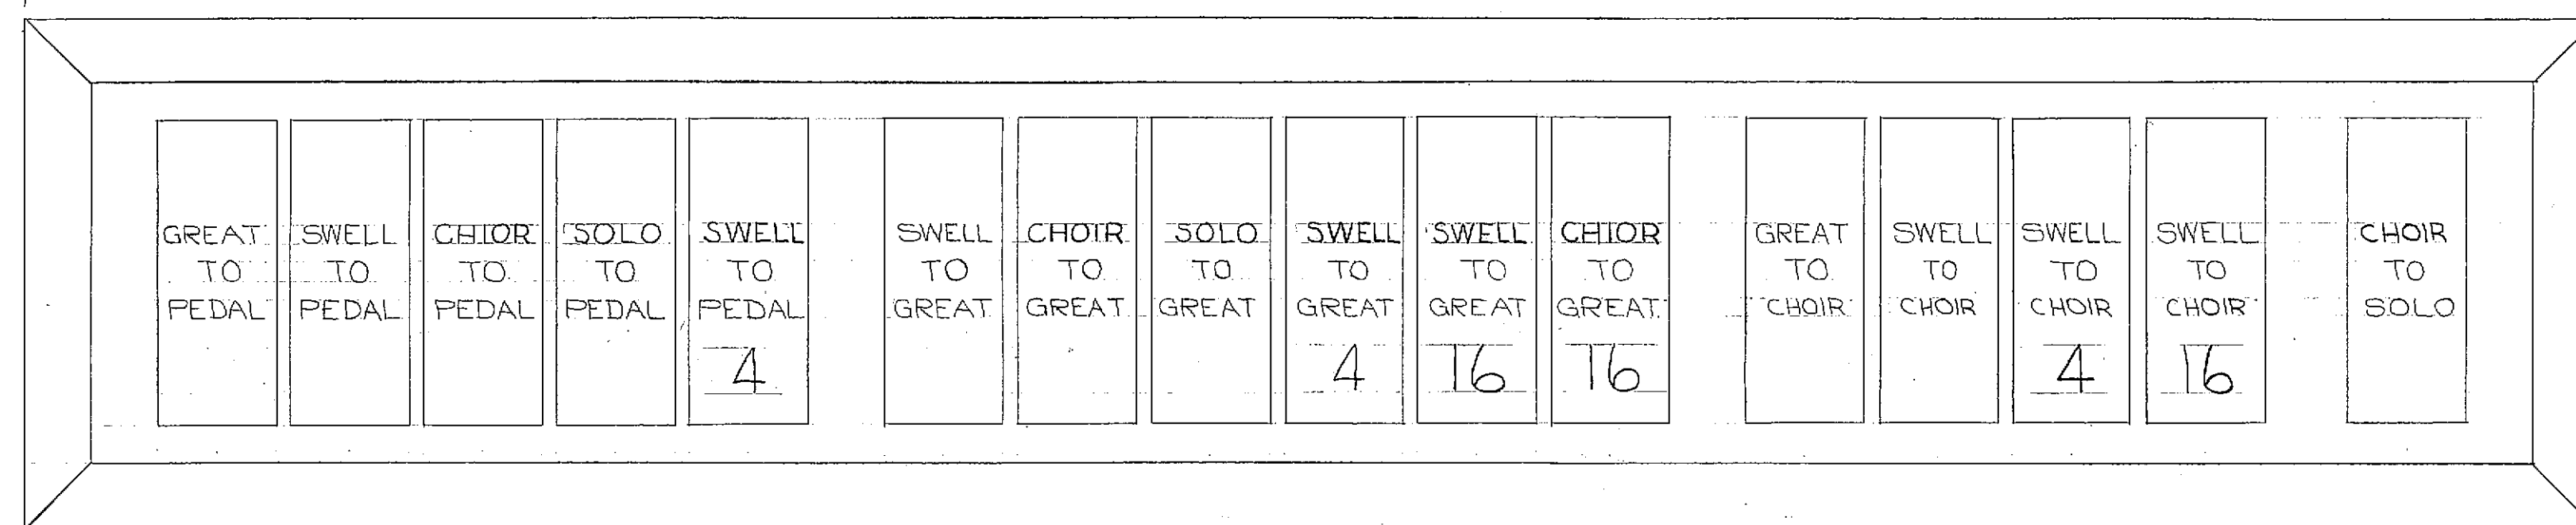


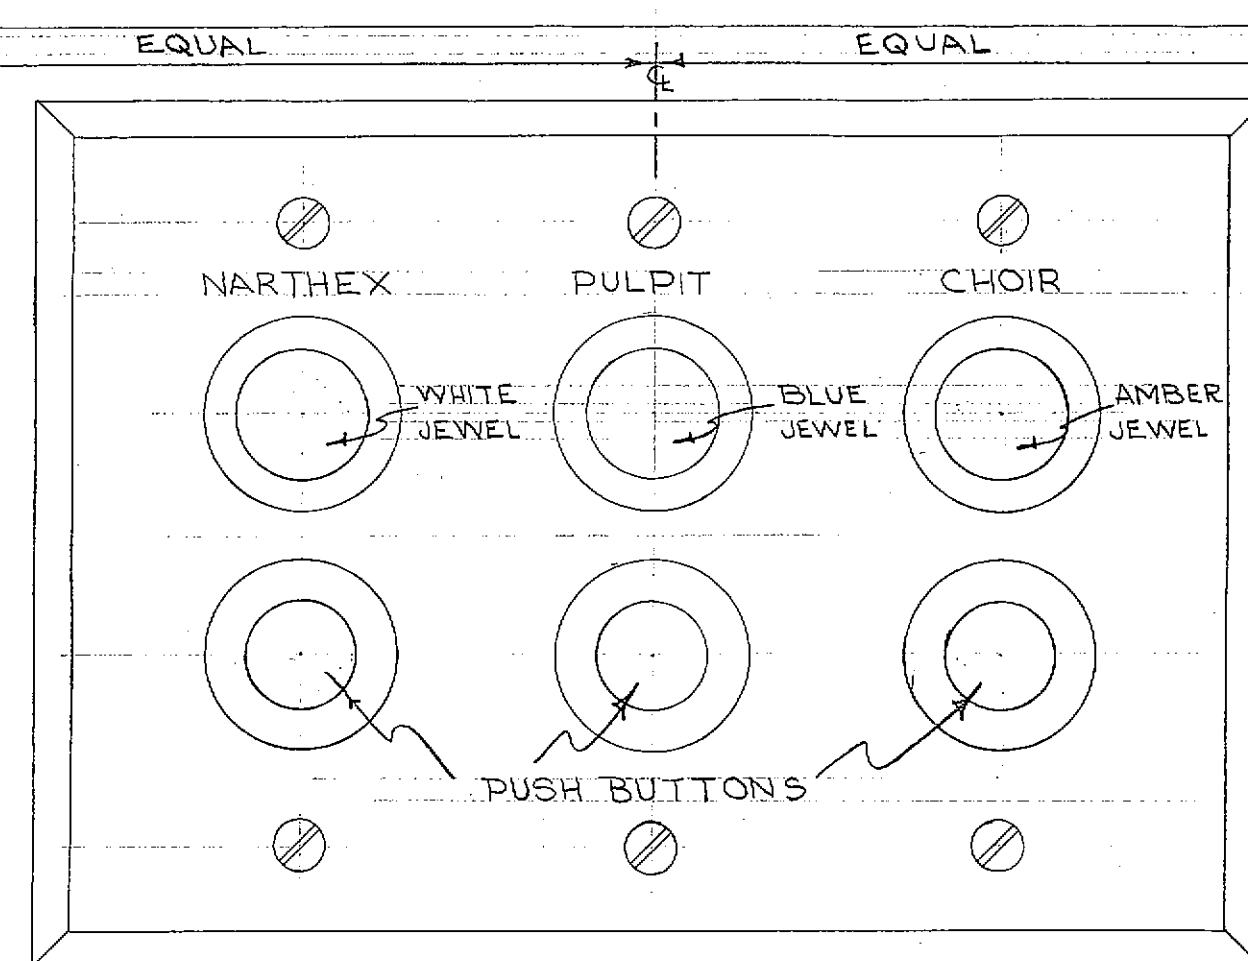

MANUAL SCHEDULE
 MANUAL IV - SOLO
 MANUAL III - SWELL
 MANUAL II - GREAT
 MANUAL I - CHOIR

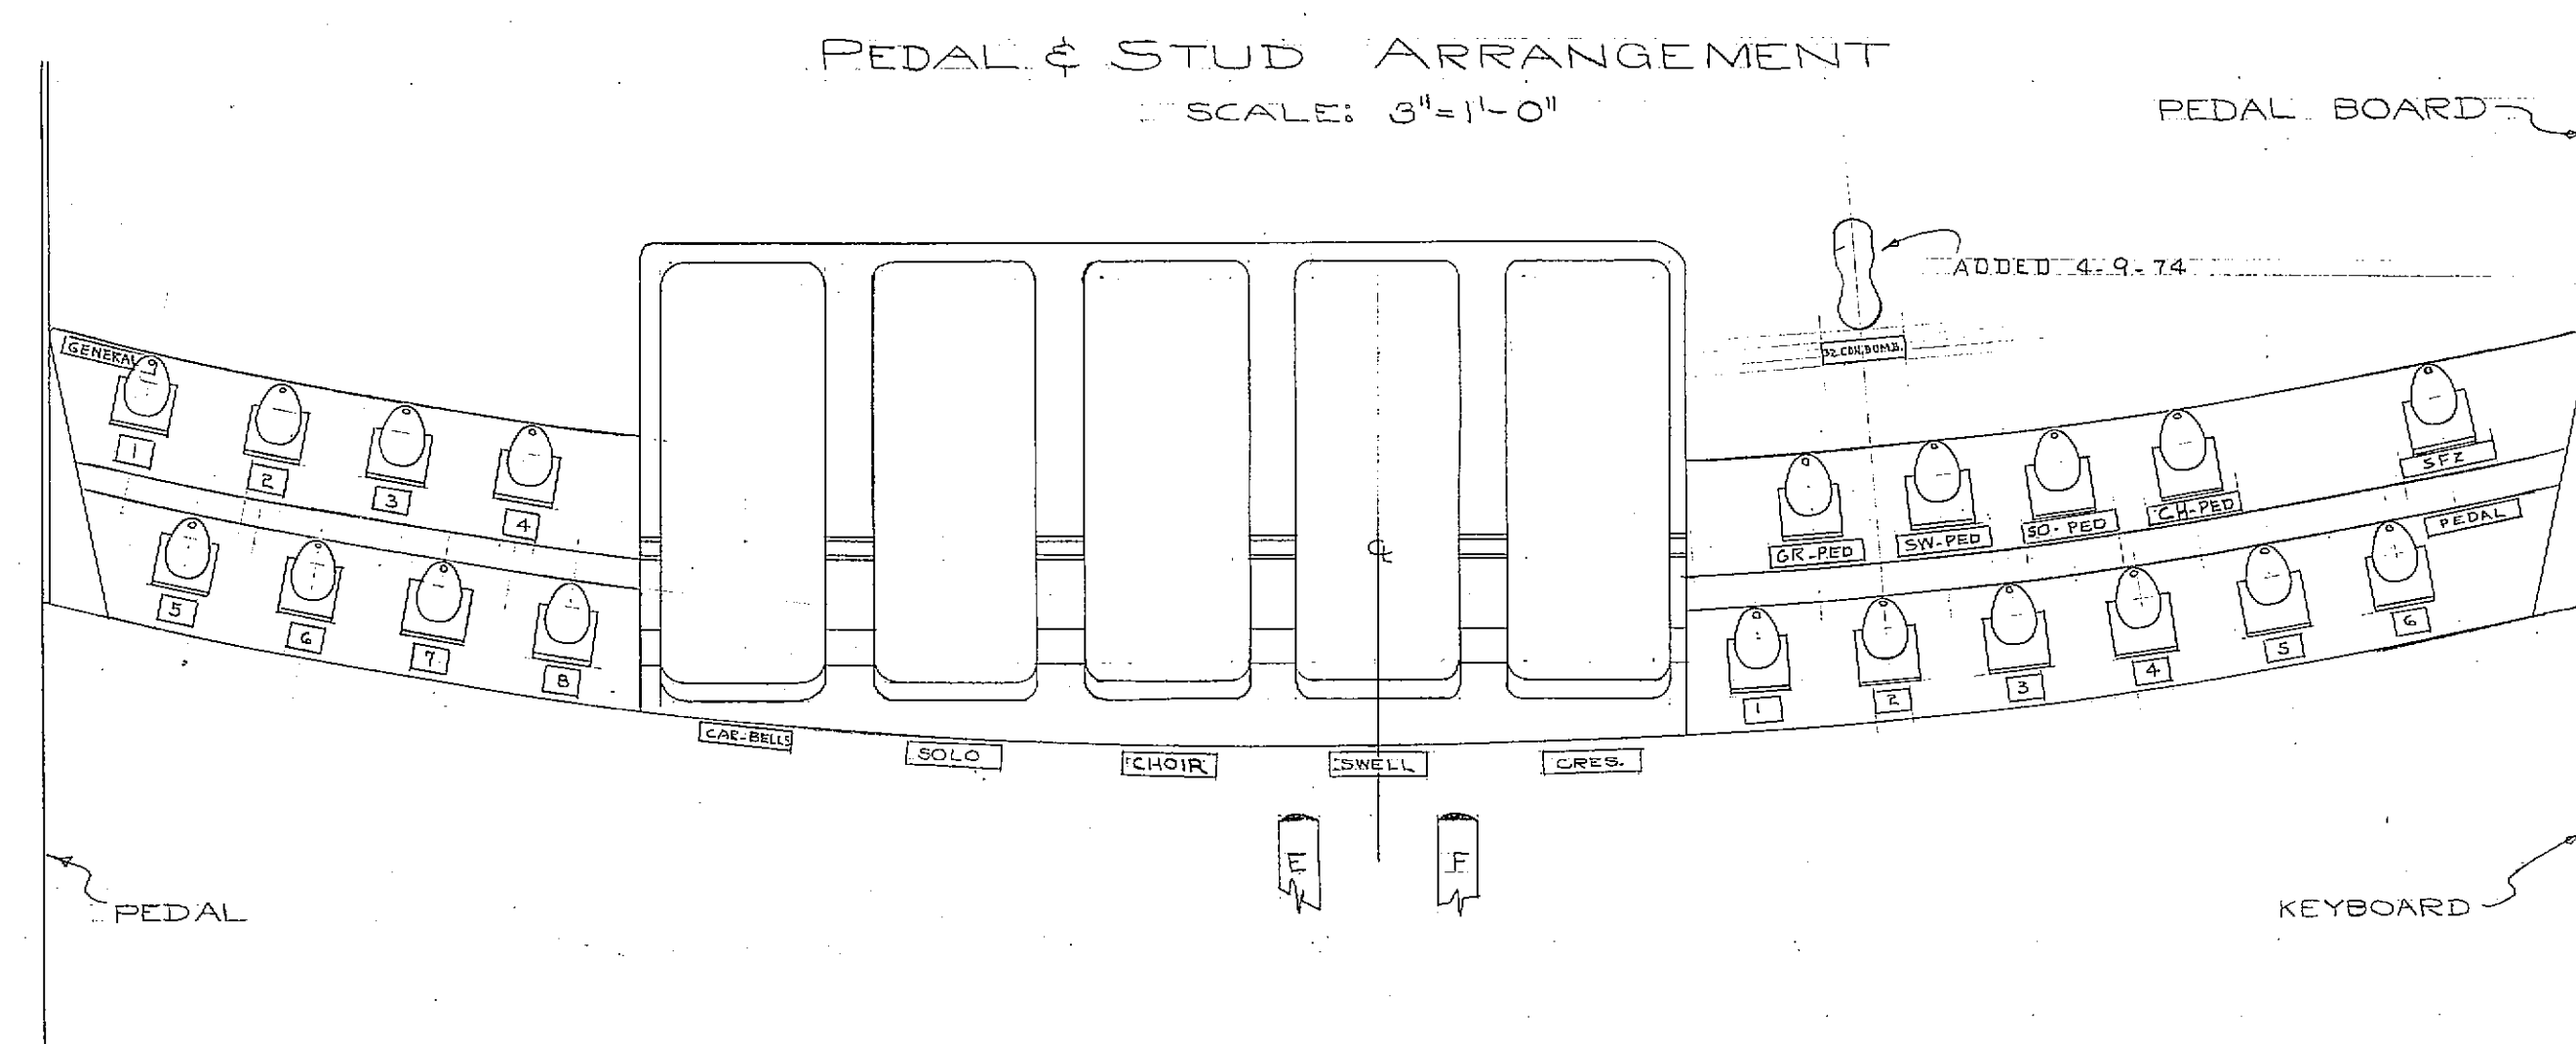

NOTE - ALL ENGRAVING TO BE IN BLACK

SEE DRAWING NO. 102 FOR CONSOLE CABINET SIZE & DESIGN.
 ROLL TOP, REGULAR MANUALS, ENGLISH KEYS.
 REMOTE CONTROL COMBINATION ACTION.
 MULTIPLE CONTACTS & SWITCHES FOR COUPLERS.

GALLERY CONSOLE

PURCHASER'S APPROVAL: LAURENCE B. HEDSPETH DATE: 2-18-65


MIAMI SHORES PRESBYTERIAN CHURCH,
 MIAMI SHORES, FLORIDA

REV.	REV.	REV.	REV.	REV.	REV.	CHECKED	DRAWN	DATE
4-6-74	7-20-67	5-25-67	5-23-67	8-24-66	8-12-65	C.	R.L.S.	5-9-65



M.P. MÖLLER, INC.
 HAGERSTOWN, MD.

10090
 DRAWING NO. 101-A

32 CONTRE BOMBARDE ADDED 4-9-74

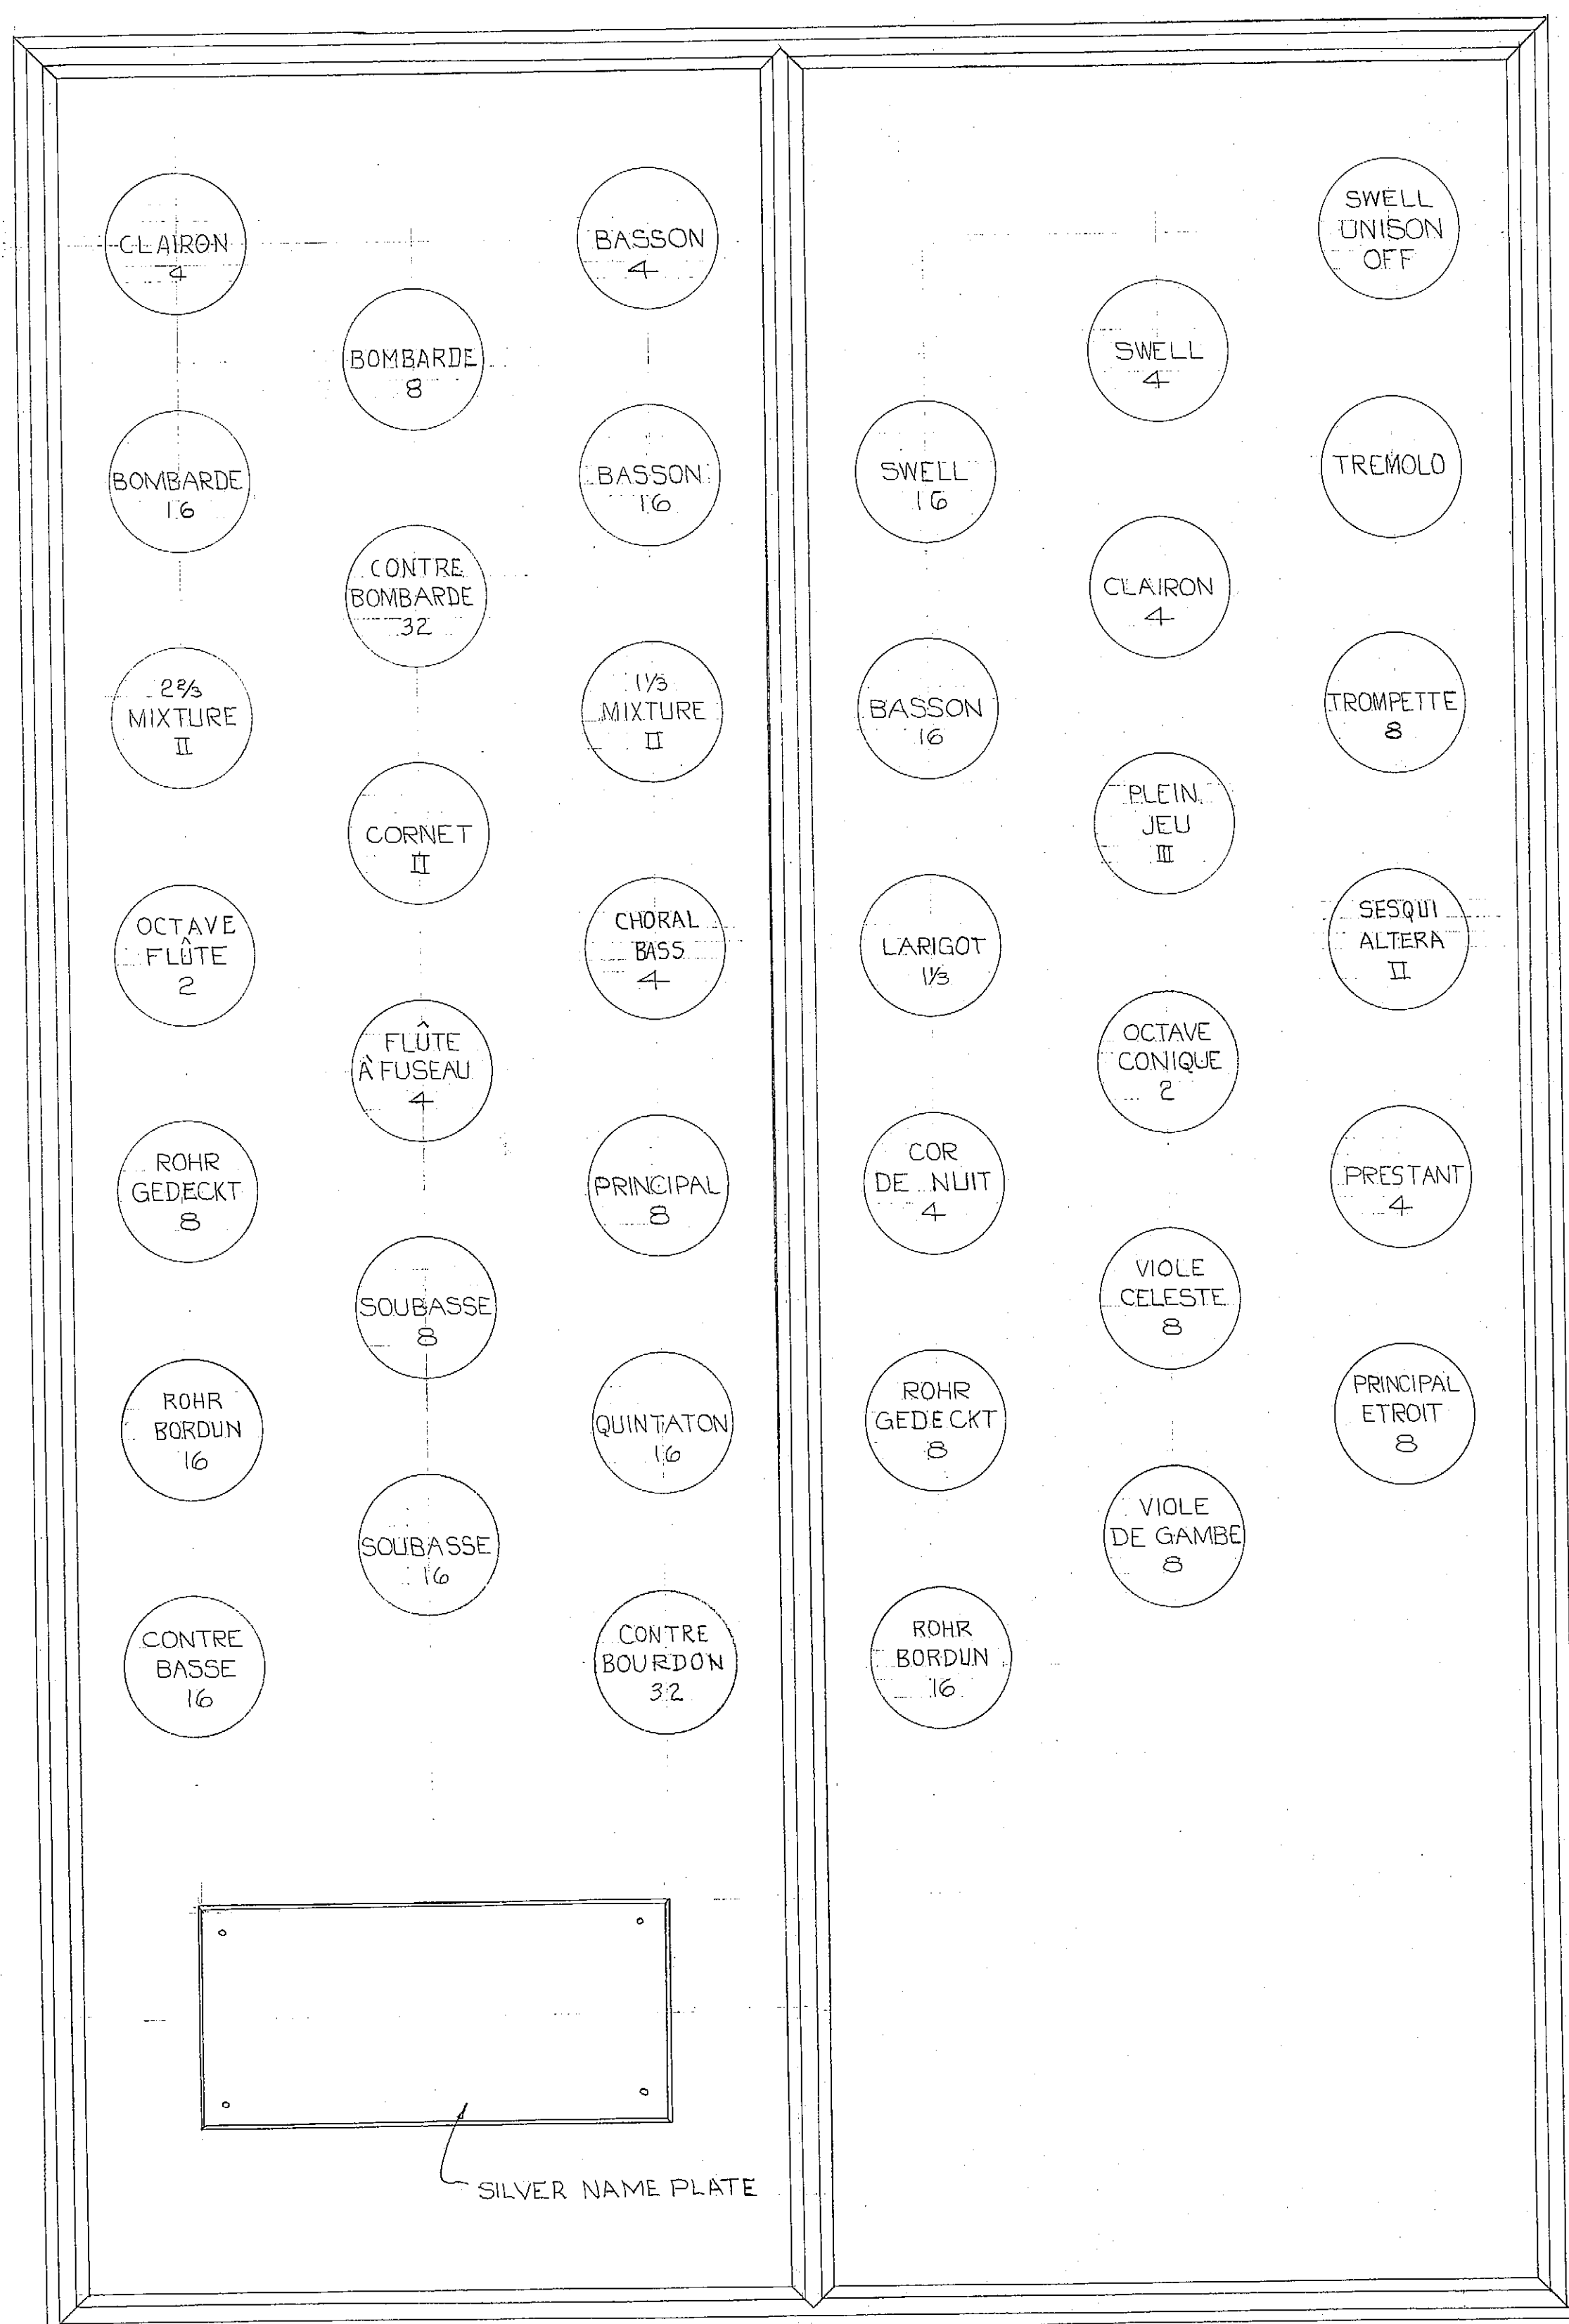

LEFT

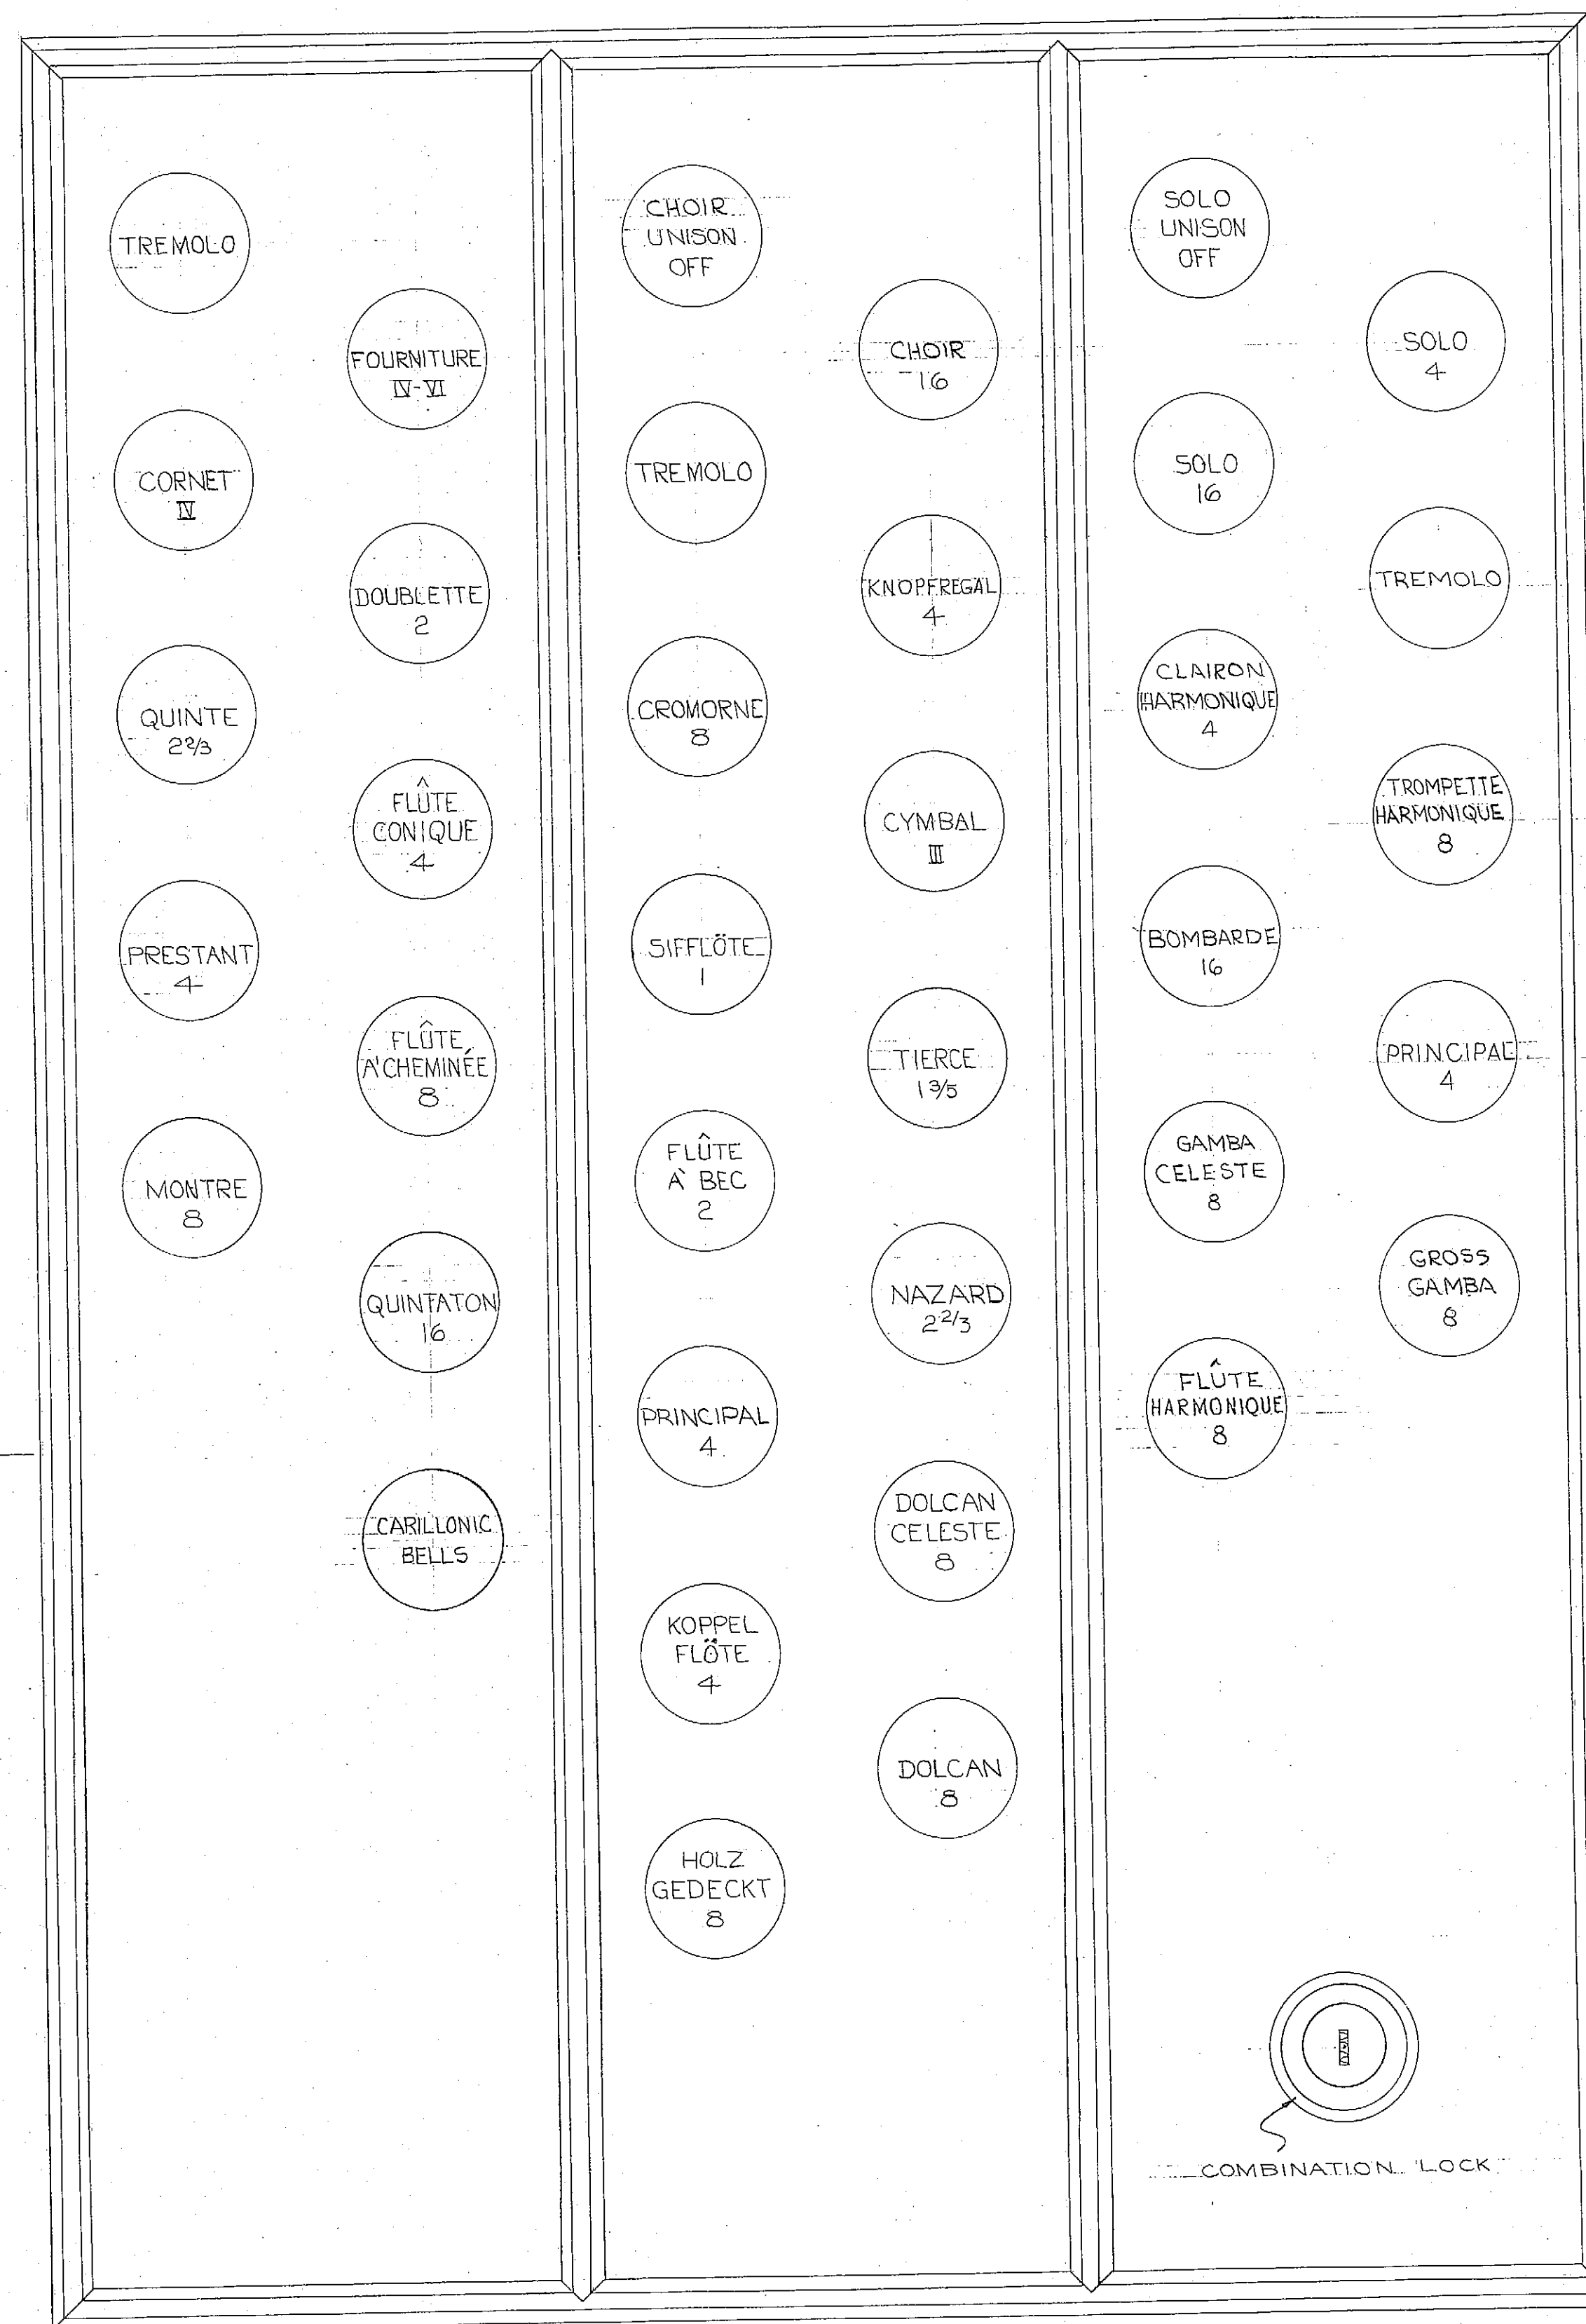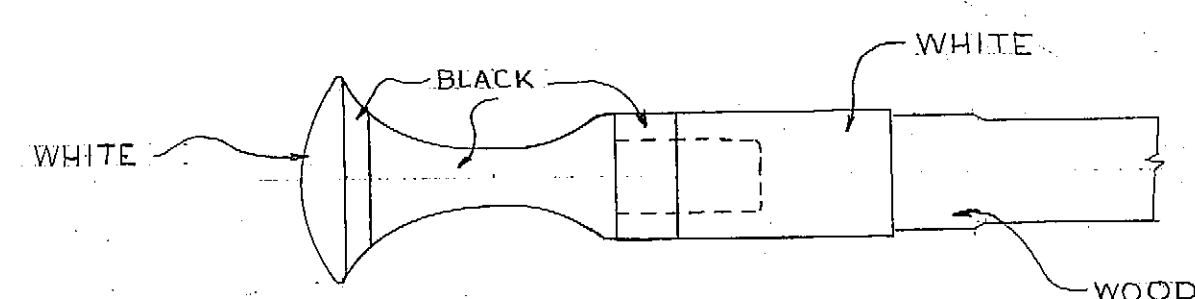

RIGHT

NOTE-ALL ENGRAVING TO BE IN BLACK
REMOTE CONTROL COMBINATION ACTION

GALLERY CONSOLE

PURCHASER'S APPROVAL: LAURENCE B. HEDGPETH

DATE: 4-28-65

MIAMI SHORES PRESBYTERIAN CHURCH,
MIAMI SHORES, FLORIDA

SCALE: FULL SIZE


M.P. MÖLLER, INC.
HAGERSTOWN, MD.

10090
DRAWING NO. 101-B

REV.	REV.	REV.	REV.	REV.	REV.	CHECKED	DRAWN	DATE
4-23-64	7-20-67	1-19-67	5-25-67	5-23-67	8-26-66	C	RLS	3-10-65

32 CON,
S.M.S.
(A-10090)

SPELLING

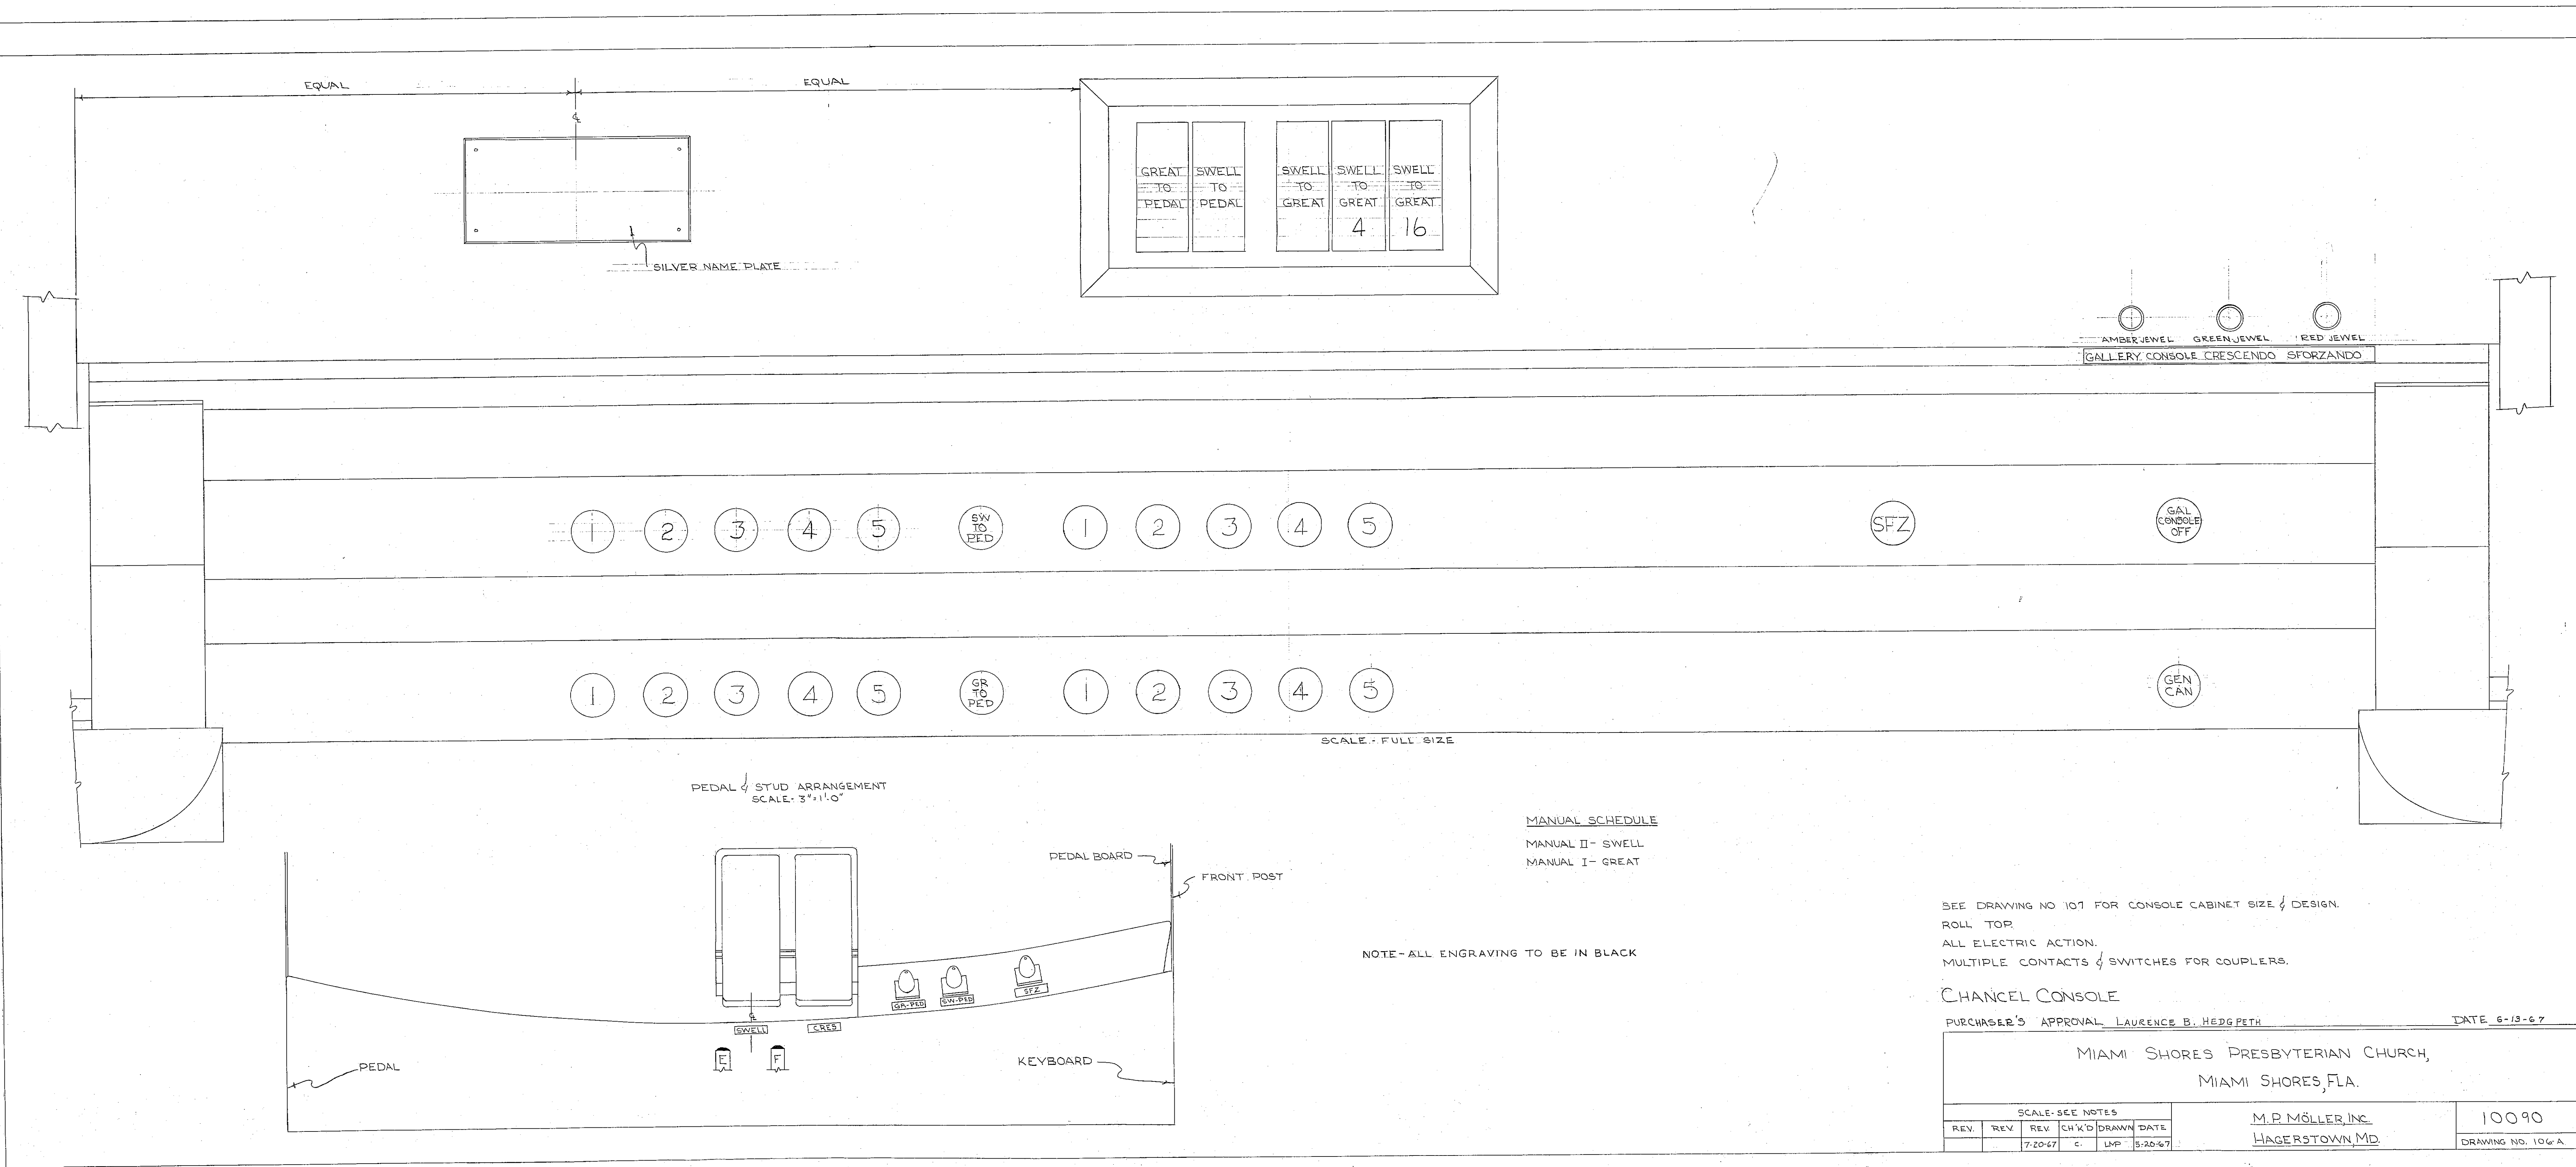

SEE DRAWING NO 101 FOR CONSOLE CABINET SIZE & DESIGN.
ROLL TOP.
ALL ELECTRIC ACTION.
MULTIPLE CONTACTS & SWITCHES FOR COUPLERS.


CHANCEL CONSOLE

PURCHASER'S APPROVAL LAURENCE B. HEDGPETH DATE 6-13-67


MIAMI SHORES PRESBYTERIAN CHURCH,
MIAMI SHORES, FLA.

SCALE-SEE NOTES						M.P. MÖLLER, INC. HAGERSTOWN, MD.		10090	
REV.	REV.	REV.	CH'K'D	DRAWN	DATE				
		7-20-67	C.	LMP	5-20-67			DRAWING NO. 106-A	

DRAWN FOR TILTED MANUALS
LATER BECAME LEVEL MANUALS

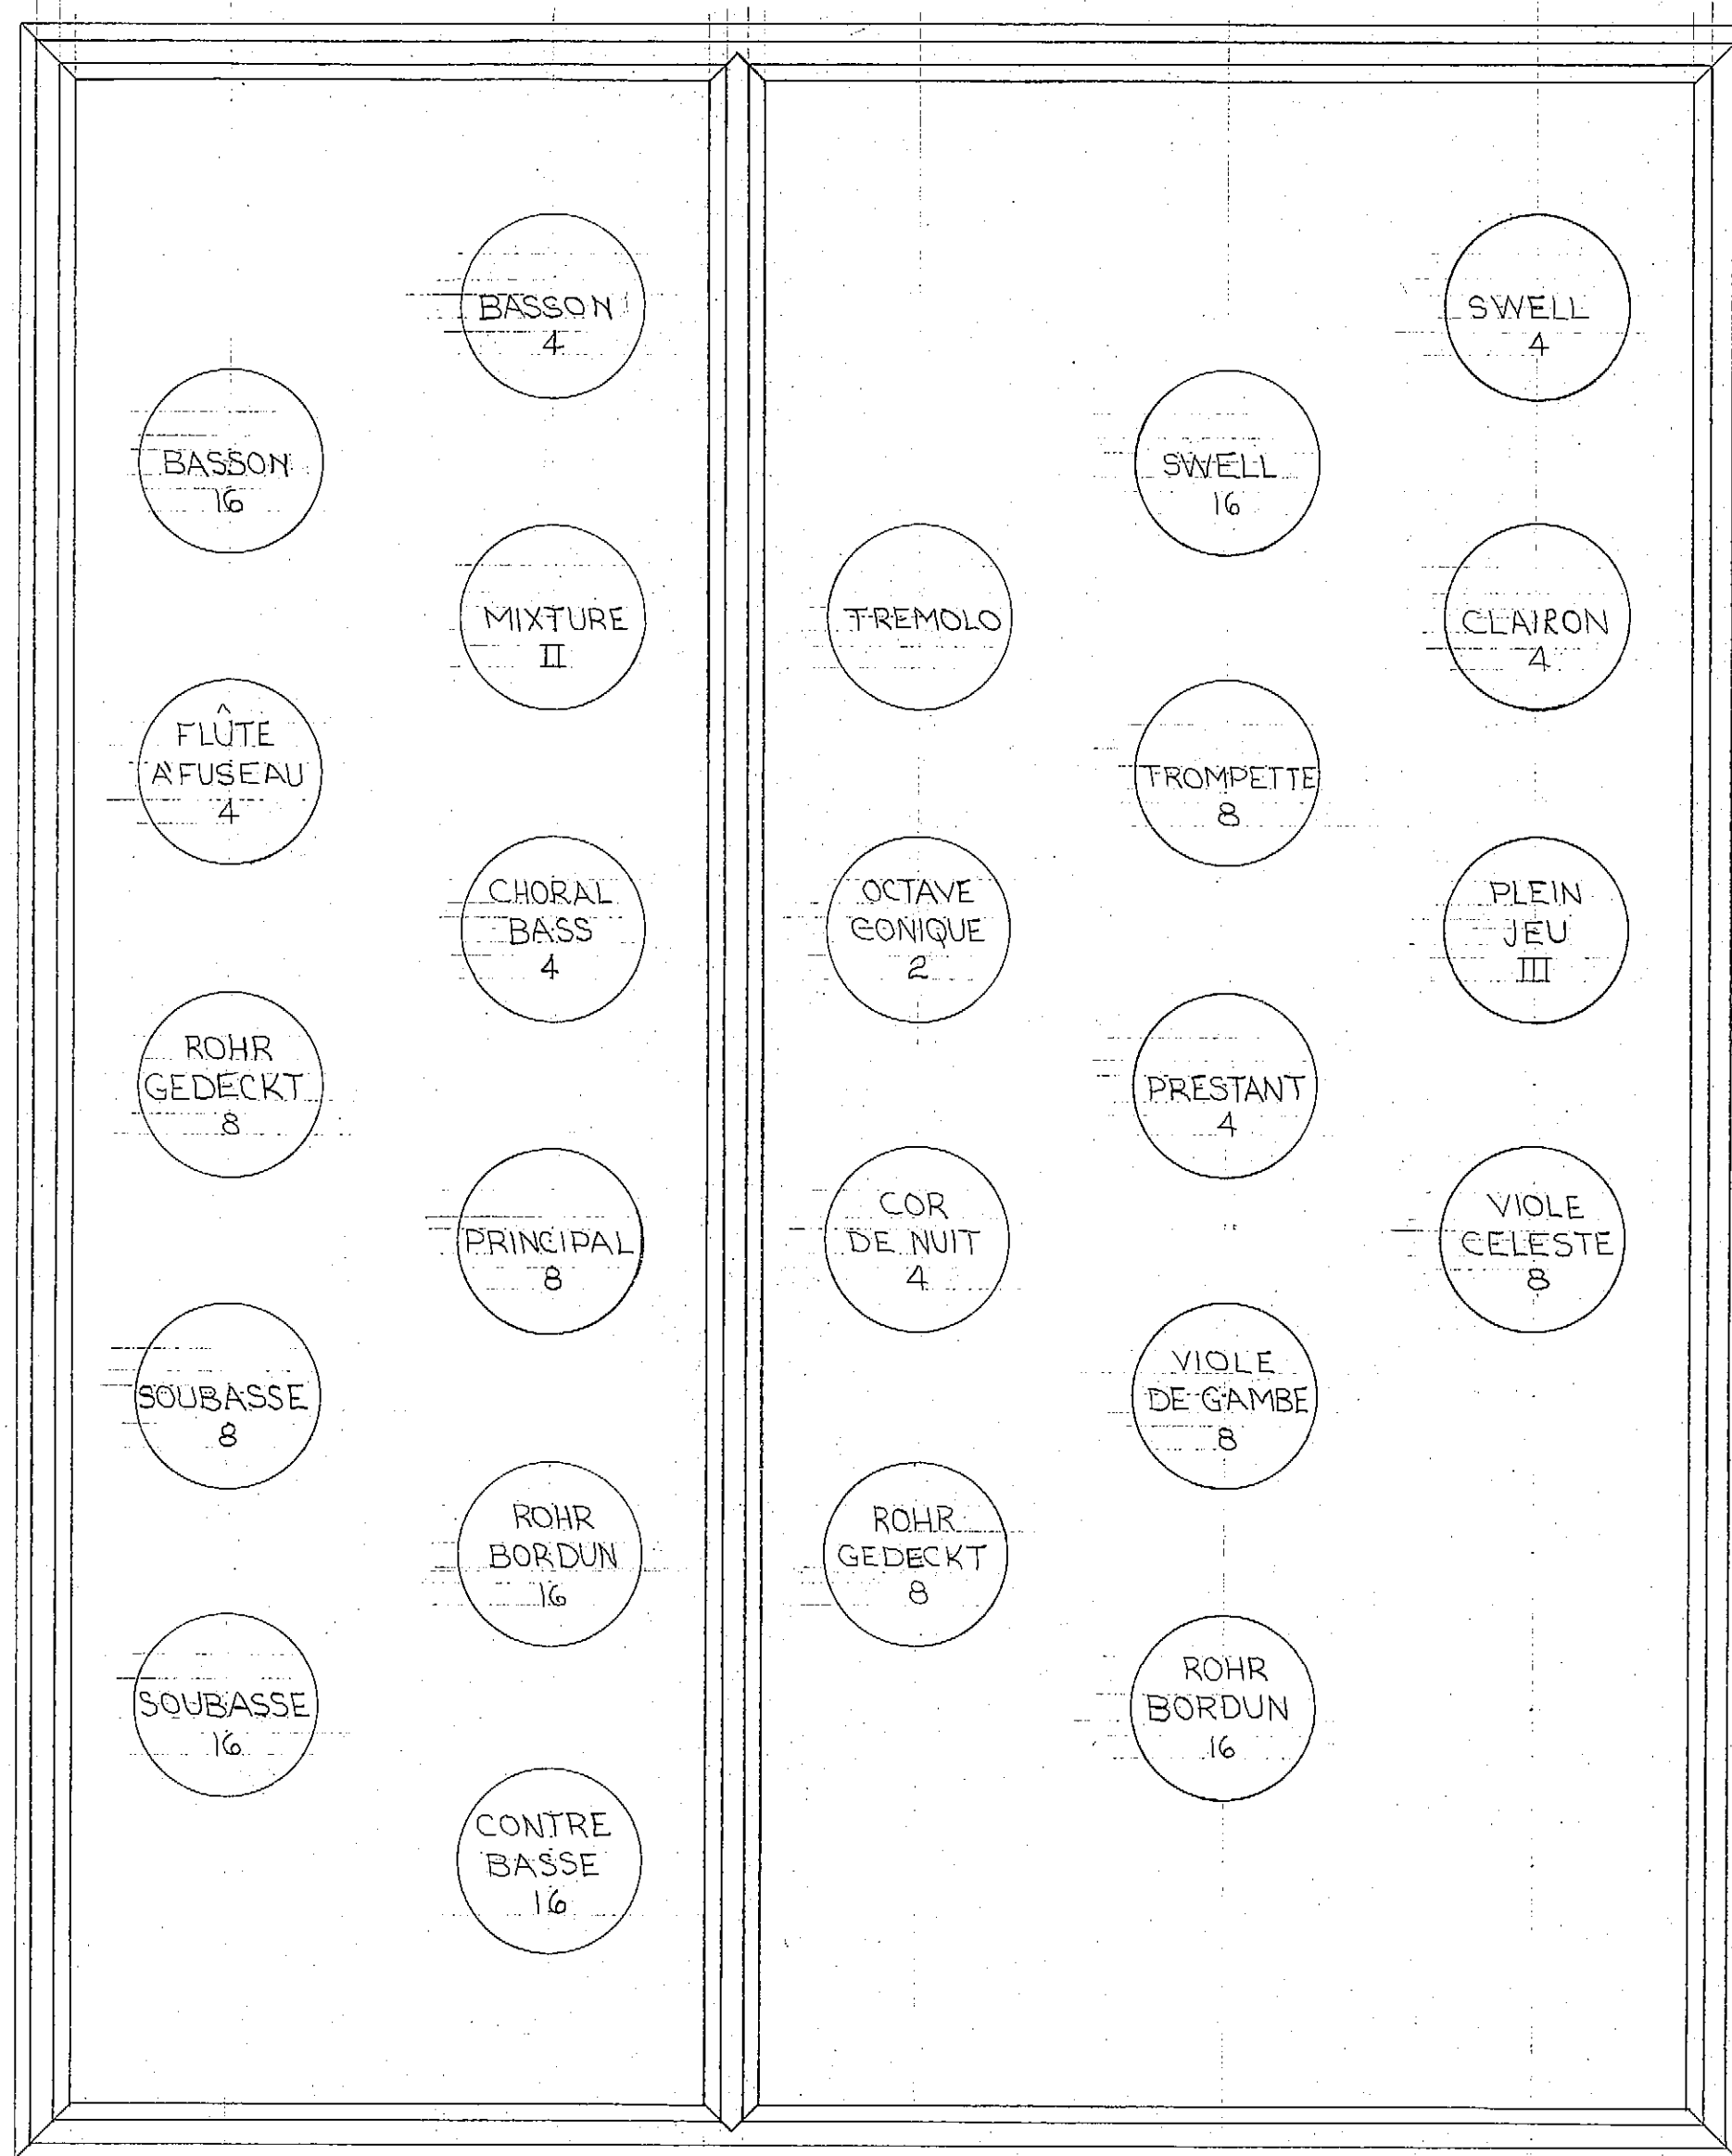


LEFT

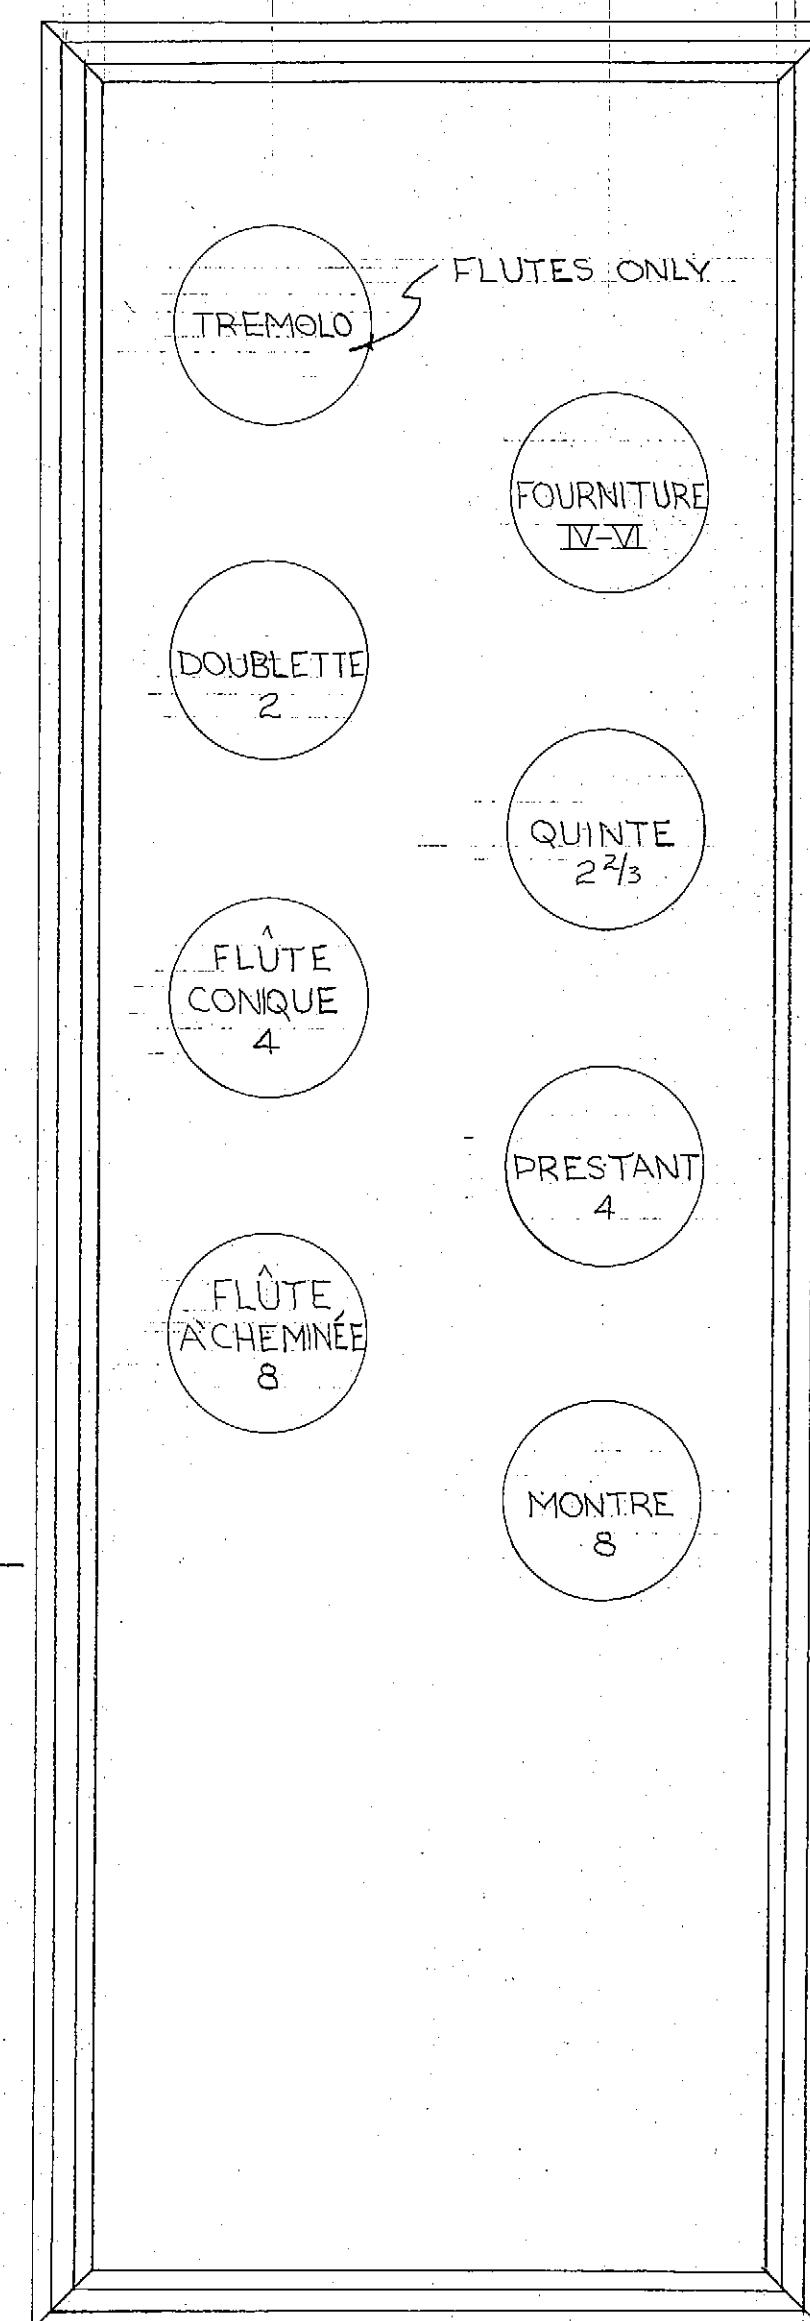

RIGHT

NOTE - ALL ENGRAVING TO BE IN BLACK.
ALL ELECTRIC ACTION.

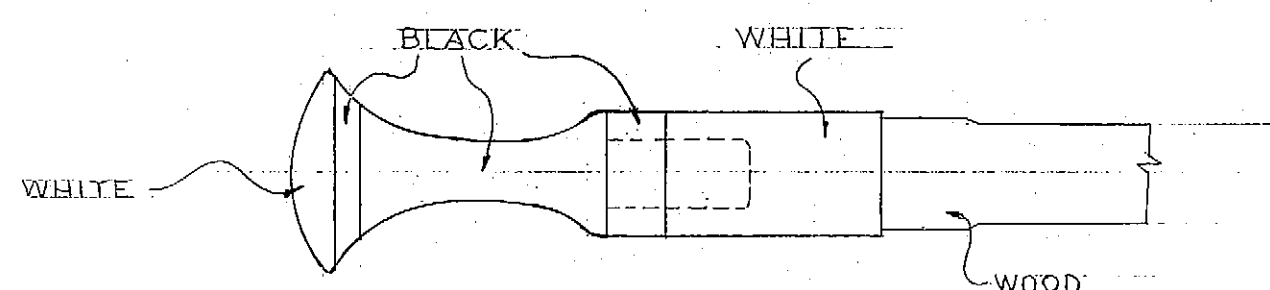

CHANCEL CONSOLE

PURCHASER'S APPROVAL LAURENCE B. HEDGPETH

DATE 6-8-67



MIAMI SHORES PRESBYTERIAN CHURCH,
MIAMI SHORES, FLA.

SCALE - FULL SIZE					
REV.	REV.	REV.	CHK'D	DRAWN	DATE
		7-20-67	LMP	5-22-67	


M.P. MÖLLER, INC.
HAGERSTOWN, MD.

10090
DRAWING NO. 106-B

18
6
12"

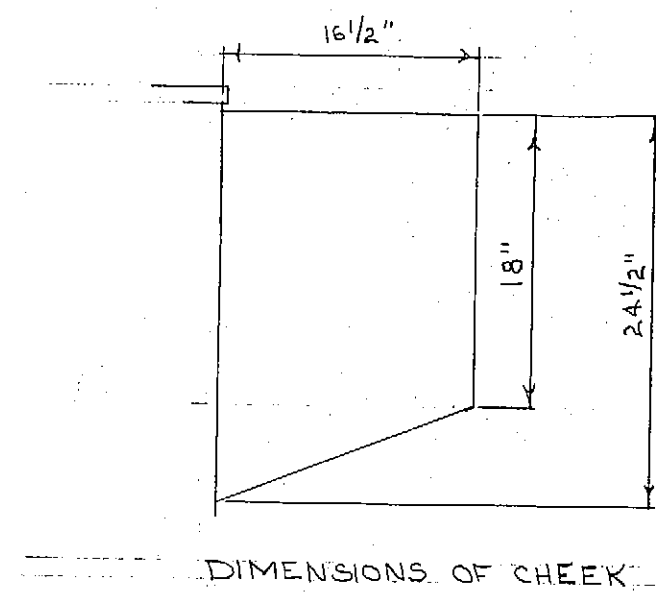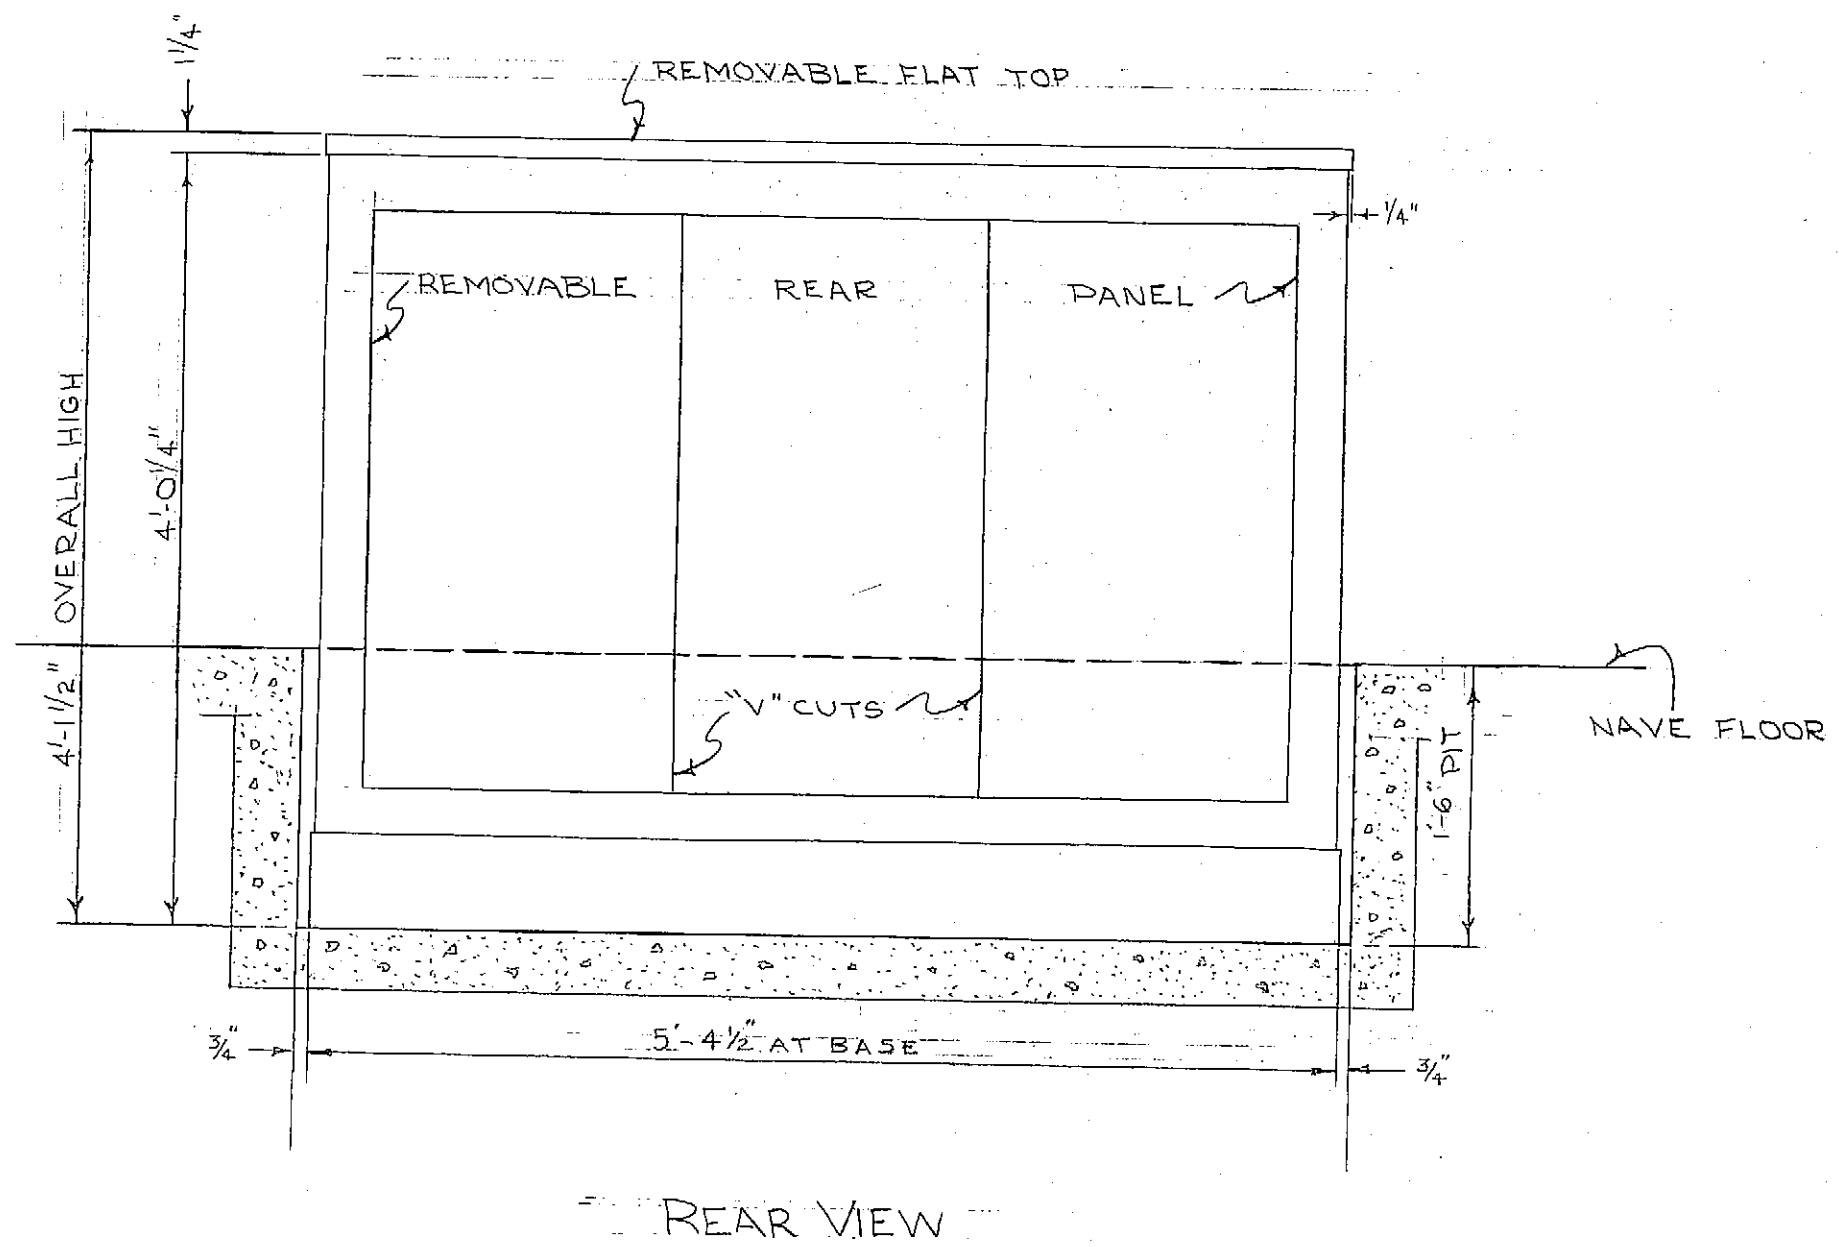

IMPORTANT
CONDUITS FOR ORGAN CABLES TO BE BUSHED
ABOVE FLOOR, LOOP AND FORM ORGAN CABLES
FOR ENTRY IN CONSOLE BASE. CONDUITS FOR
OTHER SERVICES TO EXTEND INTO CONSOLE
WITH FLEXIBLE CONDUITS.

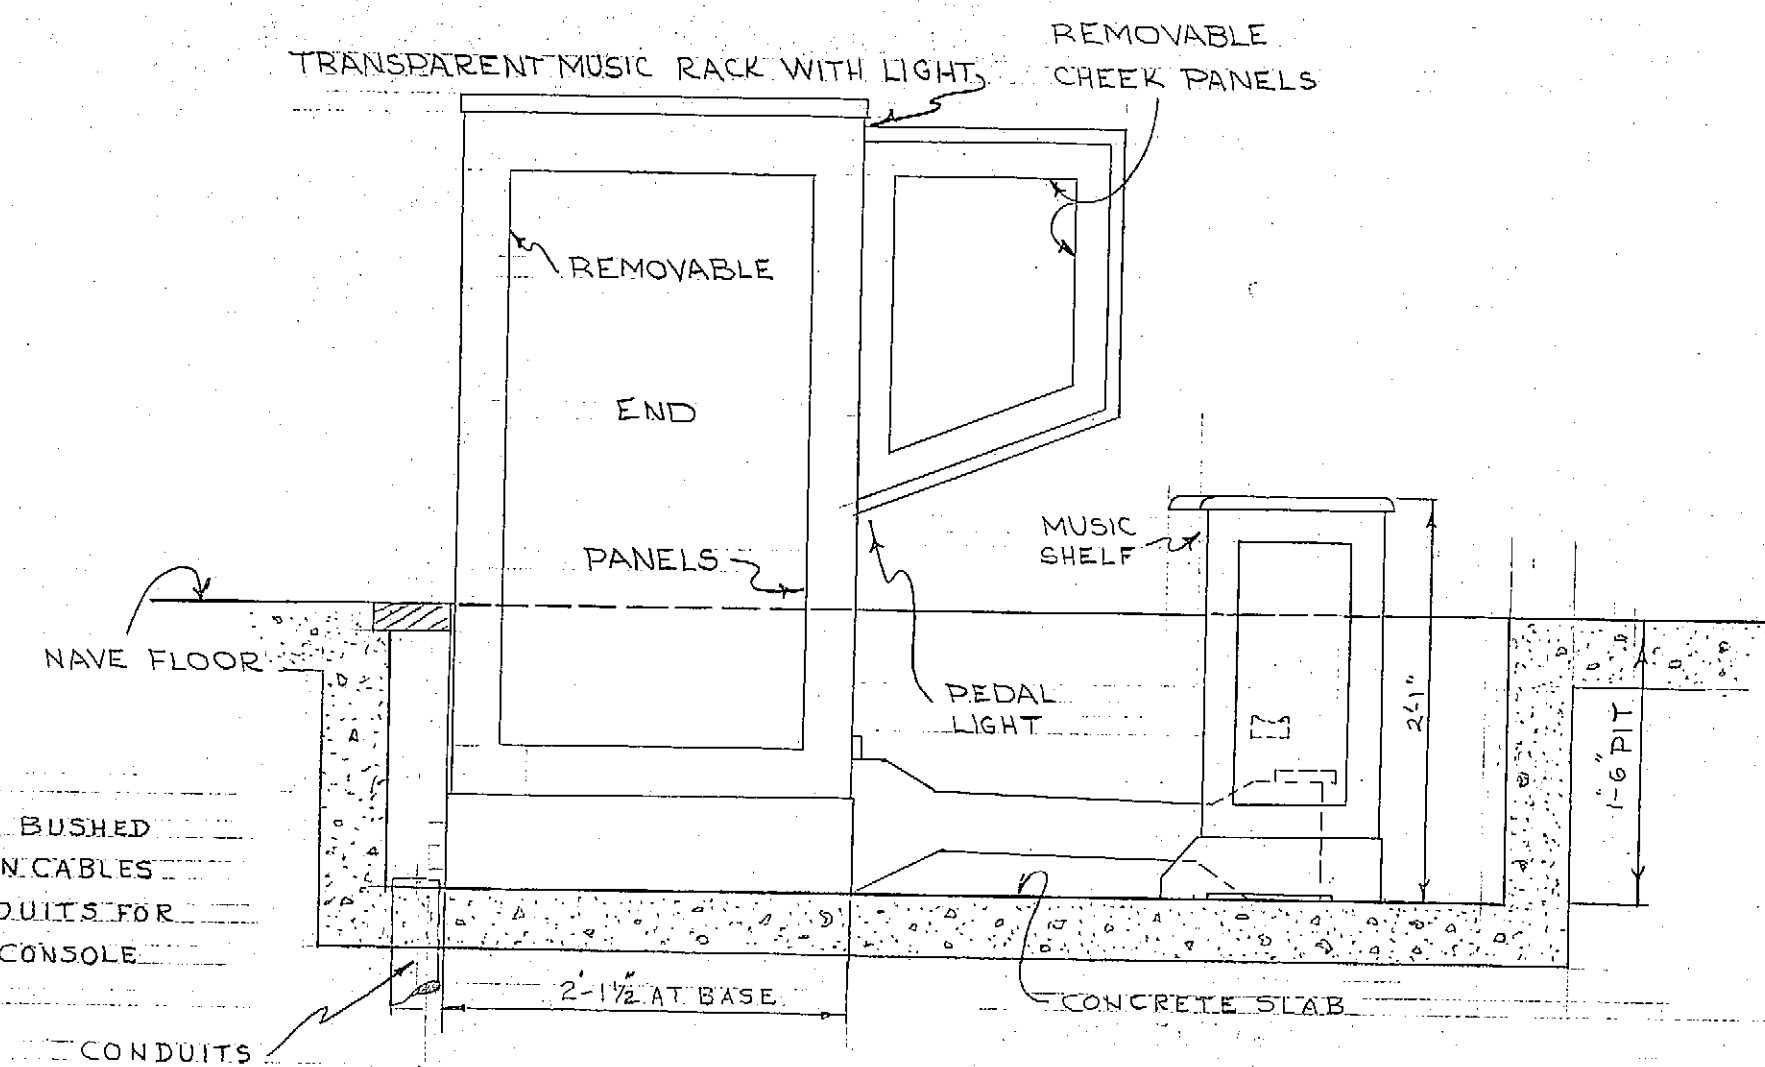

REAR VIEW


END VIEW

- (A) 1/2" Ø EMPTY CONDUIT TO AC CURRENT SOURCE FOR CONSOLE LIGHTING.
- (B) 3/4" Ø EMPTY CONDUIT TO NARTHEX FOR SIGNAL SYSTEM.
- (C) 2" Ø EMPTY CONDUIT TO MAIN CONSOLE FOR CABLES & ACTION CURRENT WIRES.
- (D) 3/4" Ø EMPTY CONDUIT TO BLOWER ROOM FOR MOTOR STARTER WIRES.
- (E) 2 1/2" Ø EMPTY CONDUIT TO RIGHT ORGAN SPACE FOR CABLES & ACTION CURRENT WIRES.
- (F) 2 1/2" Ø EMPTY CONDUIT TO LEFT ORGAN SPACE FOR CABLES & ACTION CURRENT WIRES.
- (G) 1/2" Ø EMPTY CONDUIT TO PULPIT FOR SIGNAL SYSTEM.


IMPORTANT TO CHECK

OVERALL DEPTH OF CONSOLE IS 3'-6". ARE DOORS THRU WHICH CONSOLE MUST
PASS SUFFICIENTLY WIDE TO PERMIT PLACEMENT OF CONSOLE IN BUILDING?

CONSOLE	DETACHED TYPE-ROLL TOP.
CABINET DESIGN	PLAIN-FLUSH PANELS.
CABINET WOOD	EXTERIOR-WALNUT.
	INTERIOR-WALNUT
CABINET FINISH	EXTERIOR-TO COLOR BLOCK SUBMITTED (DARK FINISH).
	INTERIOR-TO COLOR BLOCK SUBMITTED (LIGHT FINISH).
MANUALS	TWO 1/4 PEDAL (LEVEL MANUALS).
MANUAL KEYBOARDS	CC TO C4, 61 NOTES.
PEDAL KEYBOARD	CCC TO G, 32 NOTES.
STOP CONTROLS	DRAW KNOBS & TILTING TABLETS.
ACTION	ALL ELECTRIC, MULTIPLE CONTACTS & SWITCHES FOR COUPLERS.
ACTION REQUIREMENTS	10-15 VOLTS, 50 AMPERES.

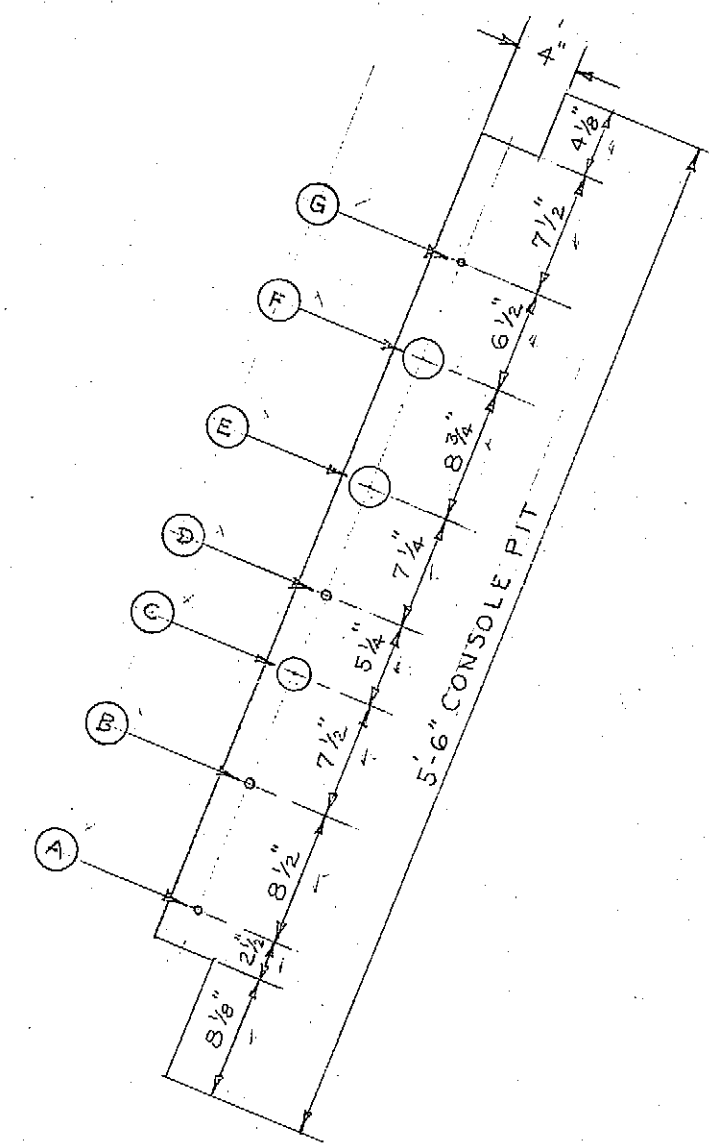


CONDUIT LOCATIONS

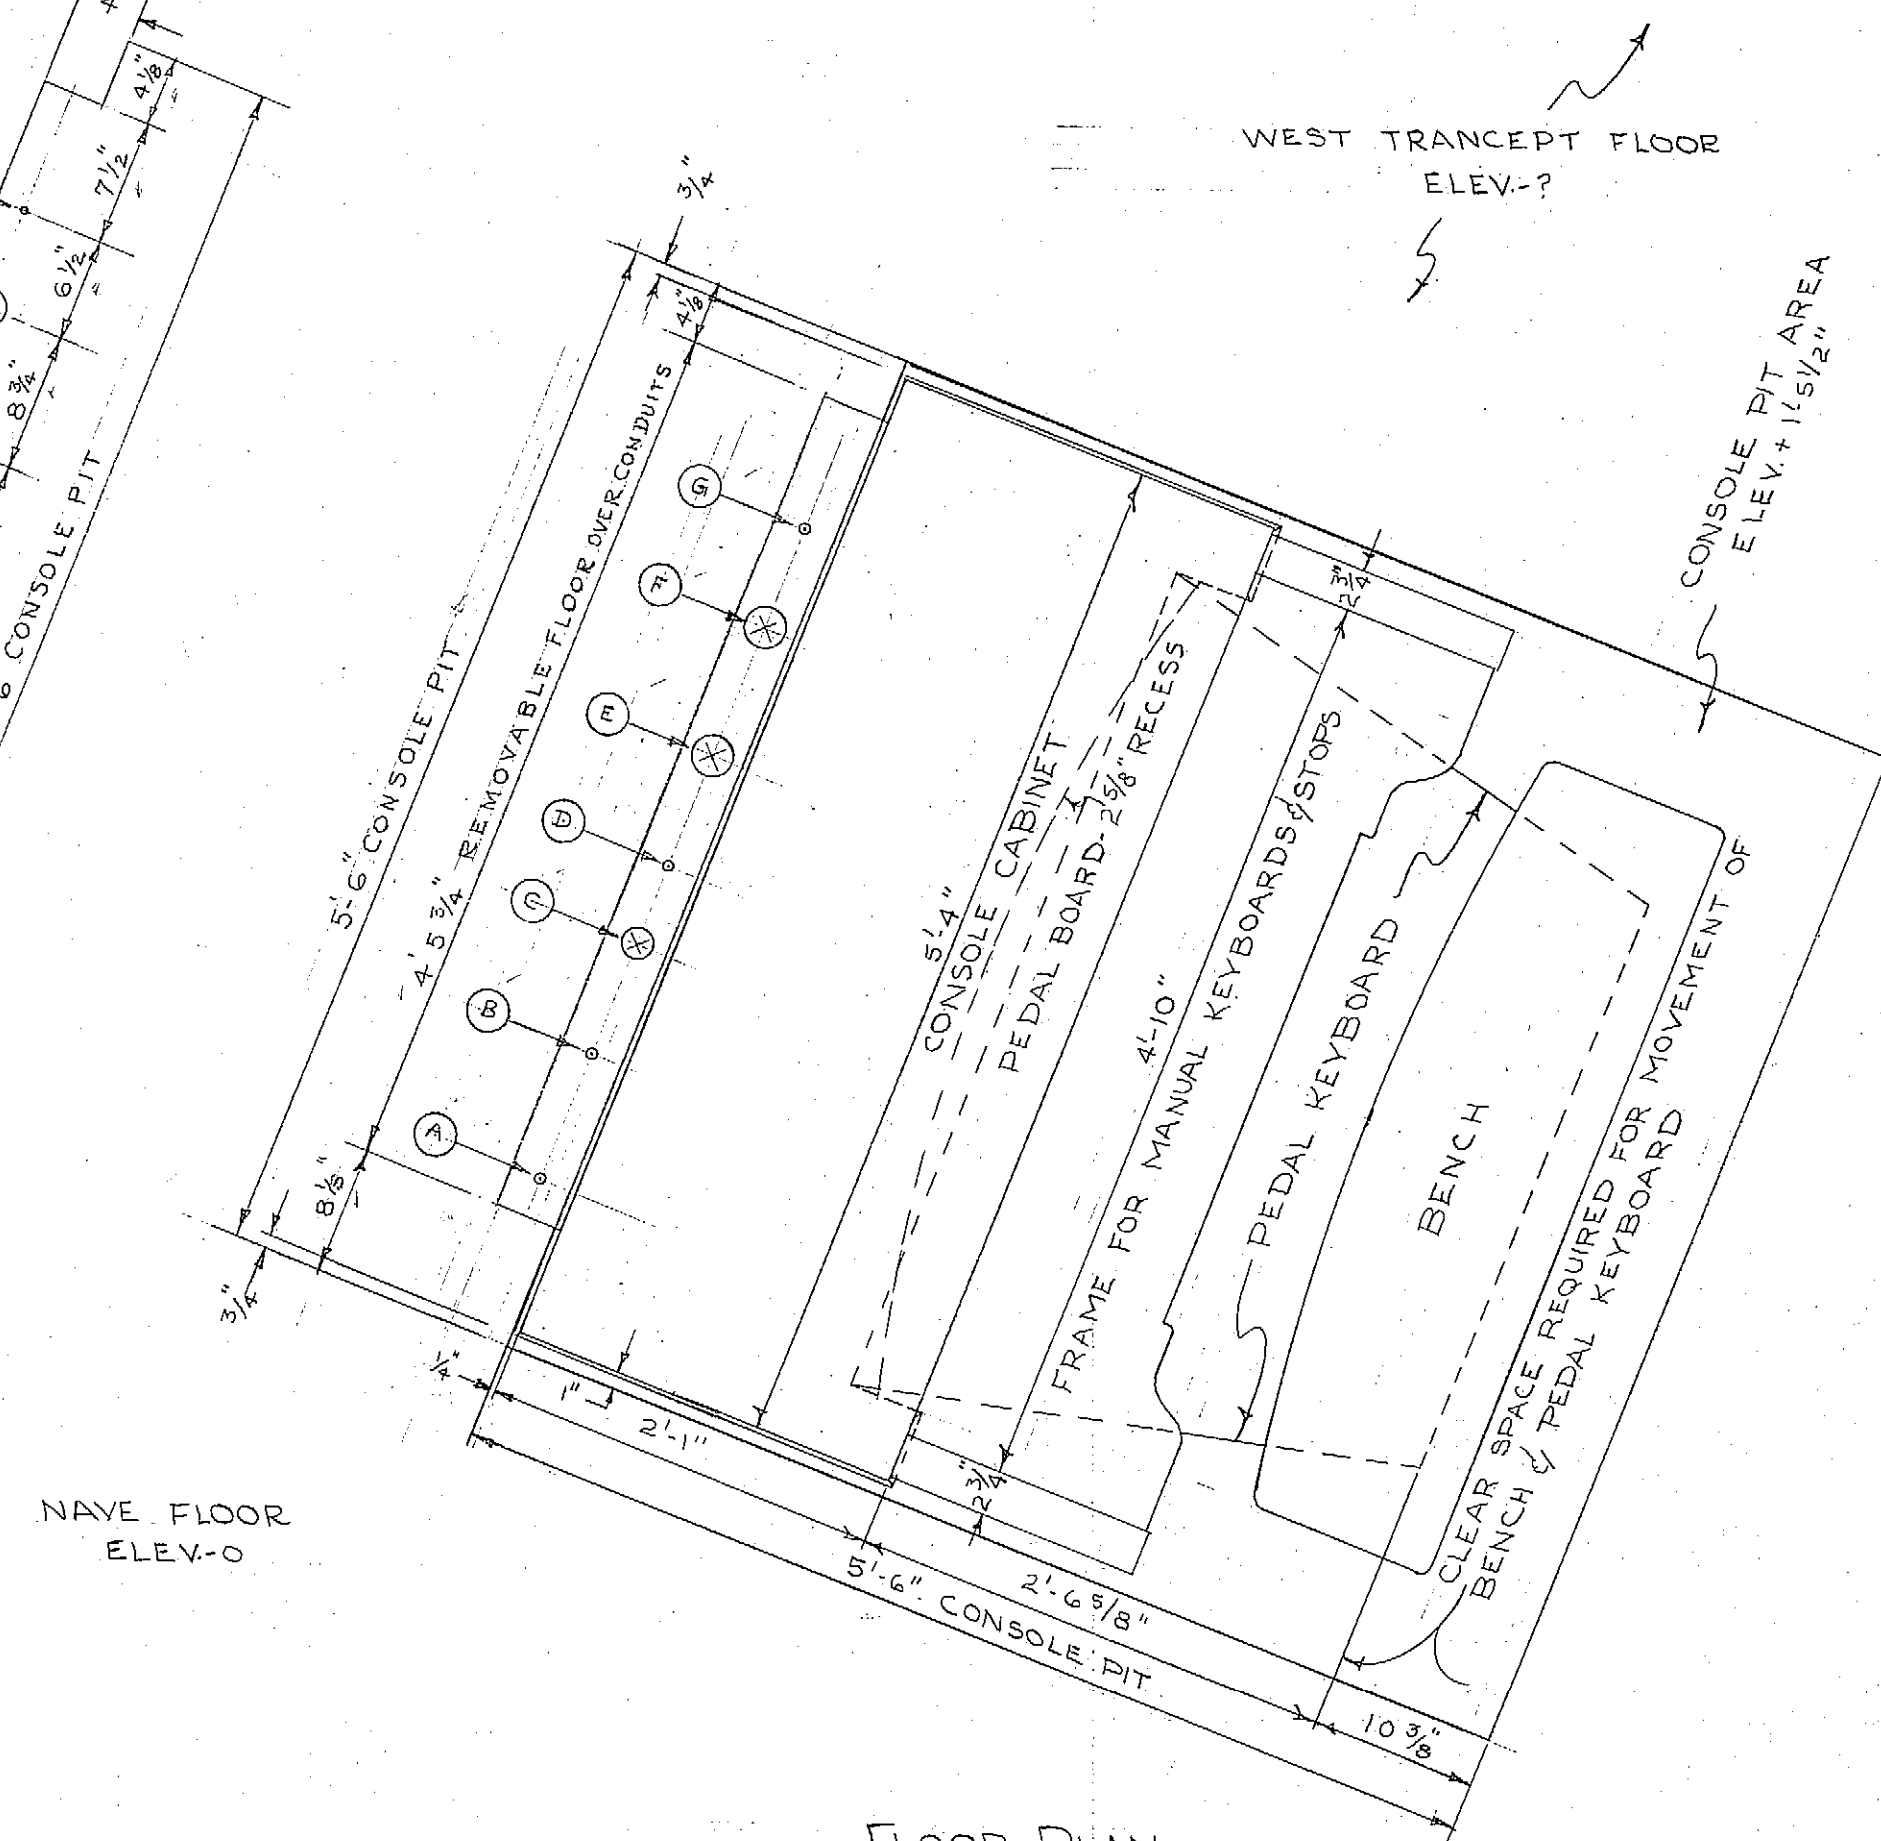


FLOOR PLAN

CHANCEL CONSOLE


DIMENSIONS OK BY OSCAR MARTEL					DATE 11-23-67	
PURCHASER'S APPROVAL OF DESIGN L.B. HEDGPETH					DATE 11-23-67	
MIAMI SHORES PRESBYTERIAN CHURCH, MIAMI SHORES, FLA.						
SCALE: 1"=1'-0"					M.P. MÖLLER, INC., HAGERSTOWN, MD.	
REV.	REV.	REV.	CH'K'D	DRAWN	DATE	10090
		11-29-67	C	LMP	5-22-67	DRAWING NO. 107

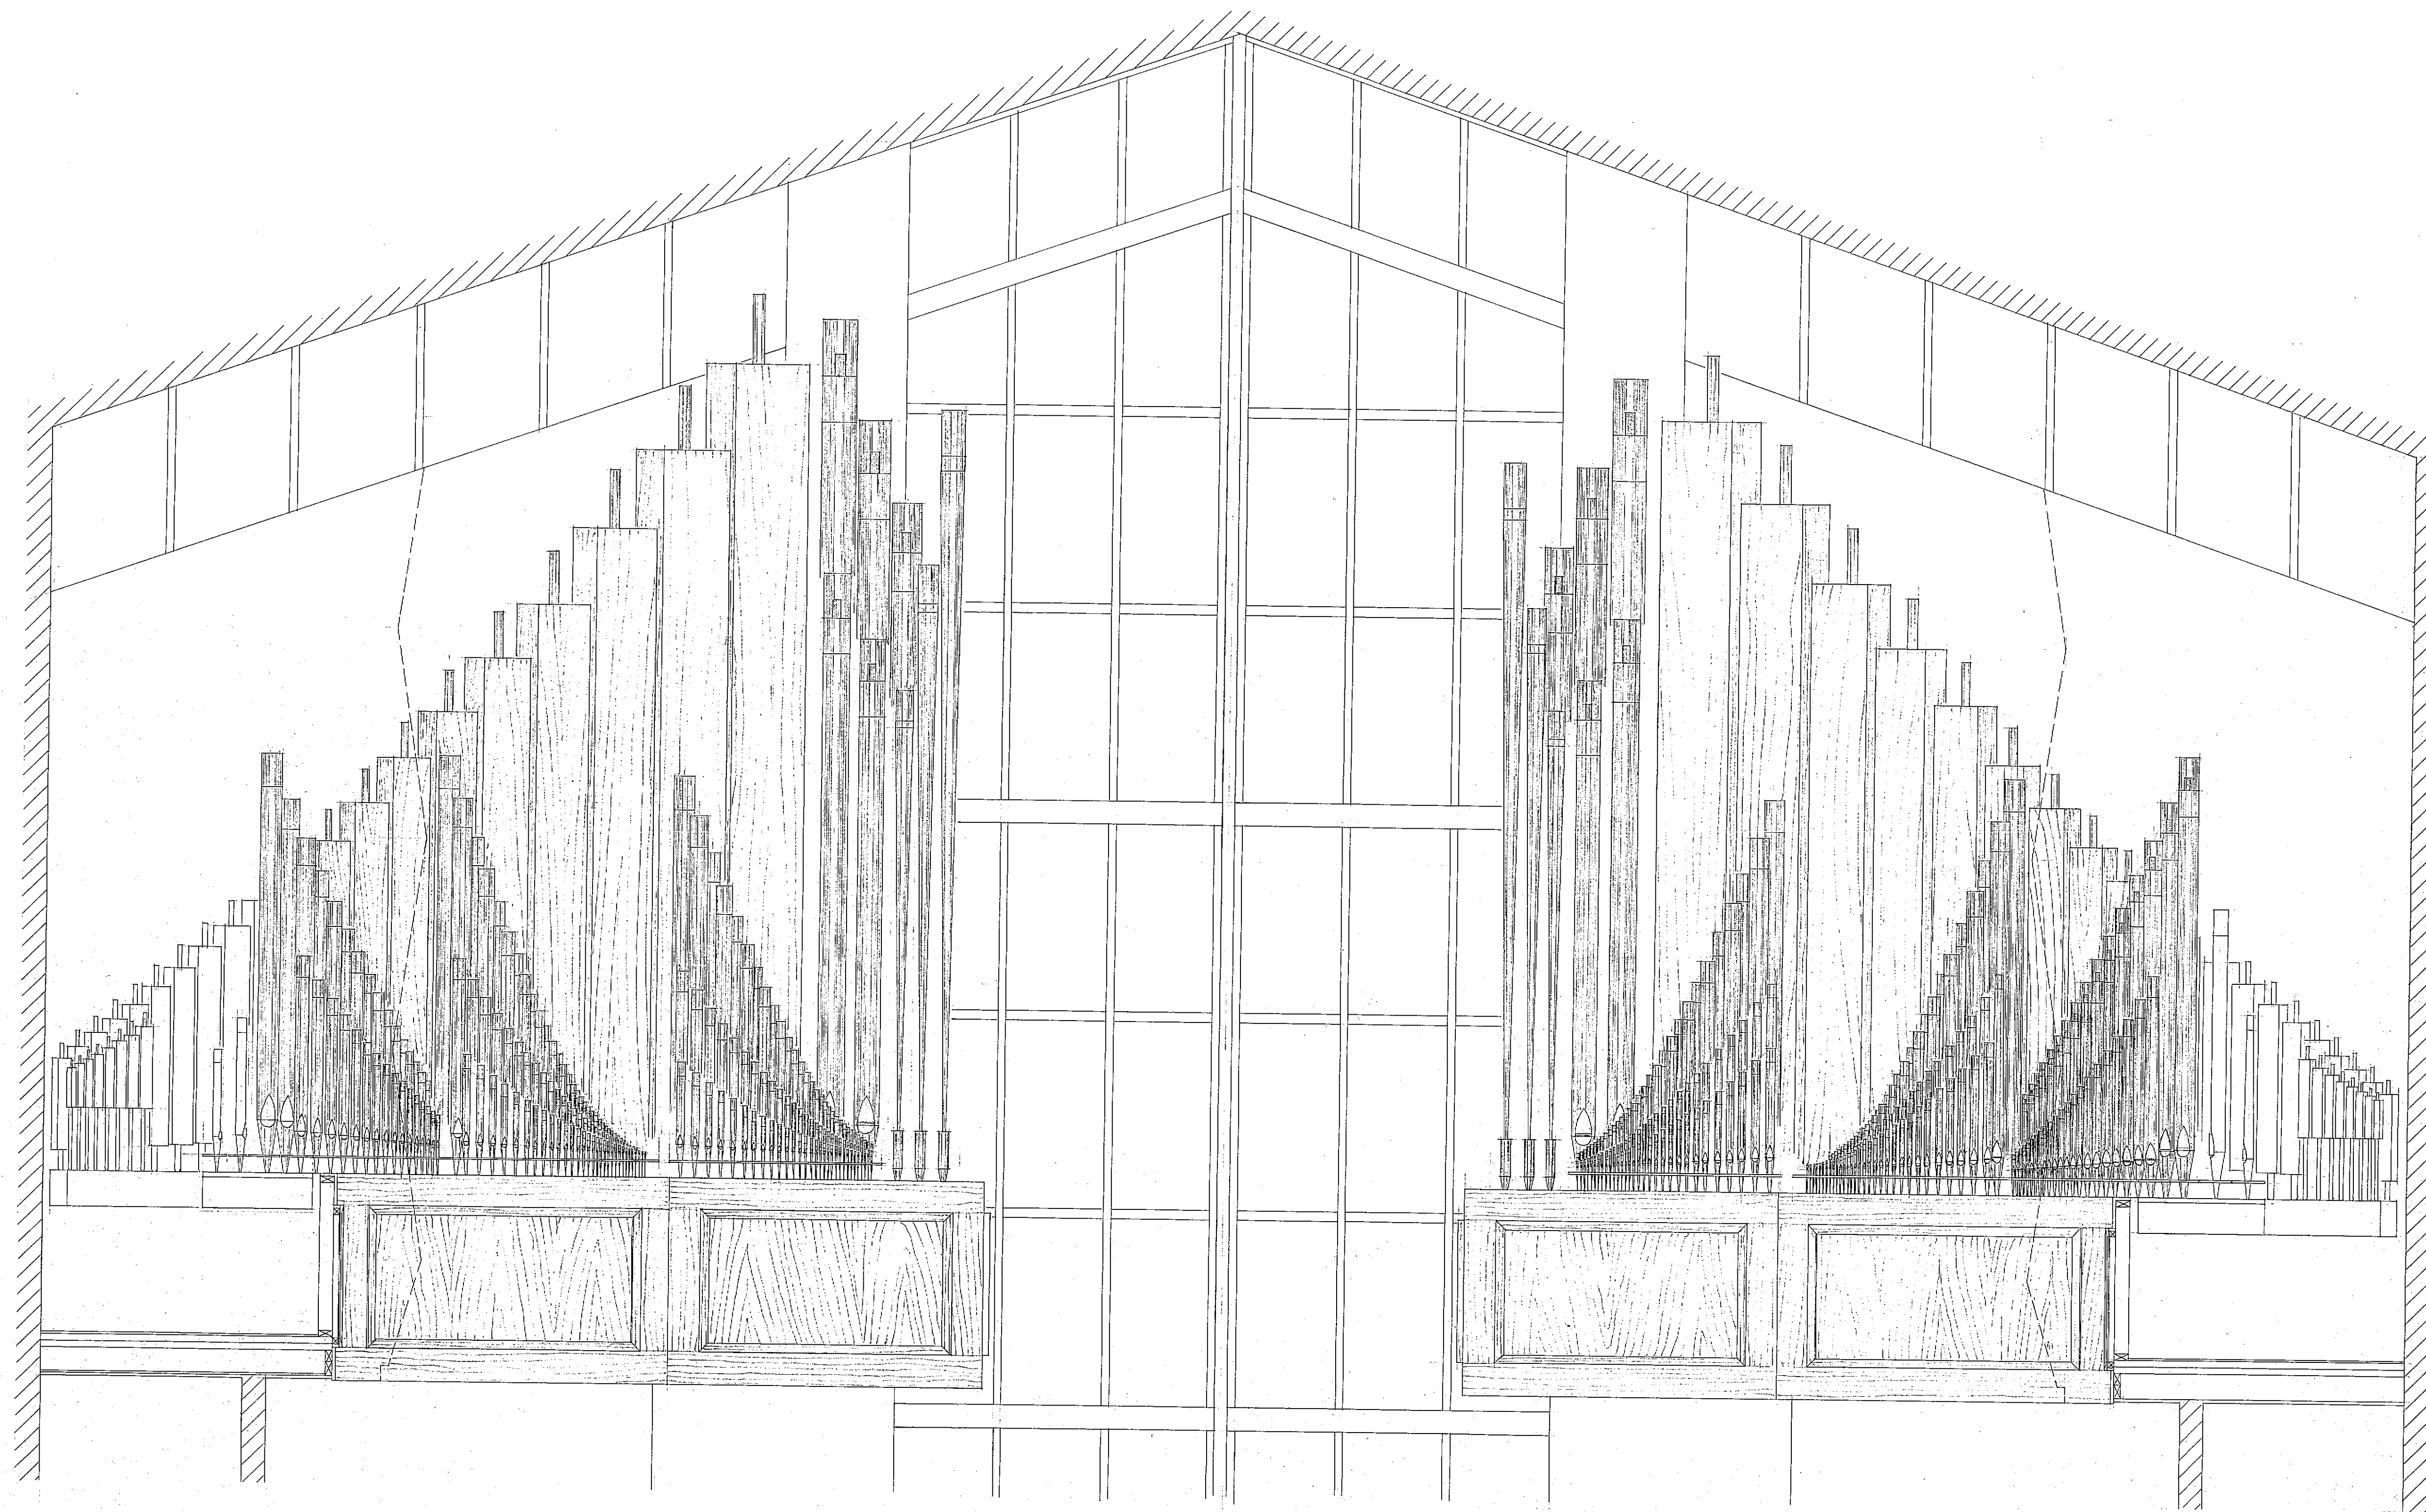

• FRONT ELEVATION •

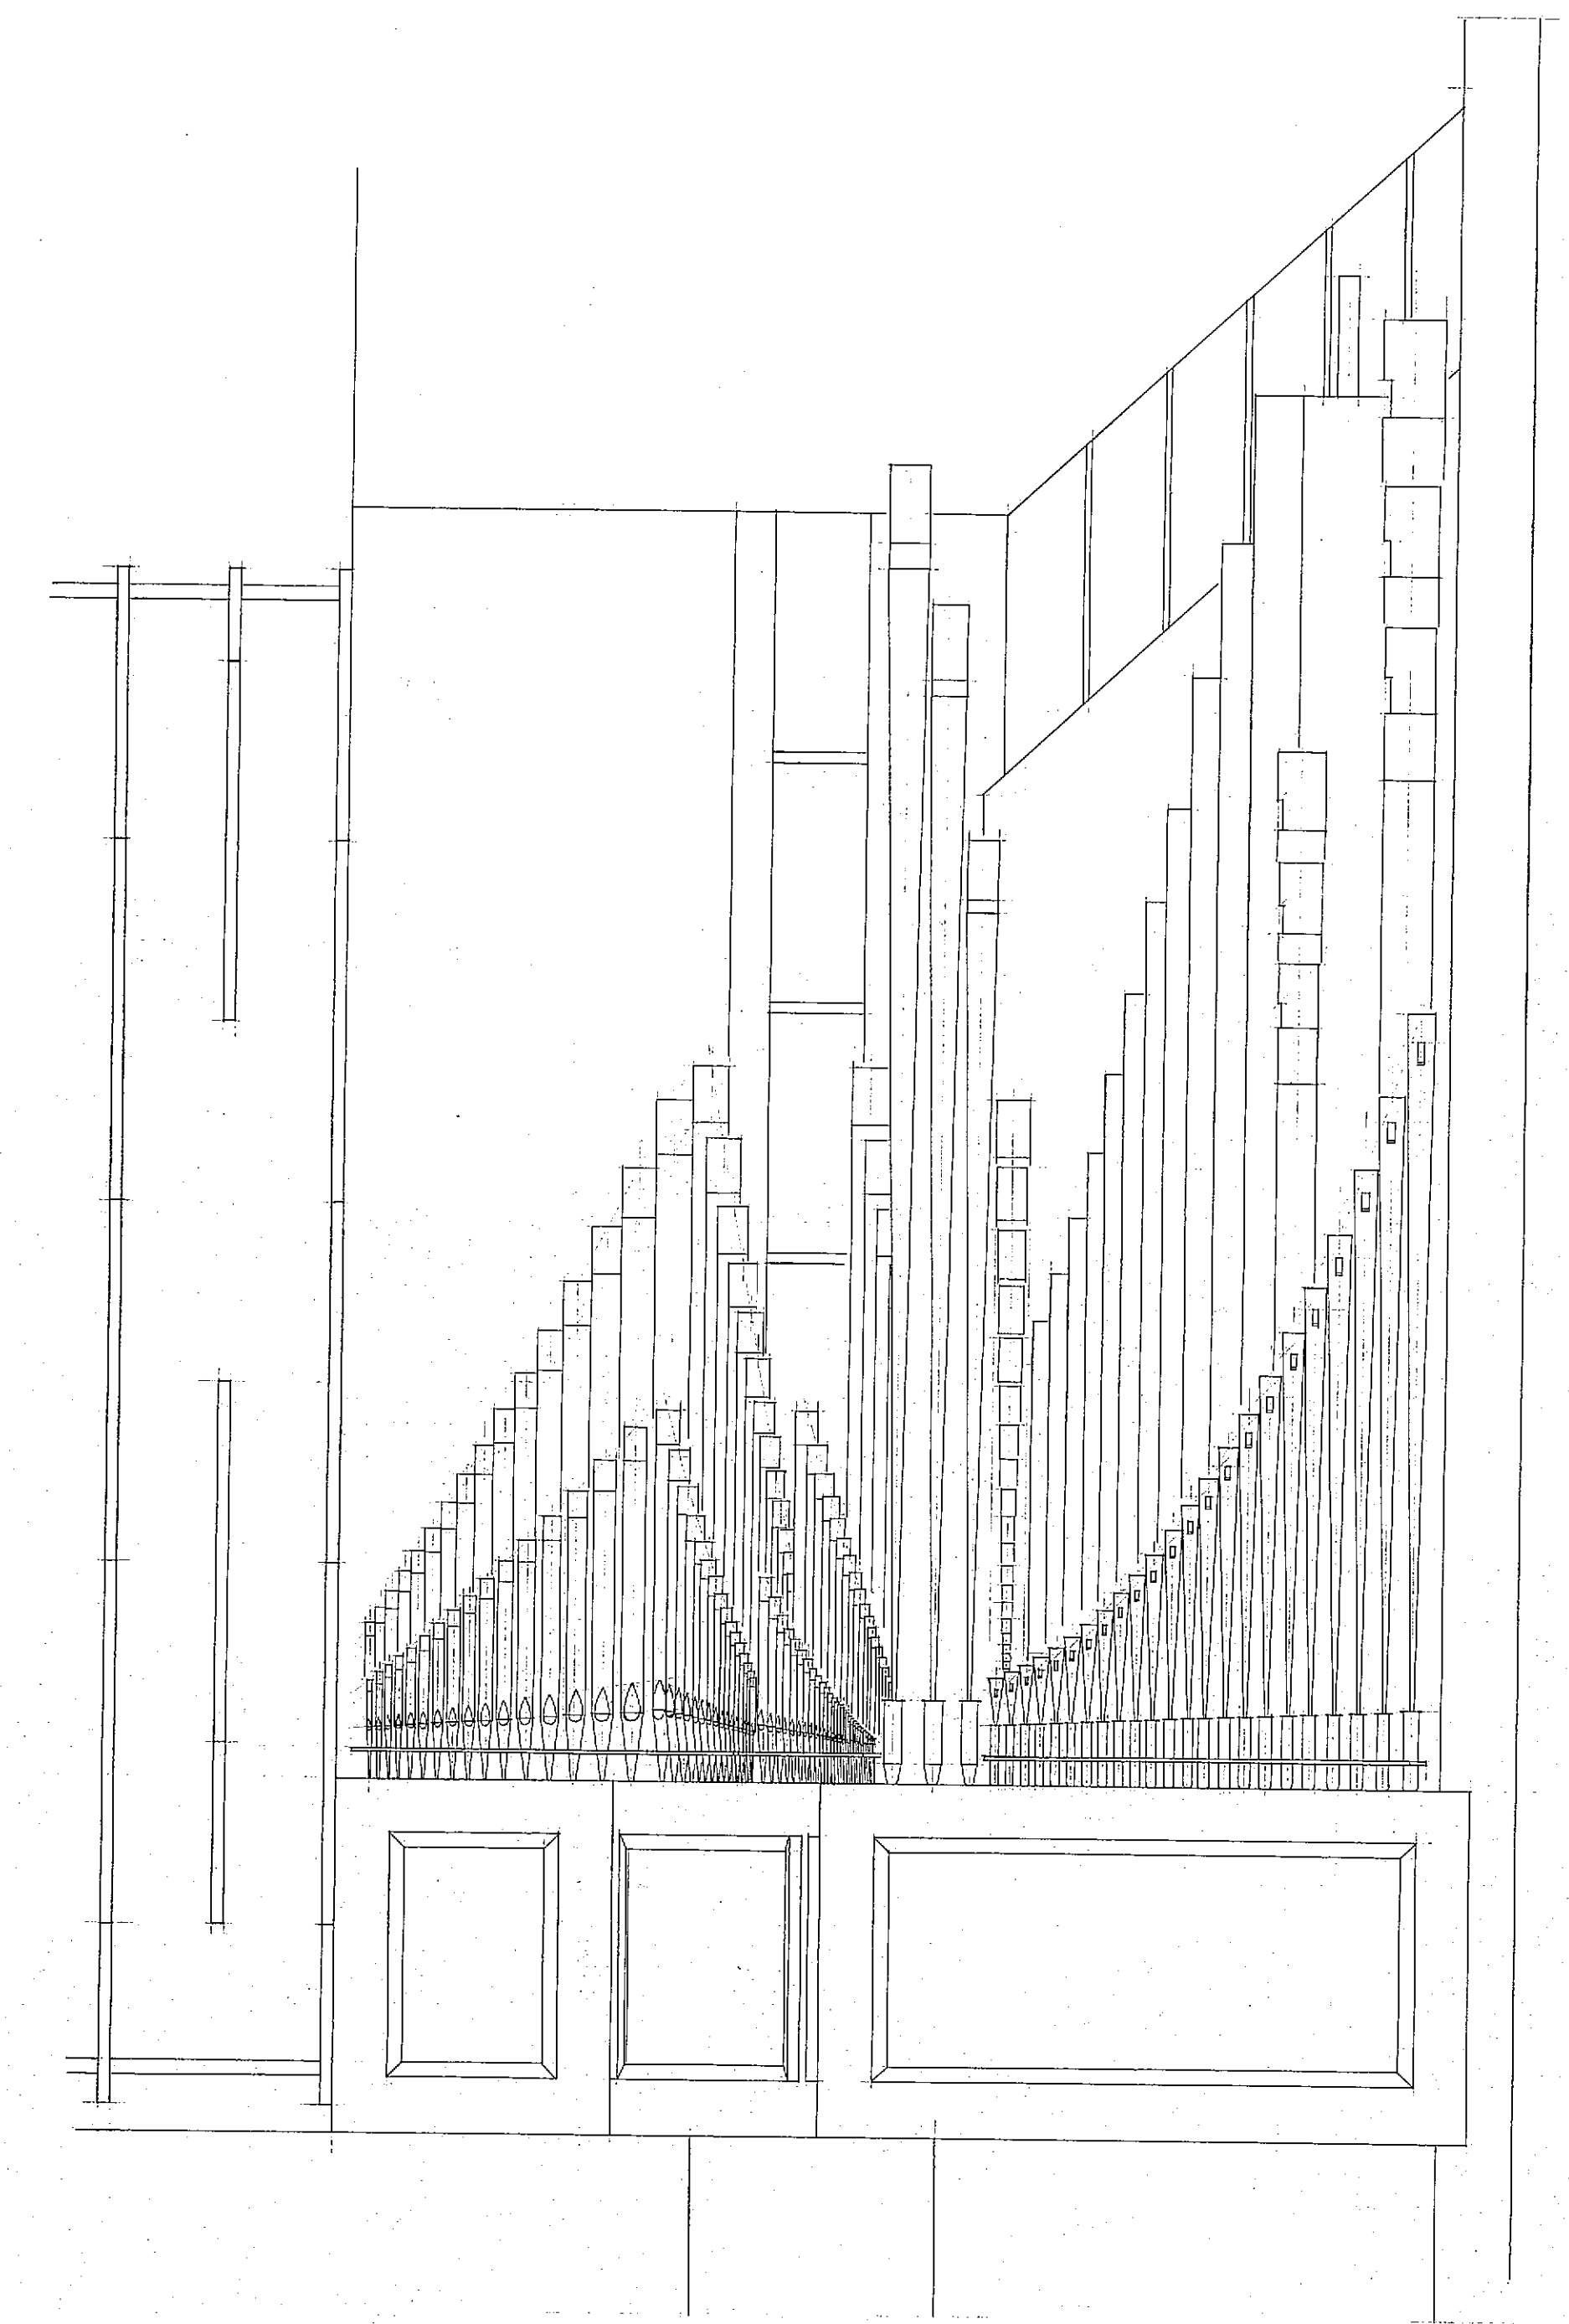


• SIDE ELEVATION •

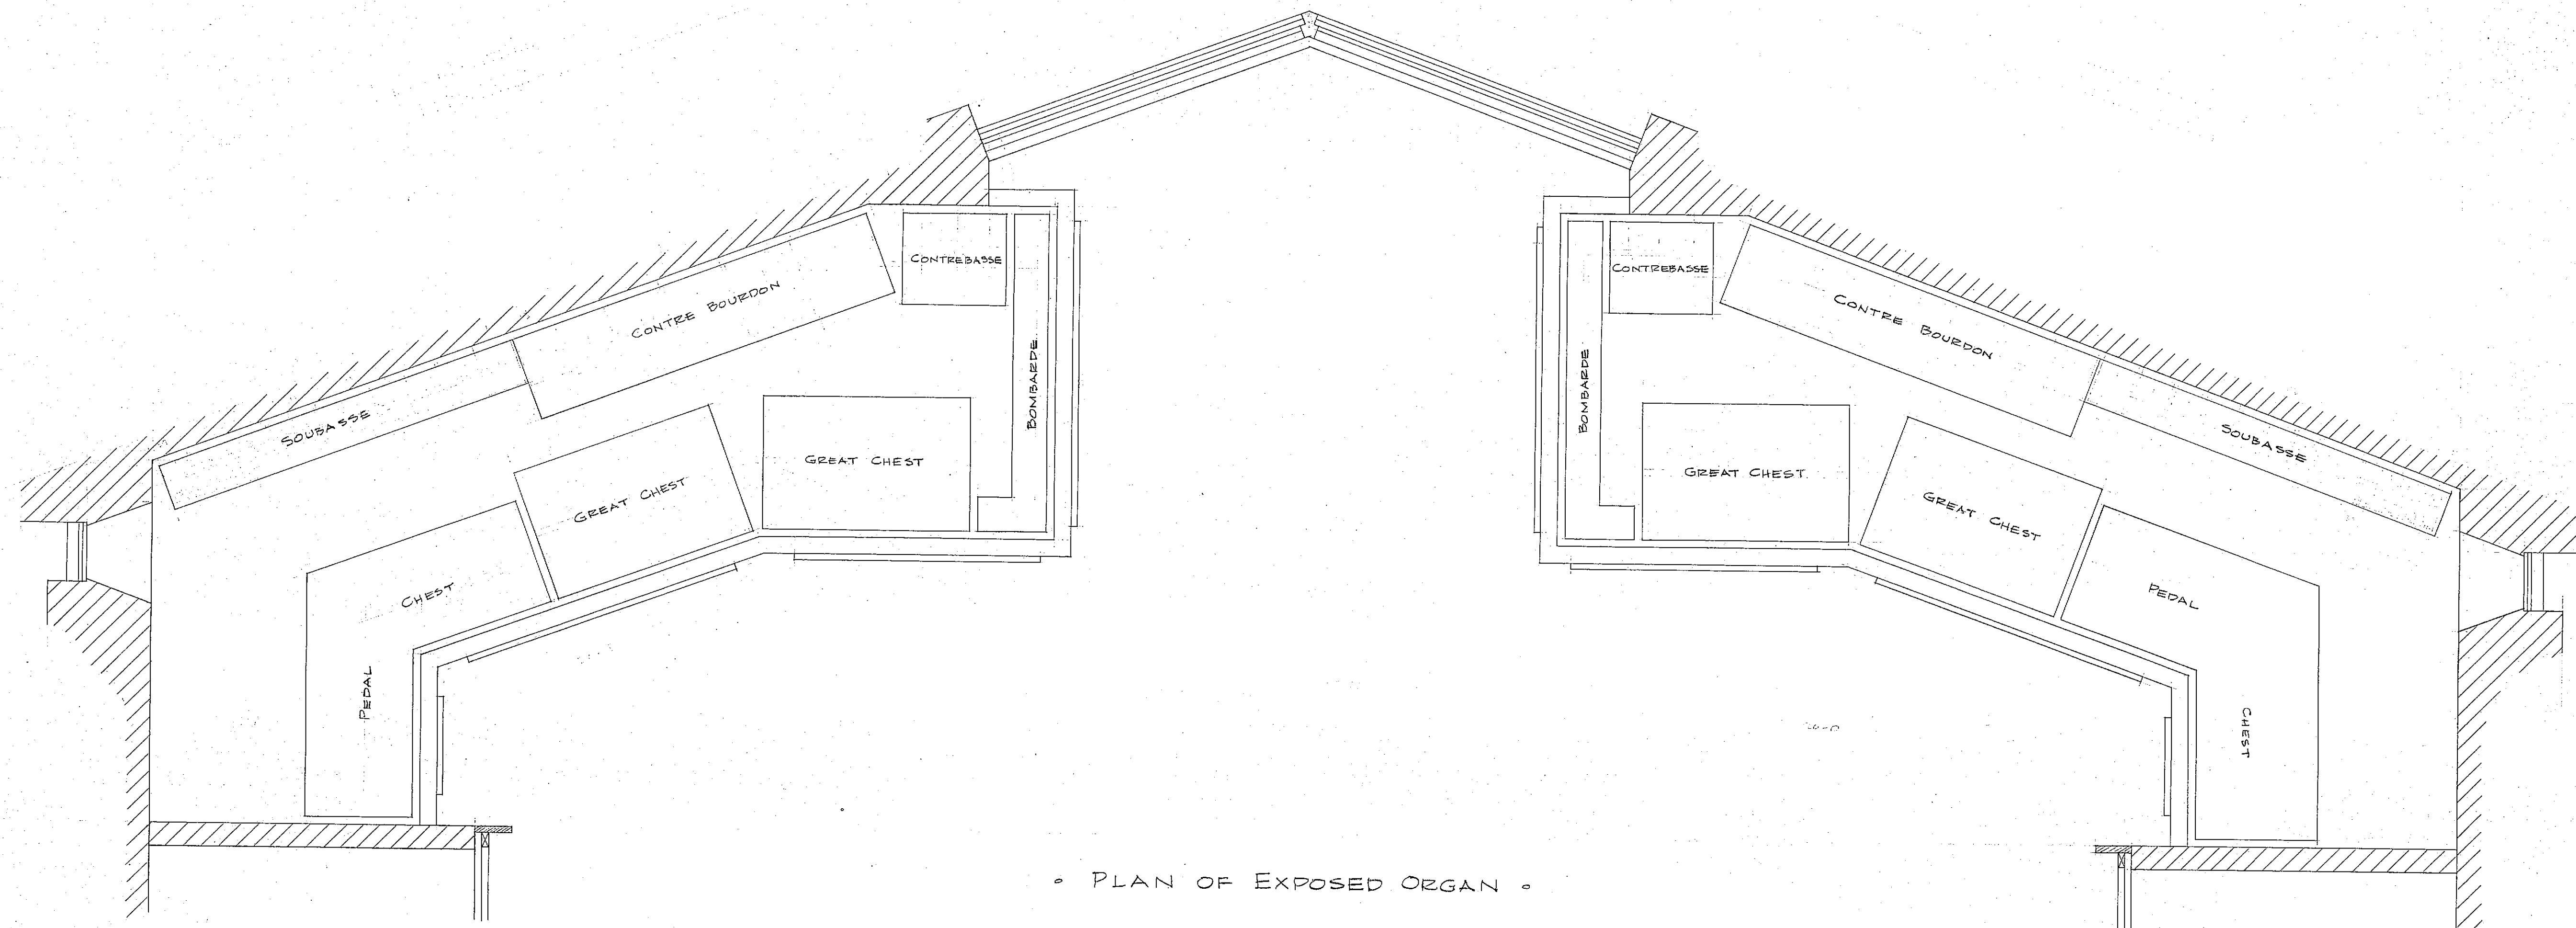


• PLAN OF EXPOSED ORGAN •

EXPOSED PIPES - NATURAL METALS & WOOD


APPROVED				DATE			
MIAMI SHORES PRESBYTERIAN CHURCH, MIAMI SHORES, FLORIDA							
SCALE: $\frac{1}{2}" = 1'-0"$				M. P. MÖLLER, INC., HAGERSTOWN, MD.		10090	
		DATE DRAWN 9-19-47	BY SVK			DRAWING NO. 108	

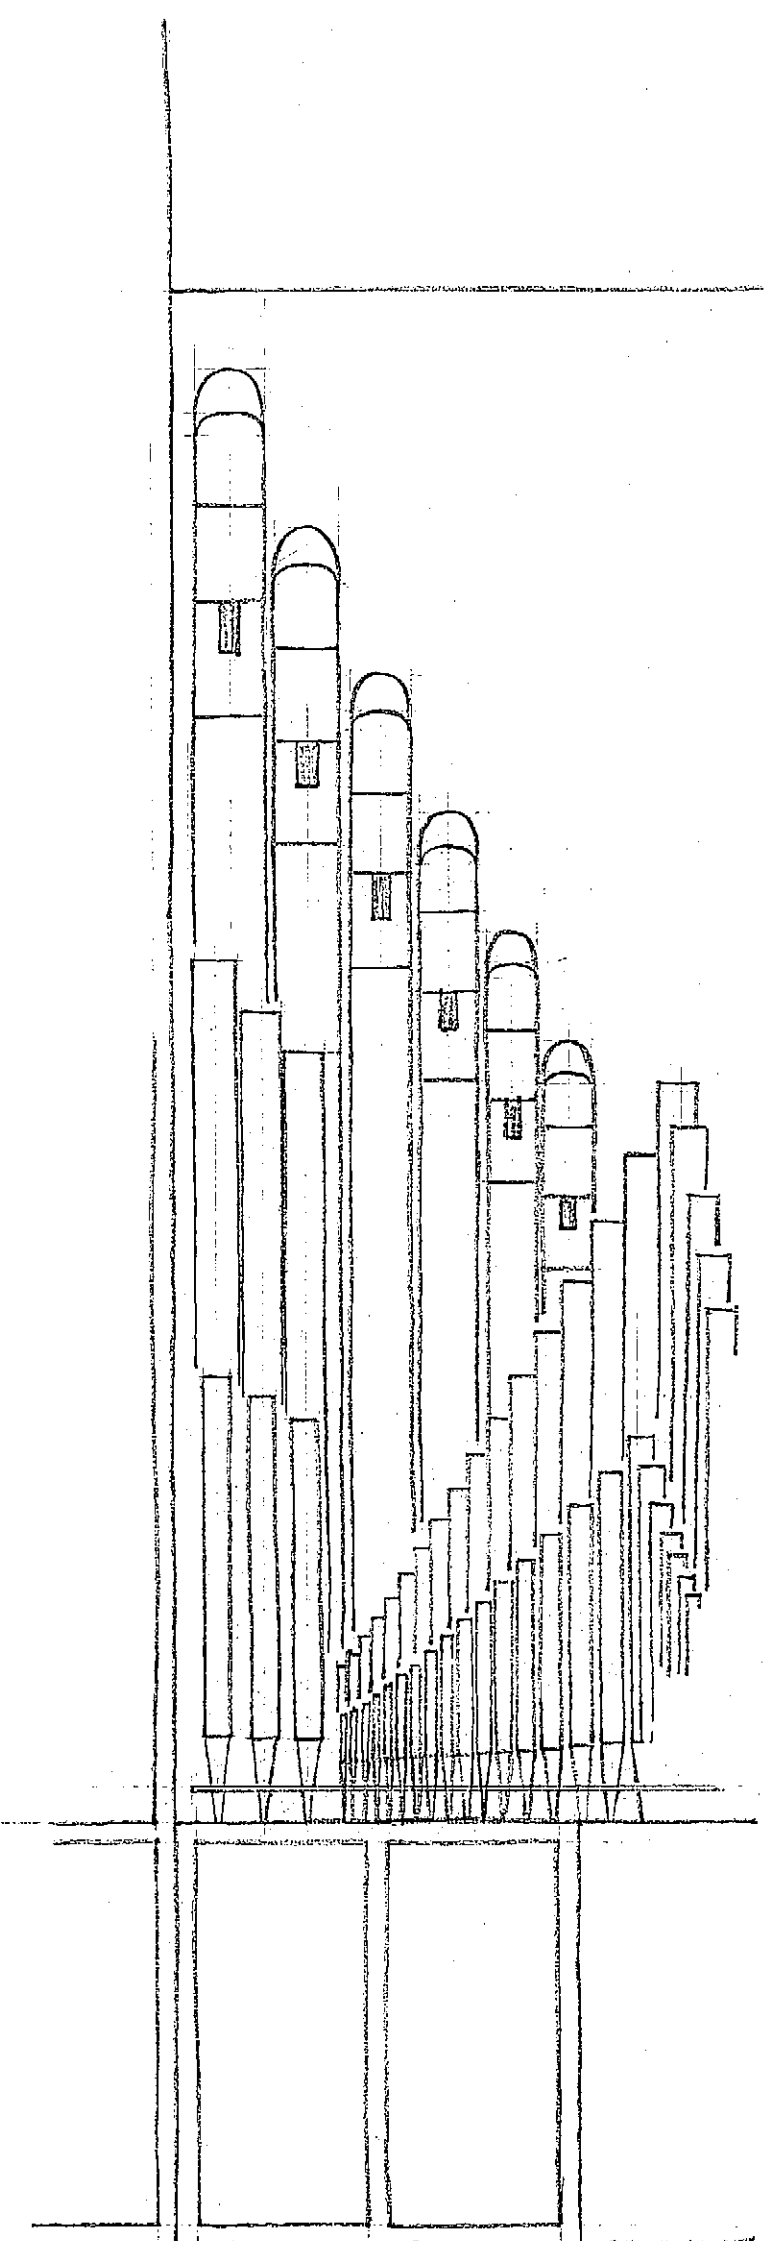

• SIDE ELEVATION •

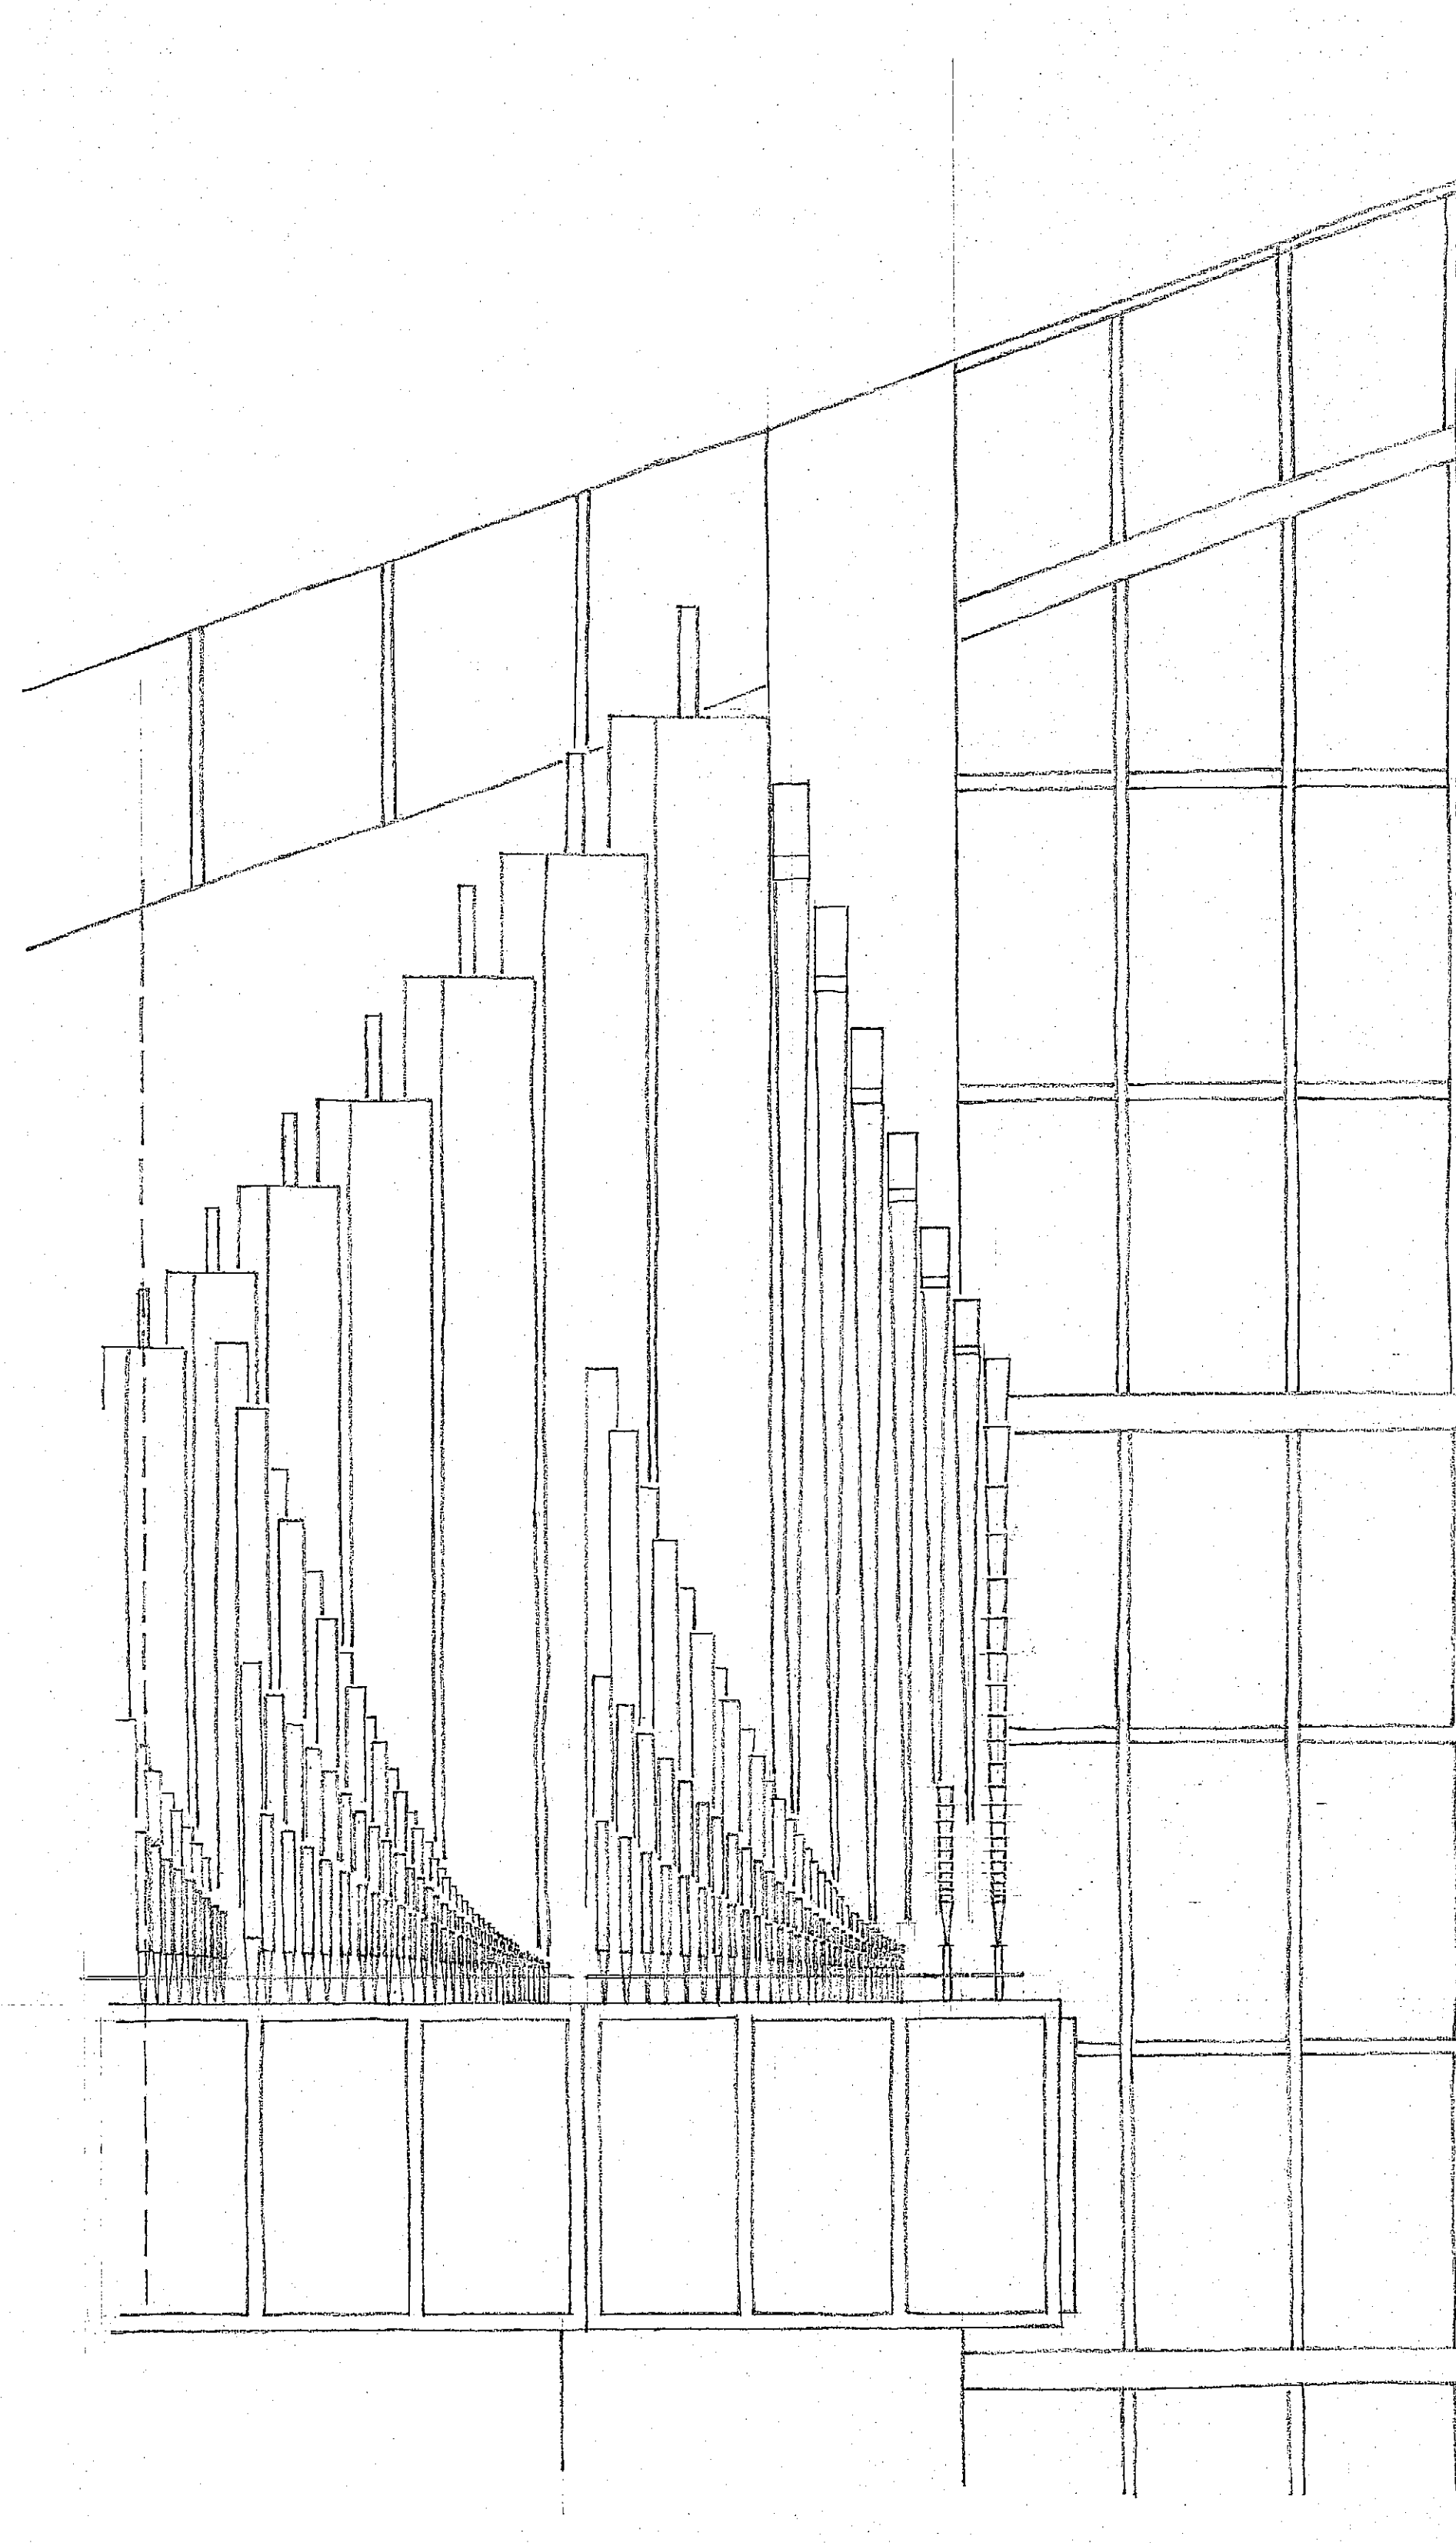


• FRONT ELEVATION •

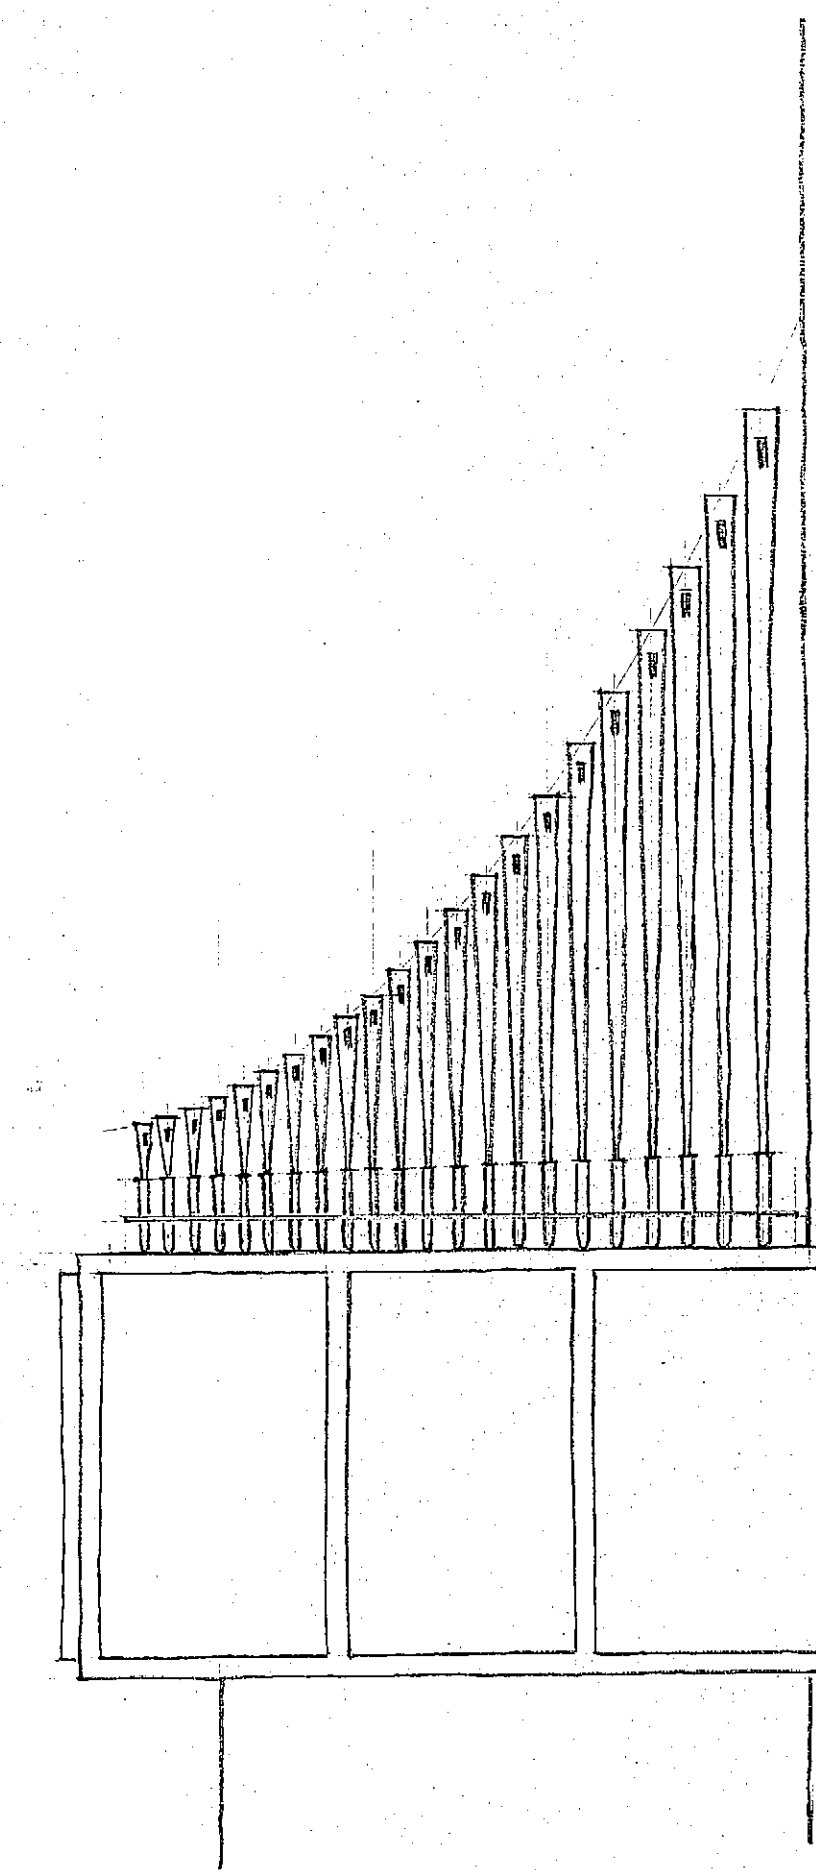


• END ELEVATION •


APPROVED:		DATE	
MIAMI SHORES PRESBYTERIAN CHURCH, MIAMI SHORES, FLORIDA			
SCALE: 1/2" = 1'-0" ±		M. P. MOLLER, INC.,	10090
DATE	DRAWN	HAGERSTOWN, MD.	DRAWING NO. 1009
10-2-61	RYK		

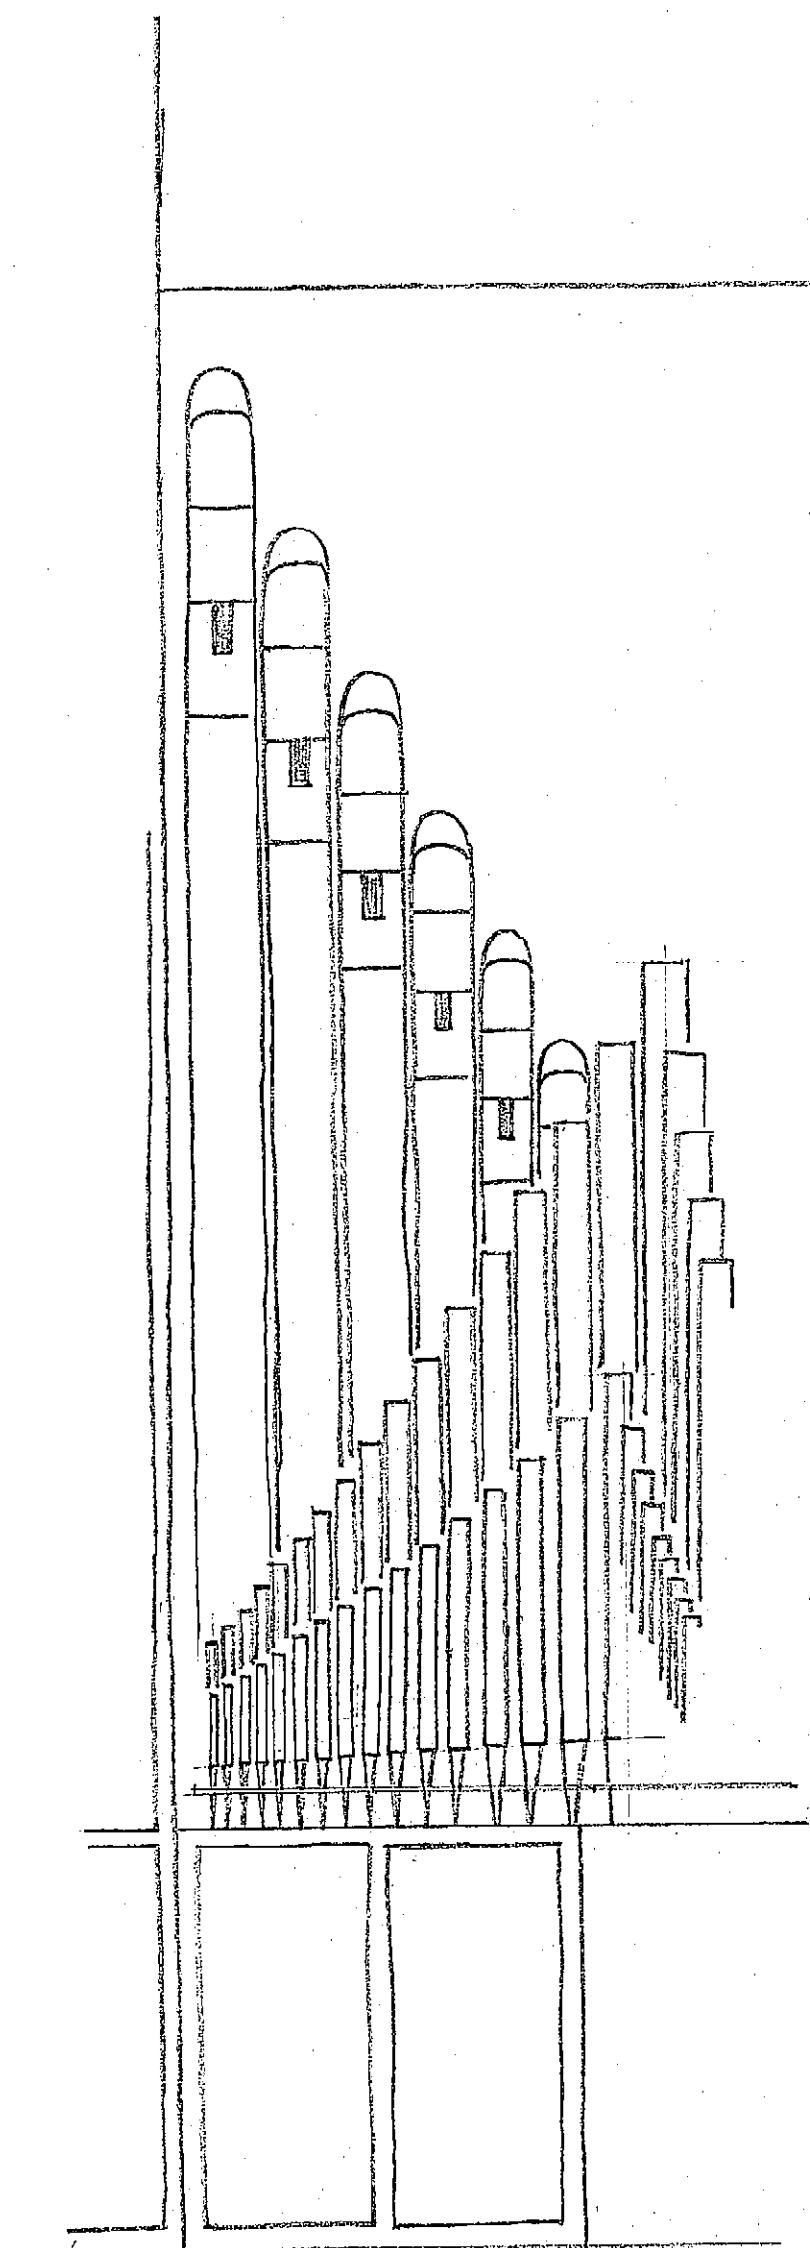

• SIDE ELEVATION •

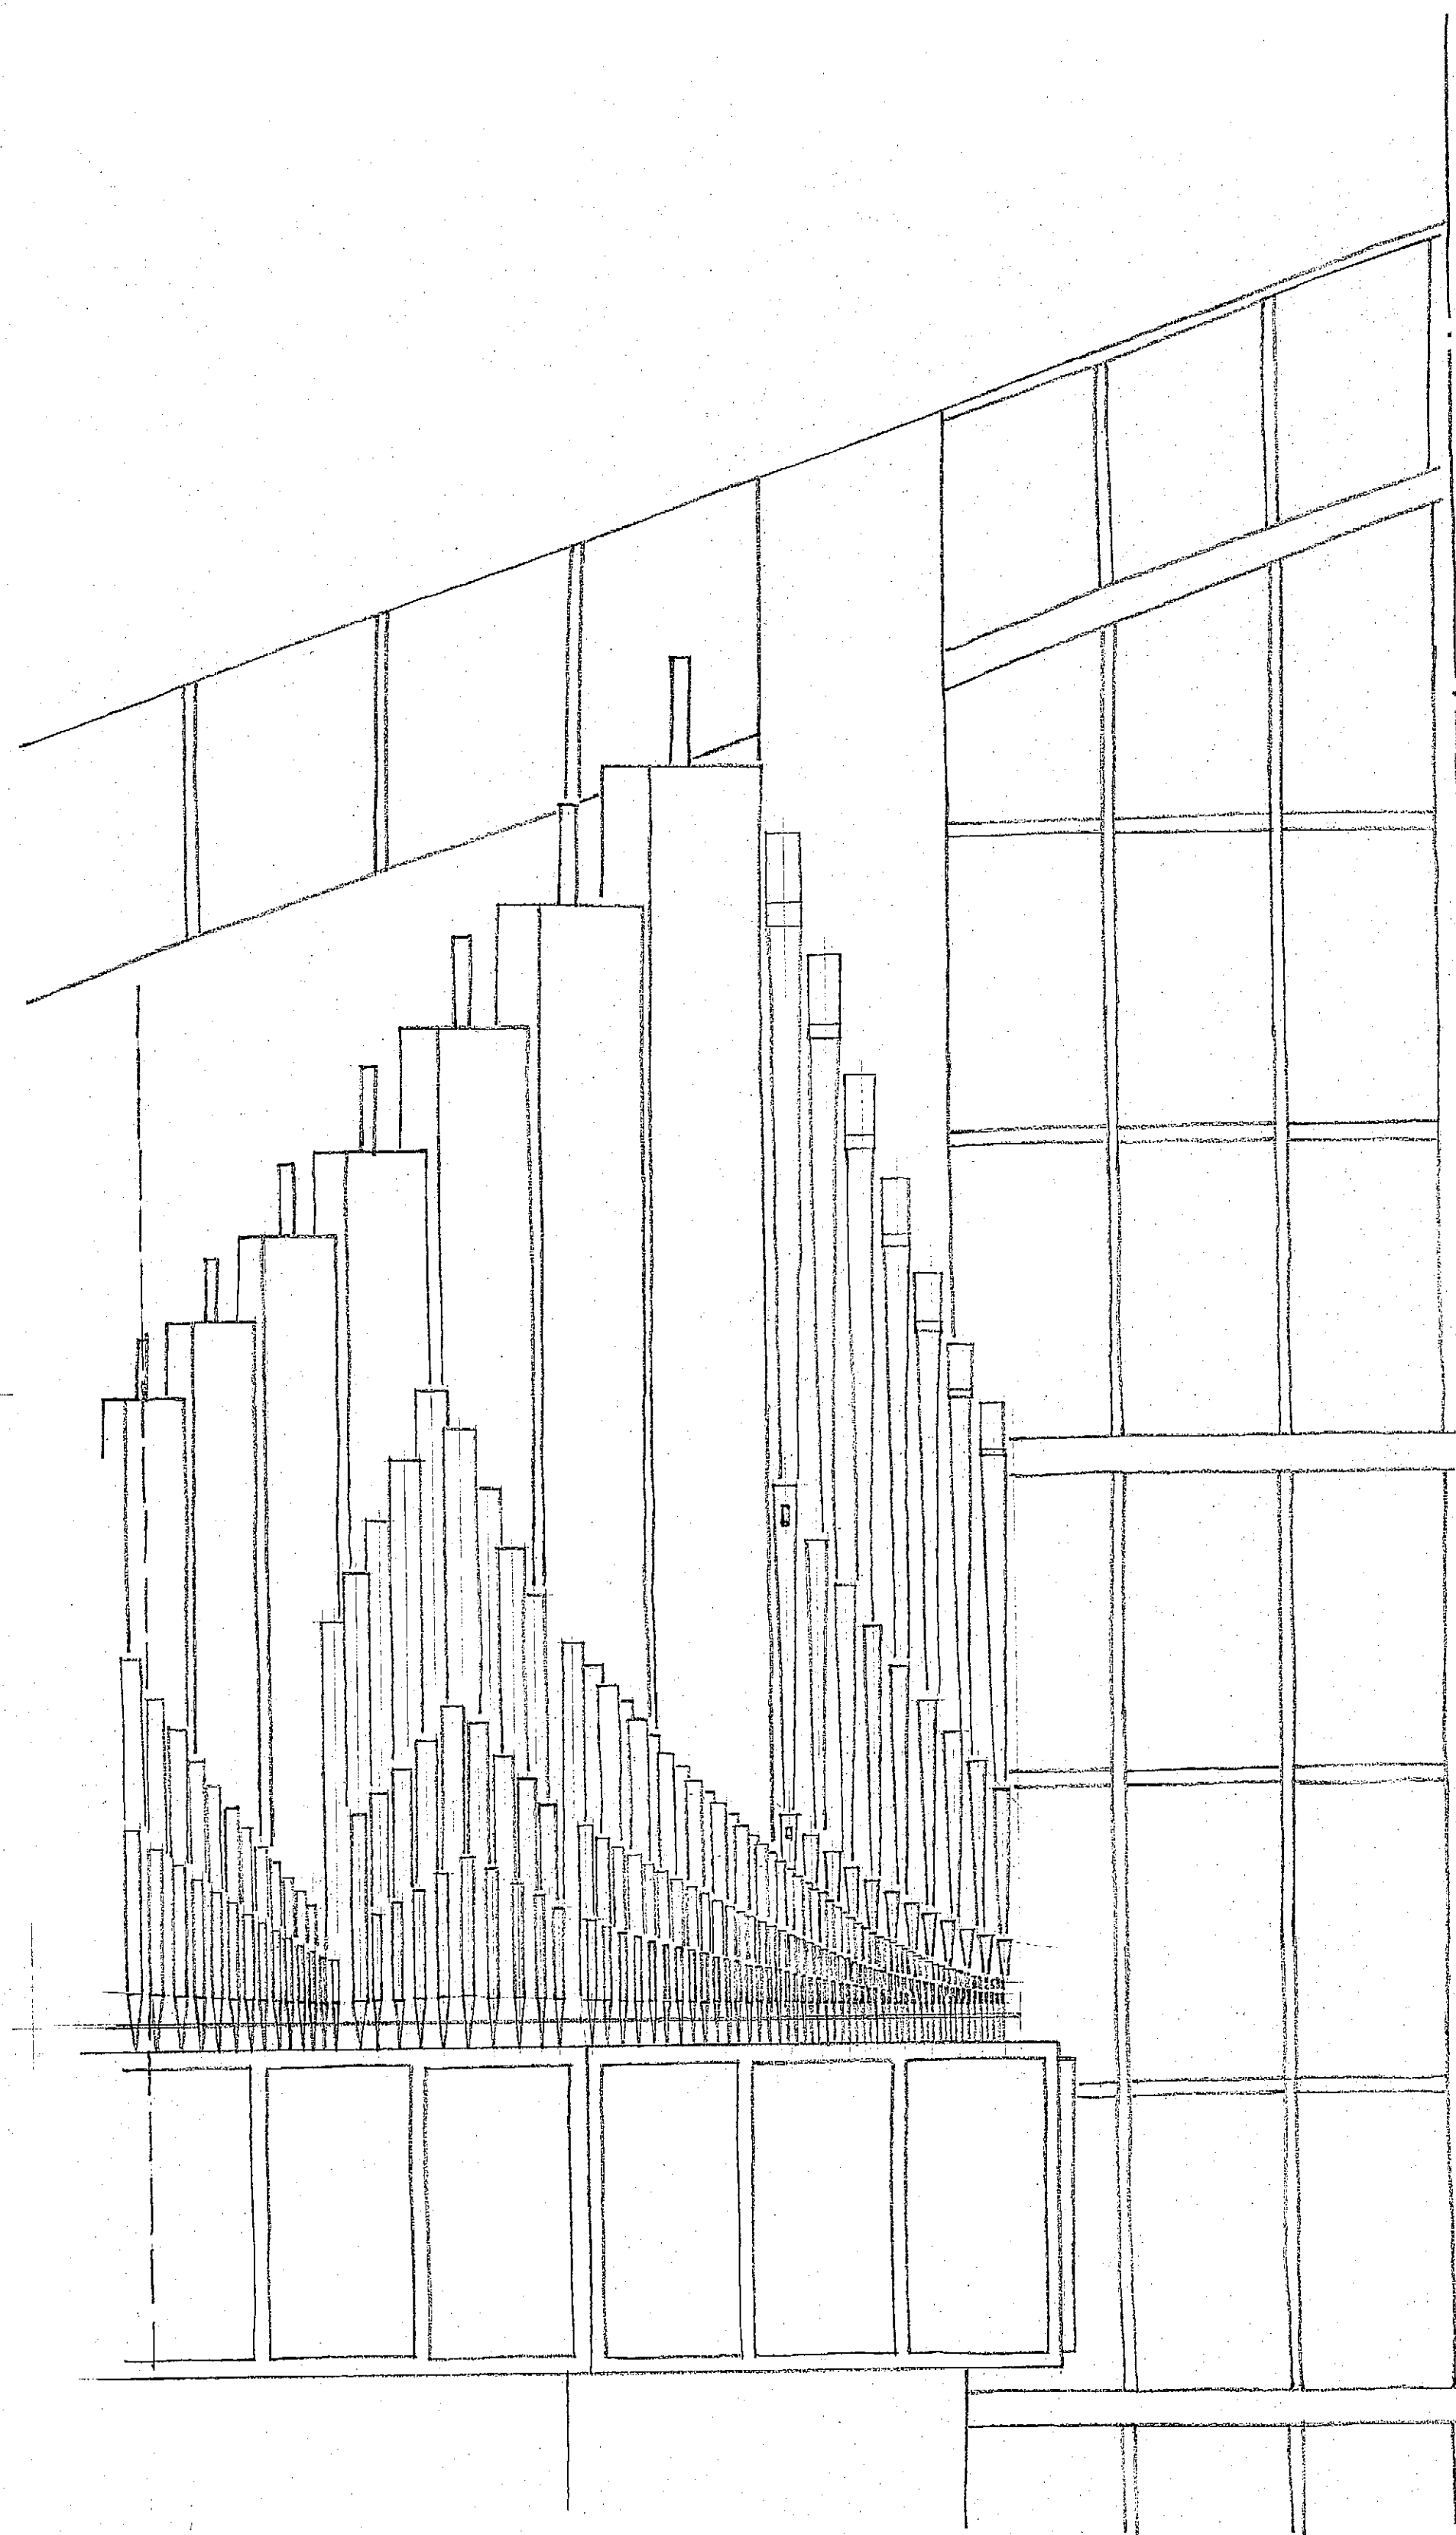


• FRONT ELEVATION •

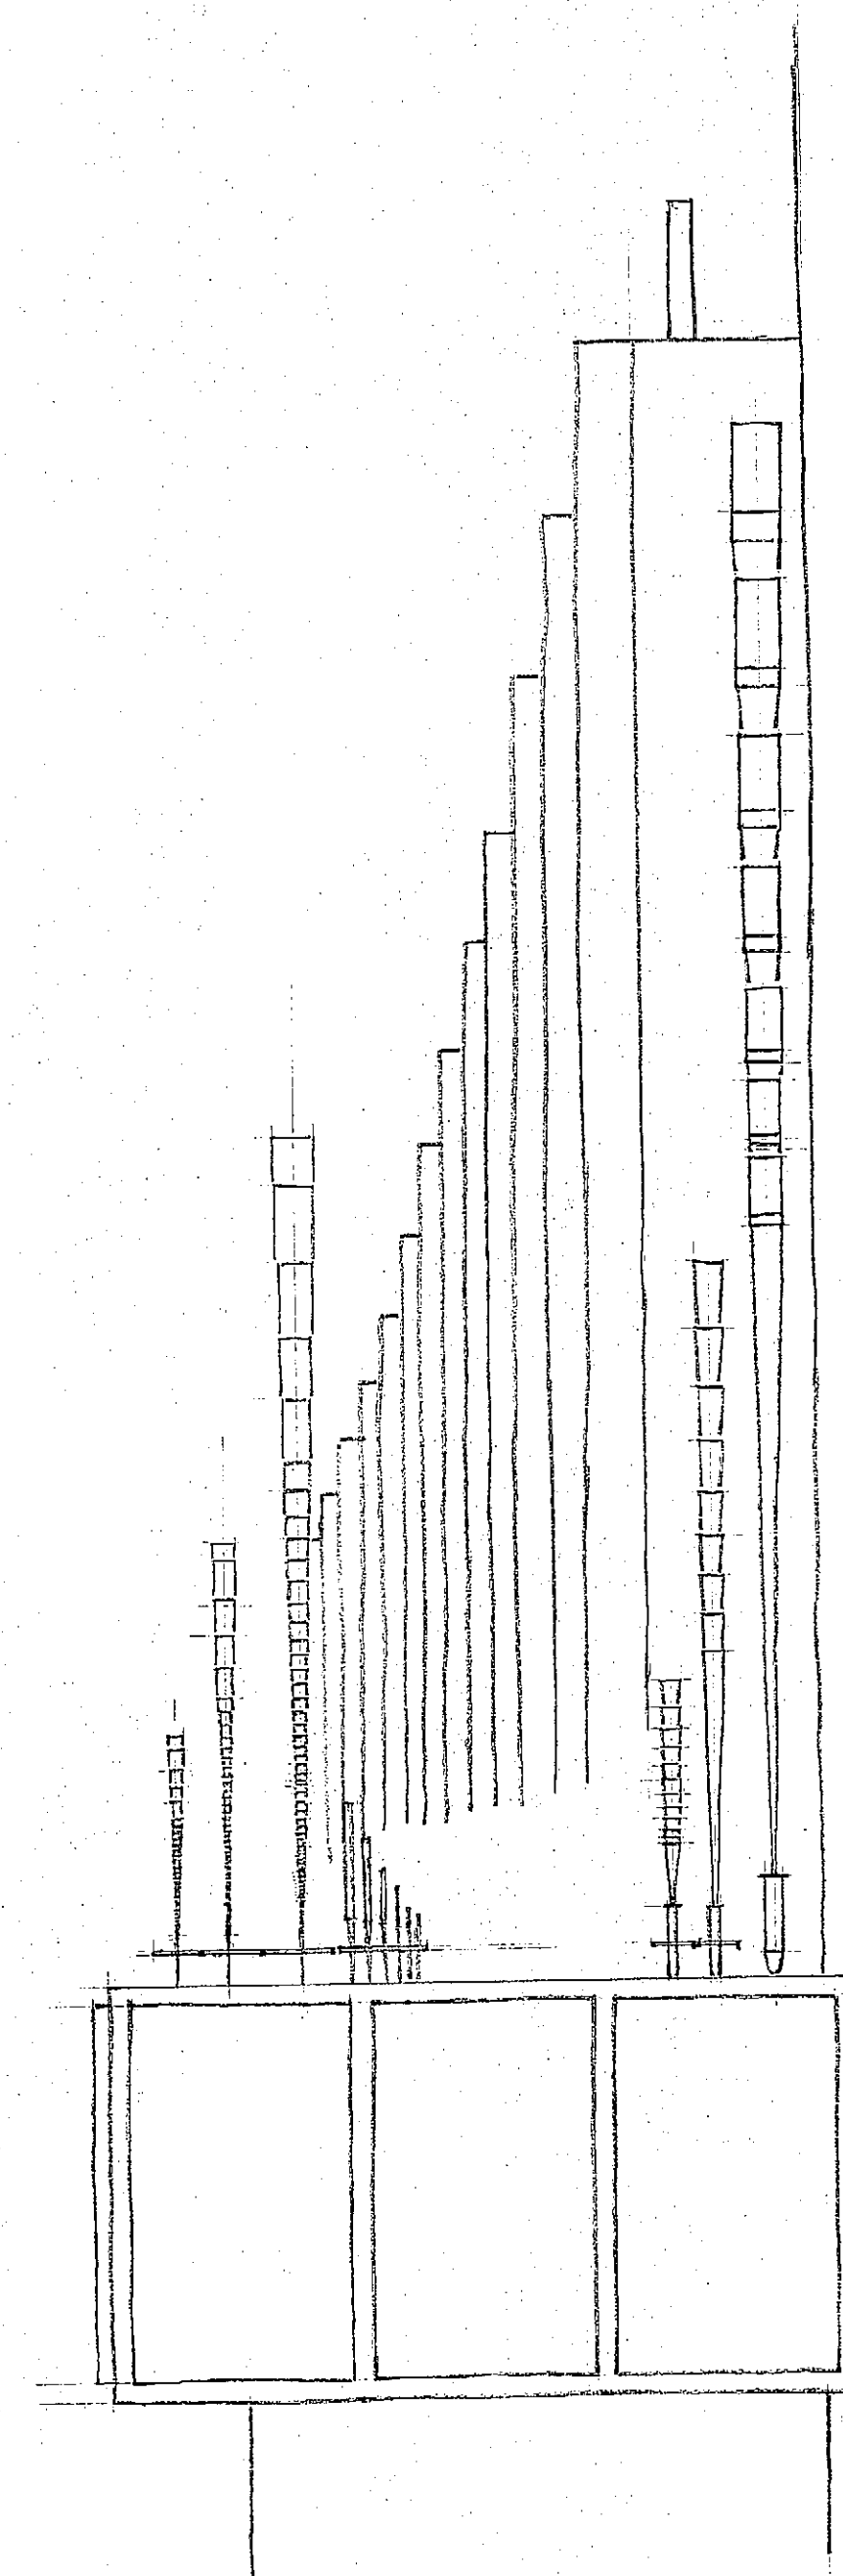


• END ELEVATION •

APPROVED: _____		DATE _____	
MIAMI SHORES PRESBYTERIAN CHURCH,			
MIAMI SHORES, FLORIDA			
SCALE: $\frac{1}{2}" = 1'-0"$		M. P. MÖLLER, INC.	
DATE DRAWN		10090	
10-14-67 RYK		HAGERSTOWN, MD.	
		DRAWING NO. 110	

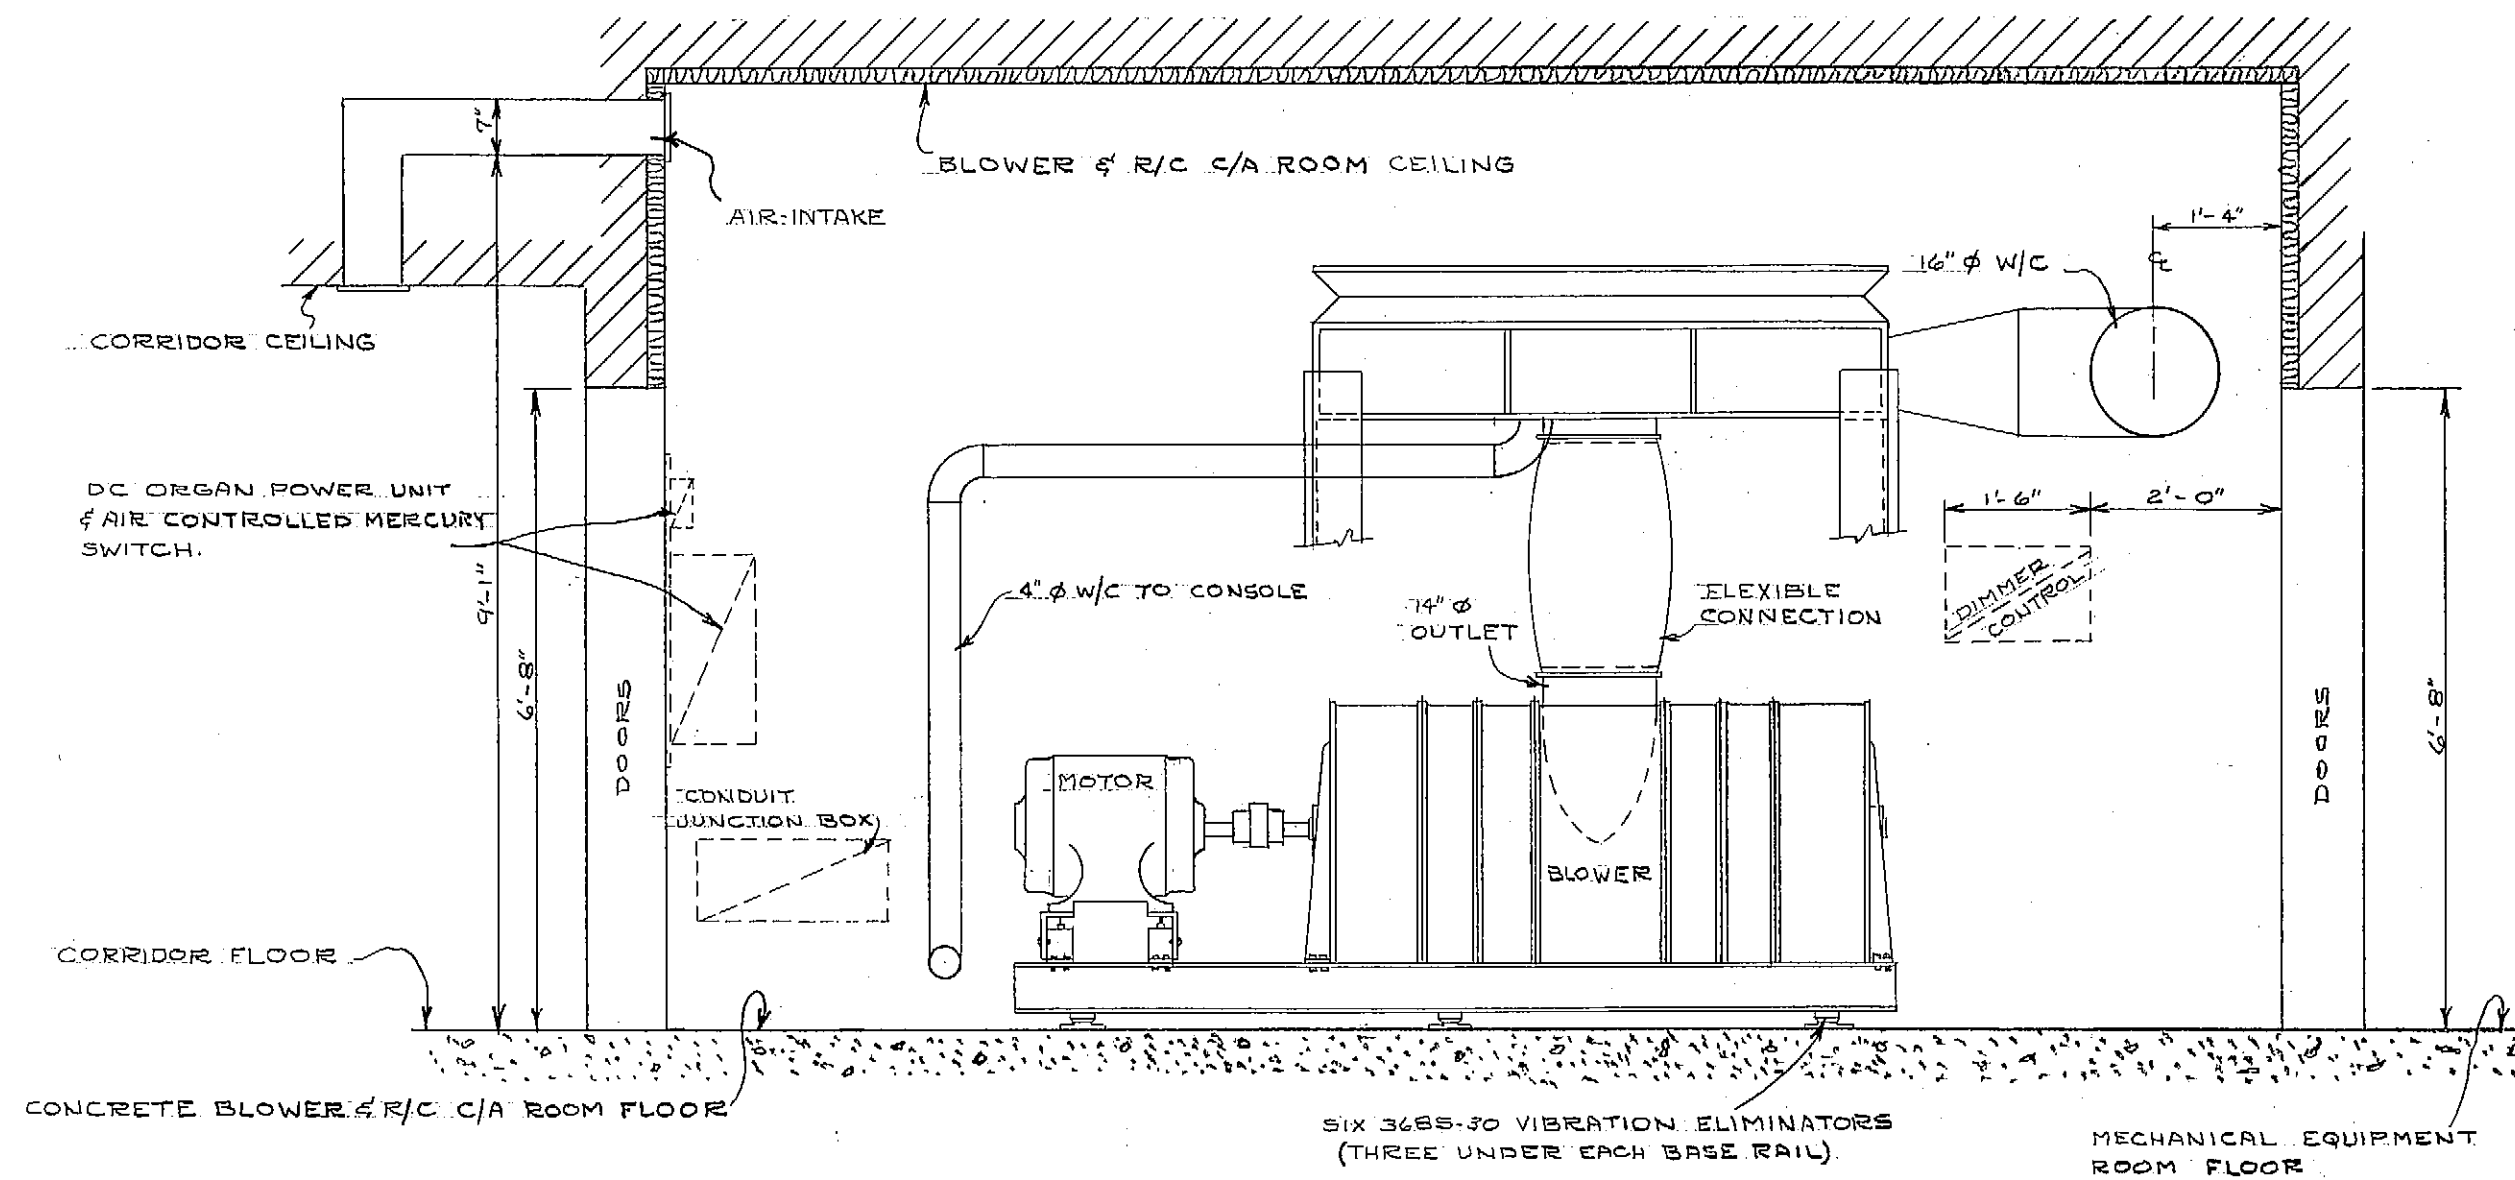

SECTION BB

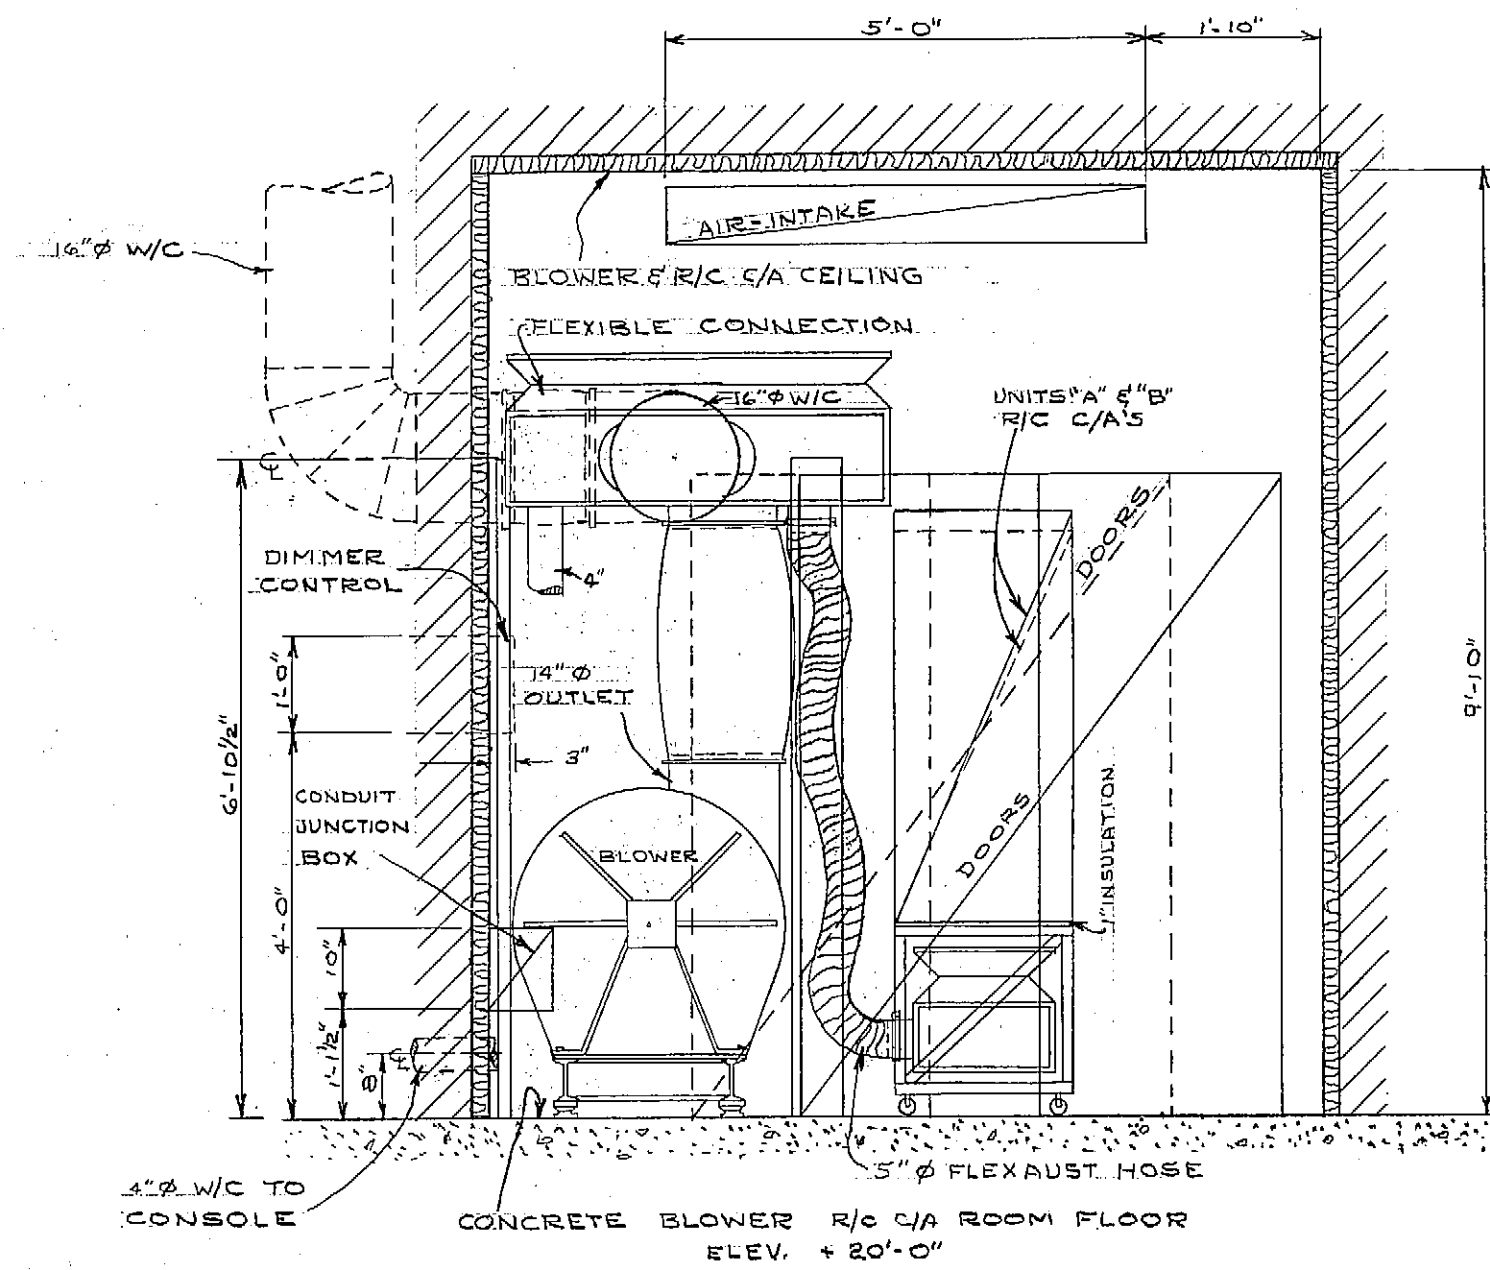

SECTION AA

BLOWER SIZE - STYLE 4P330 15 HP MOTOR 14" OUTLET
45" LONG 24" WIDE 34" HIGH

BLOWER ROOM TO BE CLEAN & DRY, NORMALLY HEATED & FREE OF EXCESSIVE DRYNESS & DAMPNESS AT ALL TIMES. PROVIDE A FILTERED AIR INTAKE FROM A NORMALLY HEATED OR COOLED AREA WITHIN BUILDING EQUIVALENT TO AN UNOBSTRUCTED AREA OF 400 SQ. IN. INTAKE AREA SHOULD BE CLEAN, FREE OF DUST & FUMES & NOT EXCESSIVELY DRY OR HUMID.

M.P.M., INC. TO SUPPLY - ONE PIECE 4 FEET 5" DIAMETER FLEXAUST HOSE

M.P.M., INC. TO PROVIDE 10" X 12" X 6" DC WIRES JUNCTION BOX TO BE LOCATED ABOVE CONDUIT JUNCTION BOX BY OTHERS.


PROVIDE ELECTRICAL SERVICE FOR 15 HP BLOWER, 3 PHASE 60 CYCLES, 240 VOLTS, 60 AMPERES.

AC OUTLET FOR DC ORGAN POWER UNIT TO BE LOCATED APPROX. 2'-0" ABOVE FLOOR.

AC INPUT (FUSED WITHIN UNIT) 3 PHASE, 60 CYCLES, 240 VOLTS, 60 AMPERES
DC OUTPUT - 10-15 VOLTS, 50 AMPERES

DC ORGAN POWER UNIT & AIR CONTROLLED MERCURY SWITCH WITH CONTACTOR MOUNTED ON PLYWOOD PANEL. COVER BACK OF POWER UNIT WITH CURON.

CORRIDOR

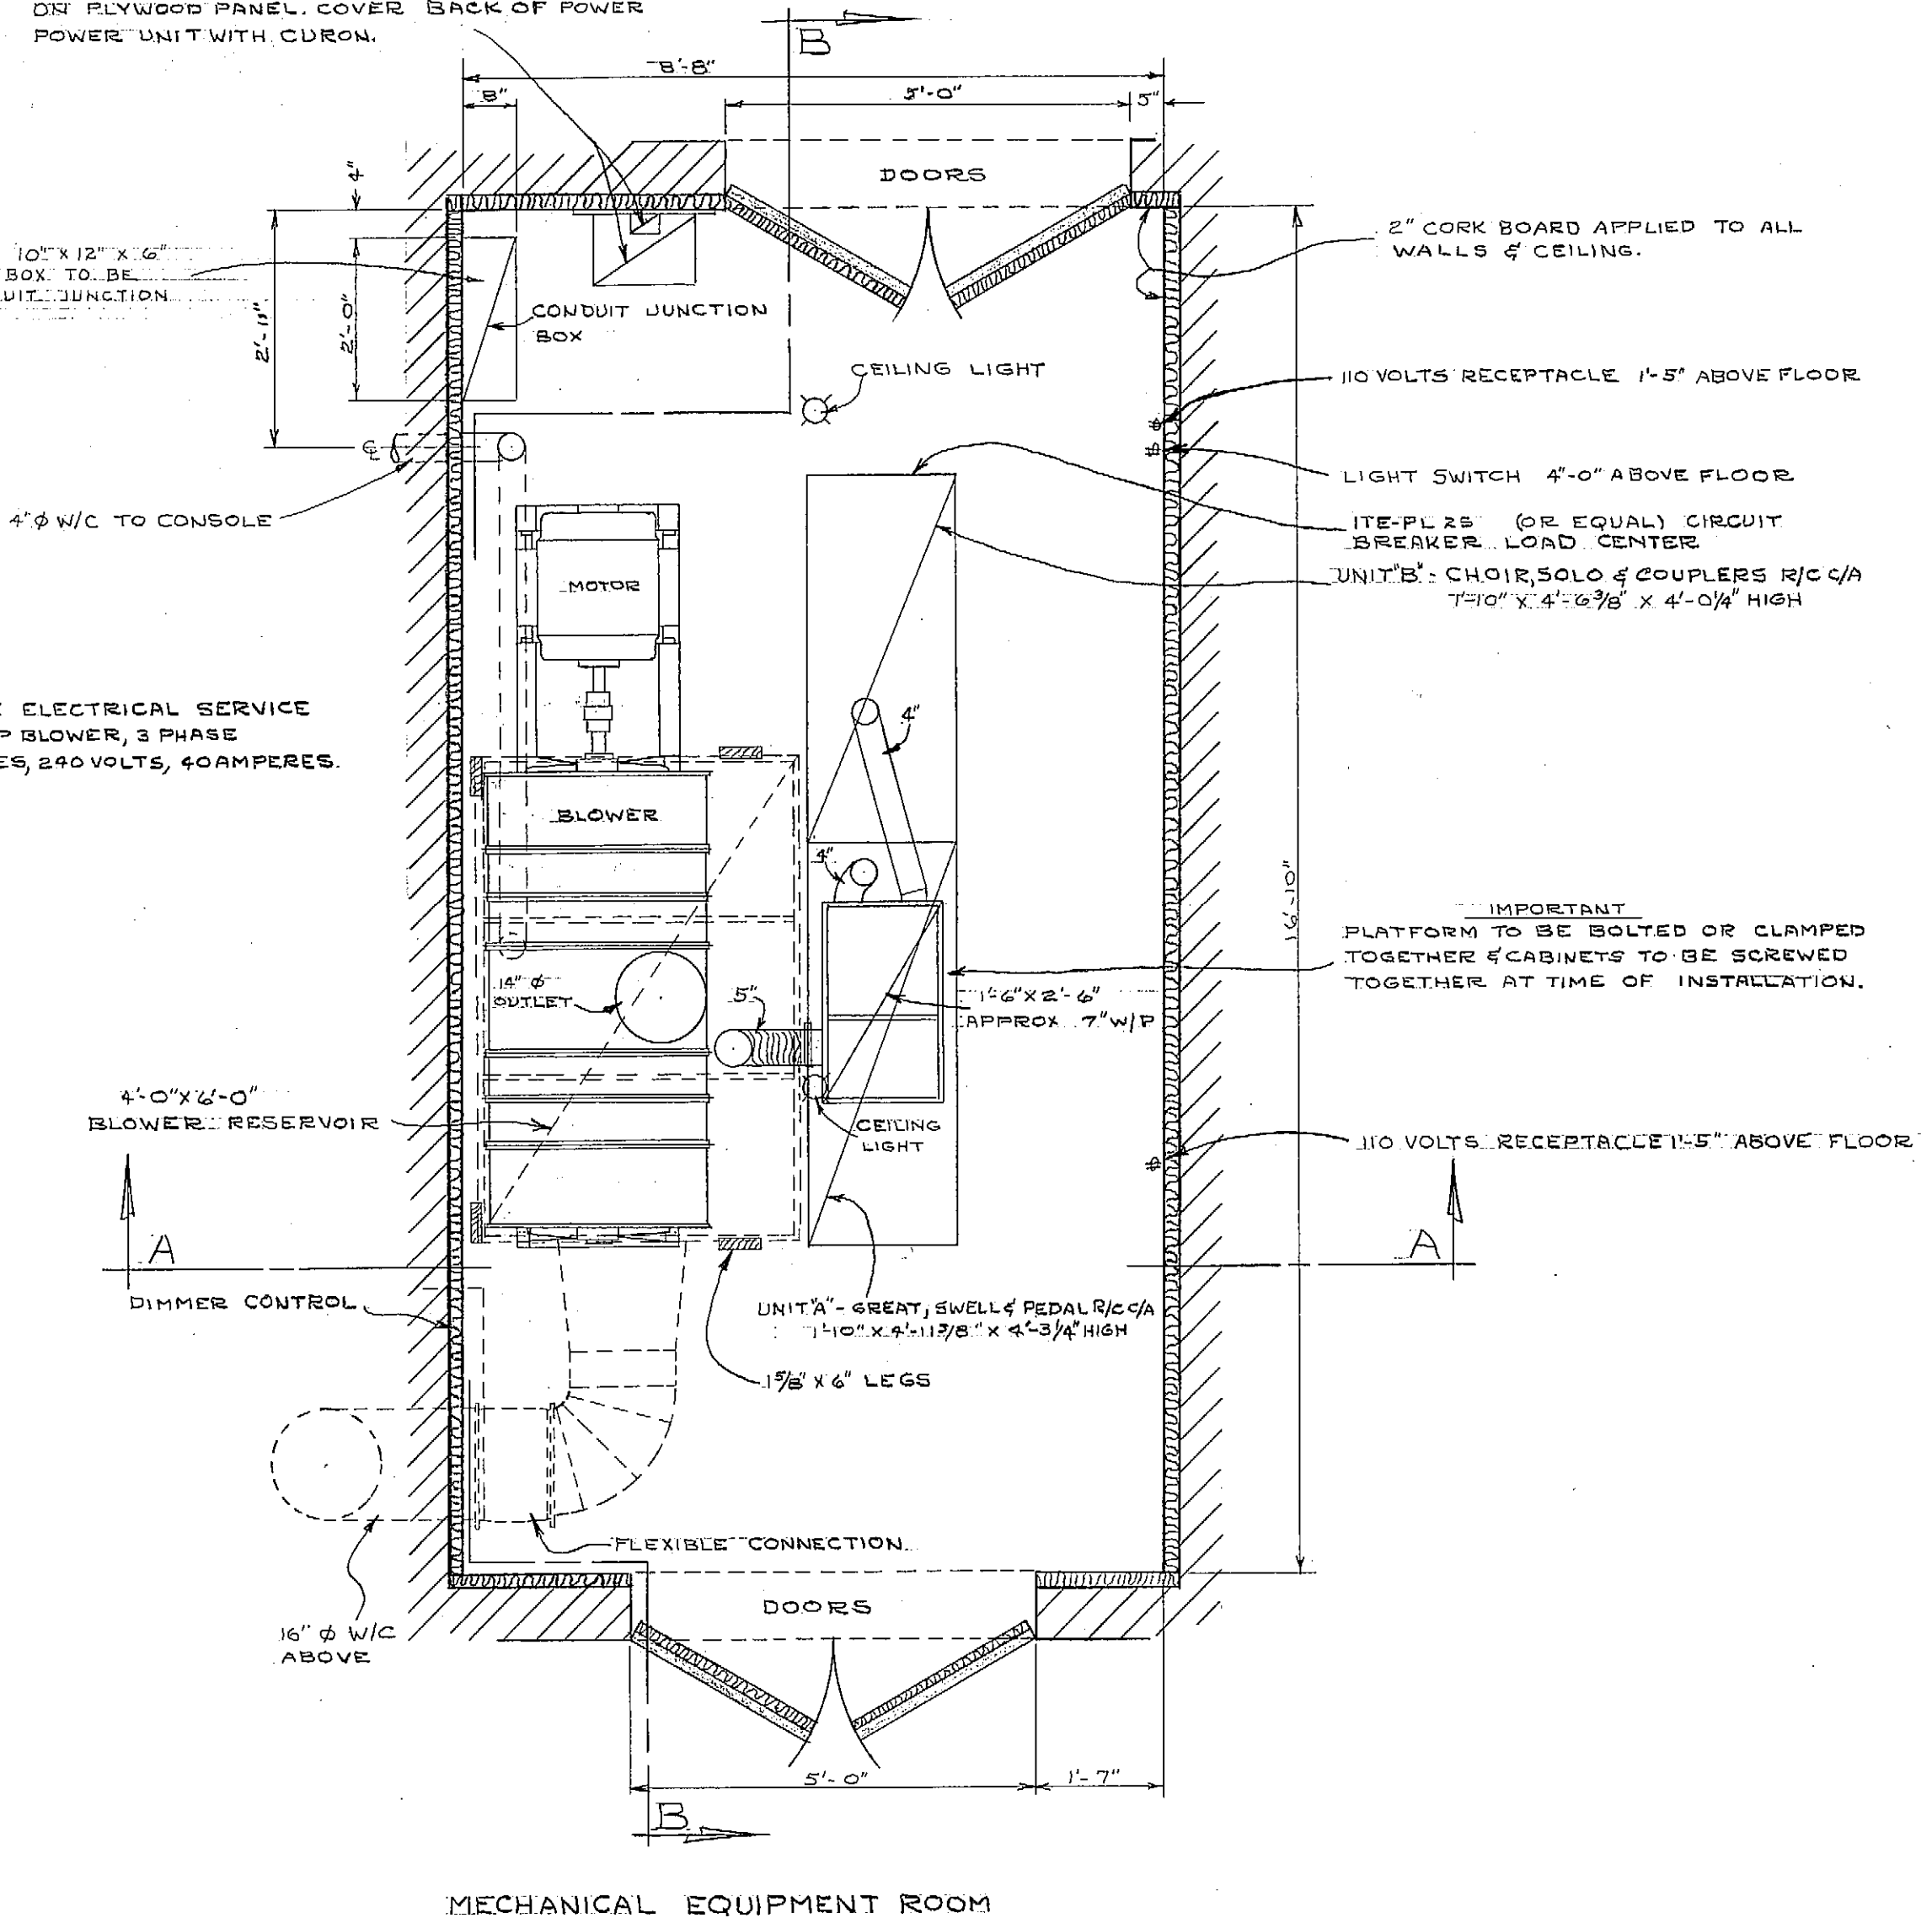

FLOOR PLAN


BLOWER

DIMENSIONS OK BY ARCHITECT DATE 10-6-67


MIAMI SHORES PRESBYTERIAN CHURCH,
MIAMI SHORES, FLA.

SCALE - 1/2" = 1'-0"	REV. DATE	M.P.M. MÖLLER, INC.	10090
REV. DATE	1-5-68	HAGERSTOWN, MD.	DRAWING NO. 111

MAIN CONSOLE (ELECTRO-PNEUMATIC)

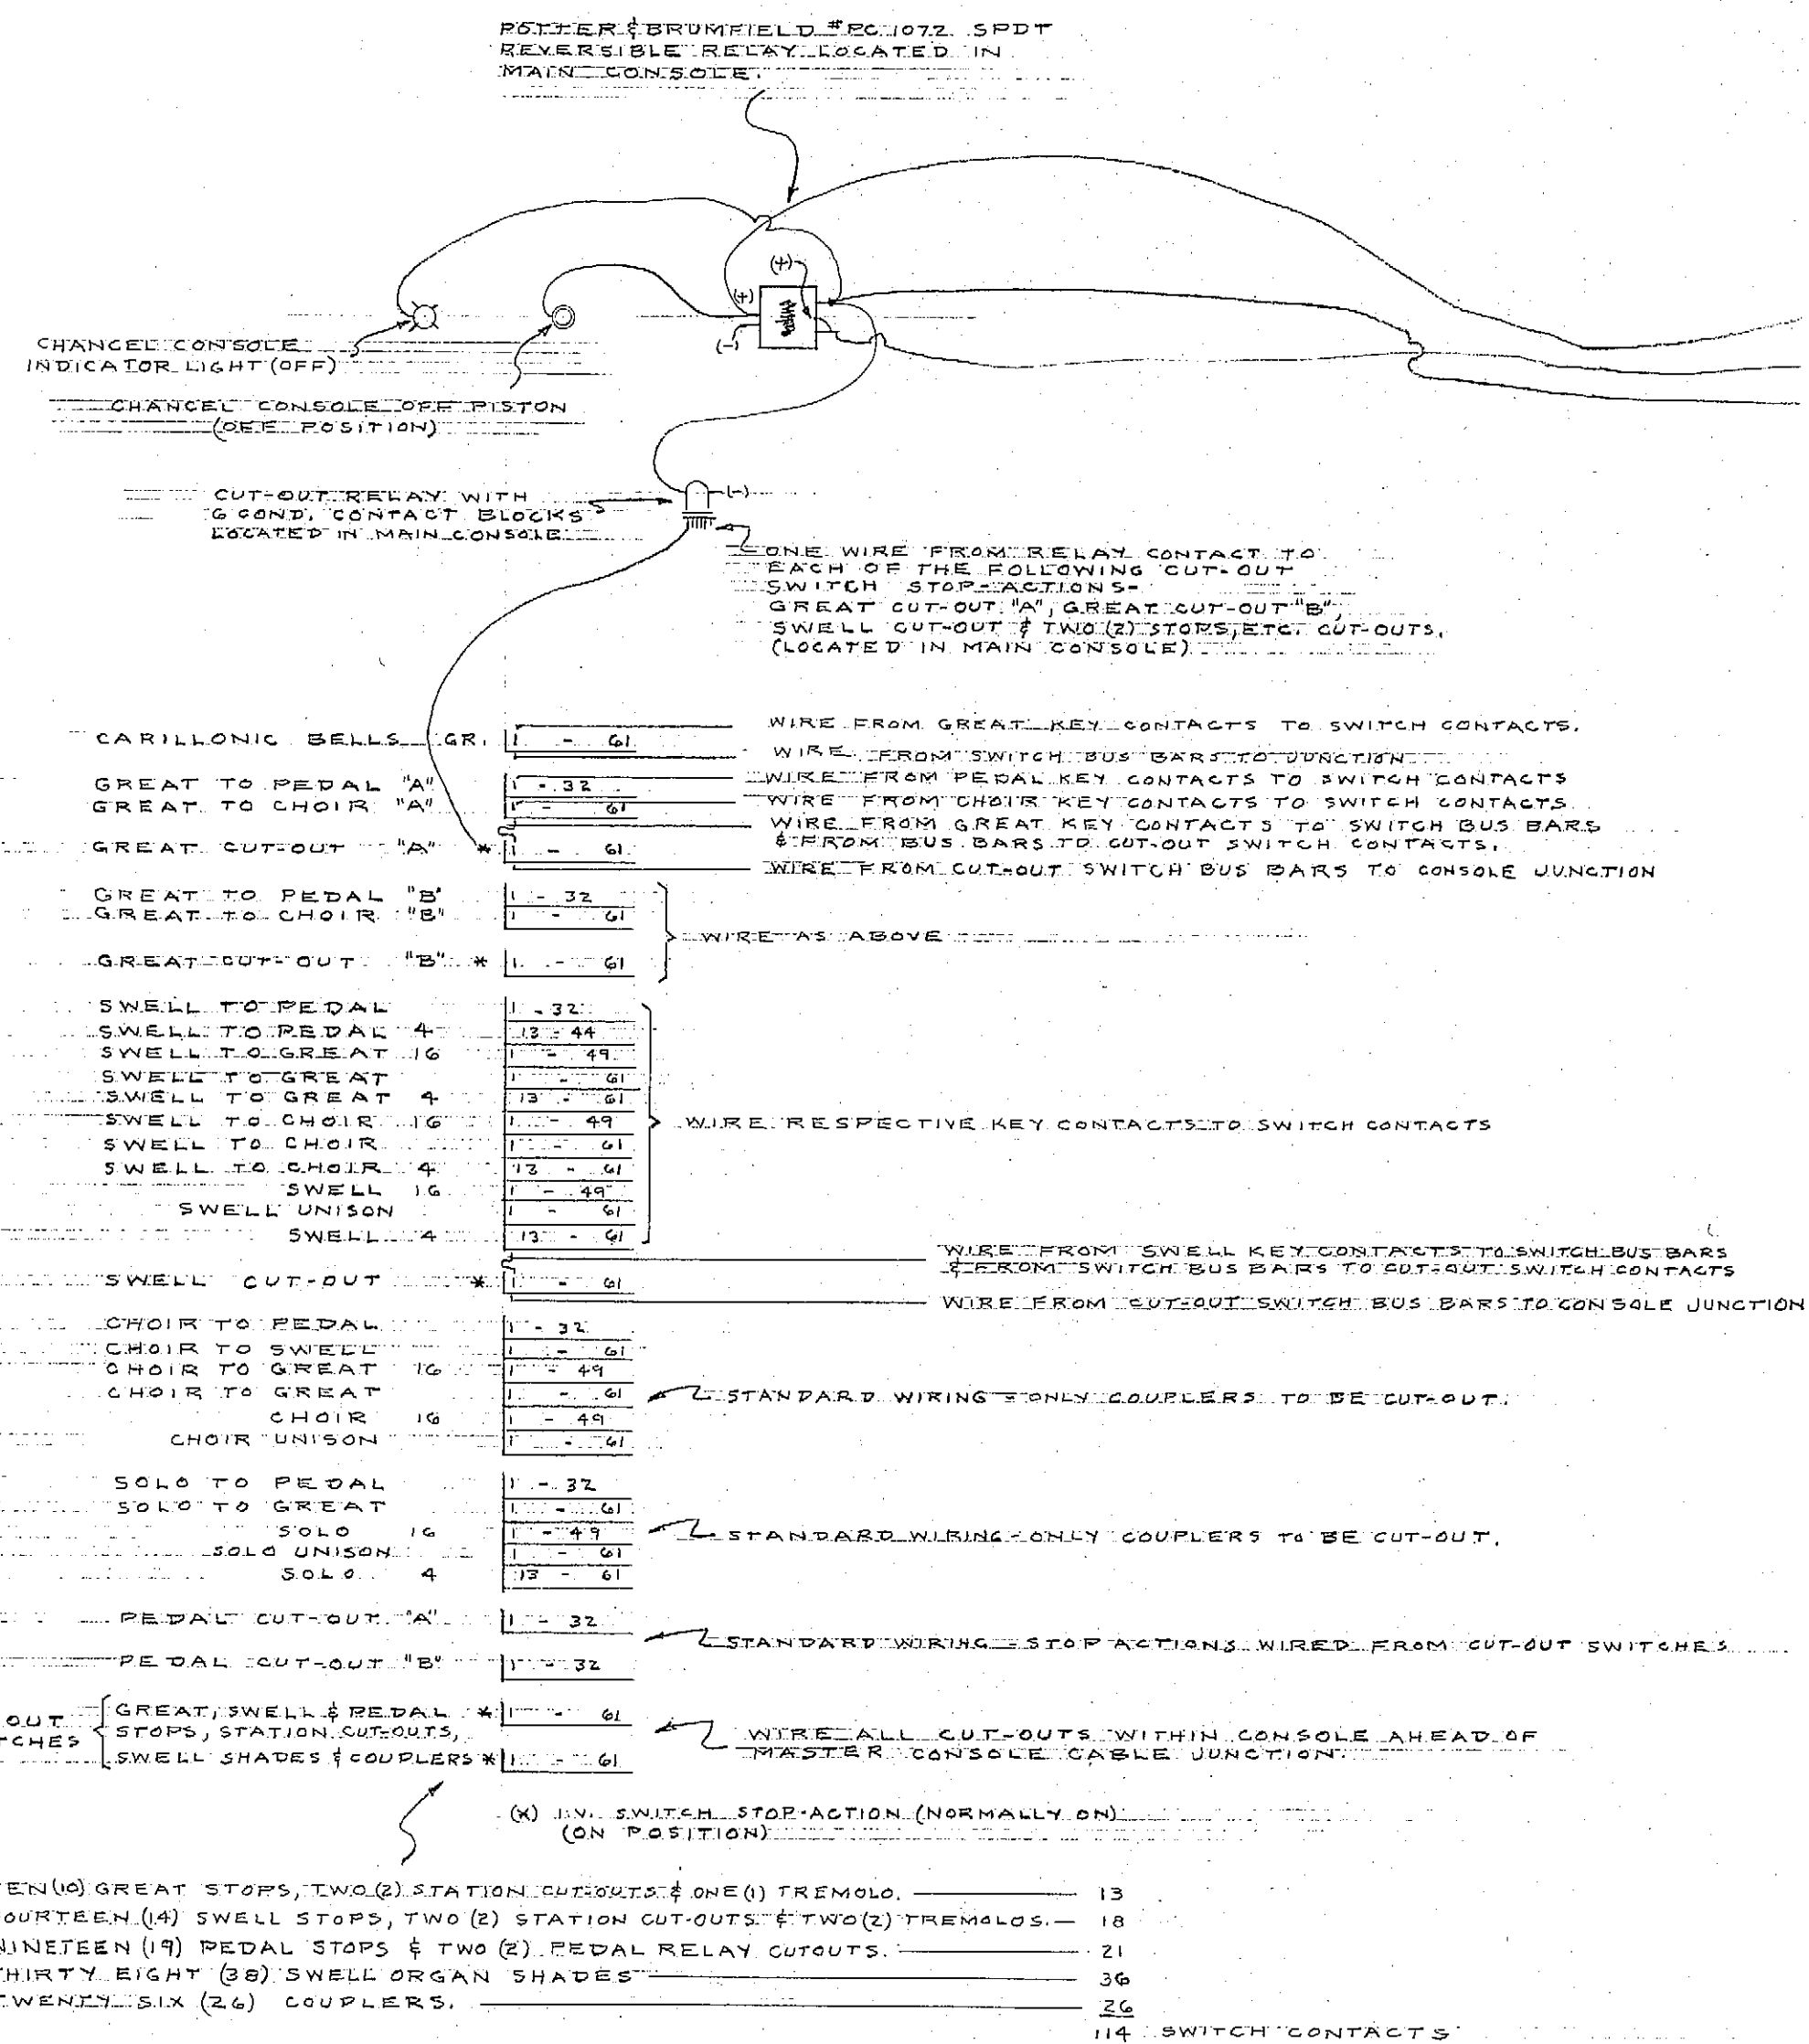

CHANCEL CONSOLE (ALL ELECTRIC)

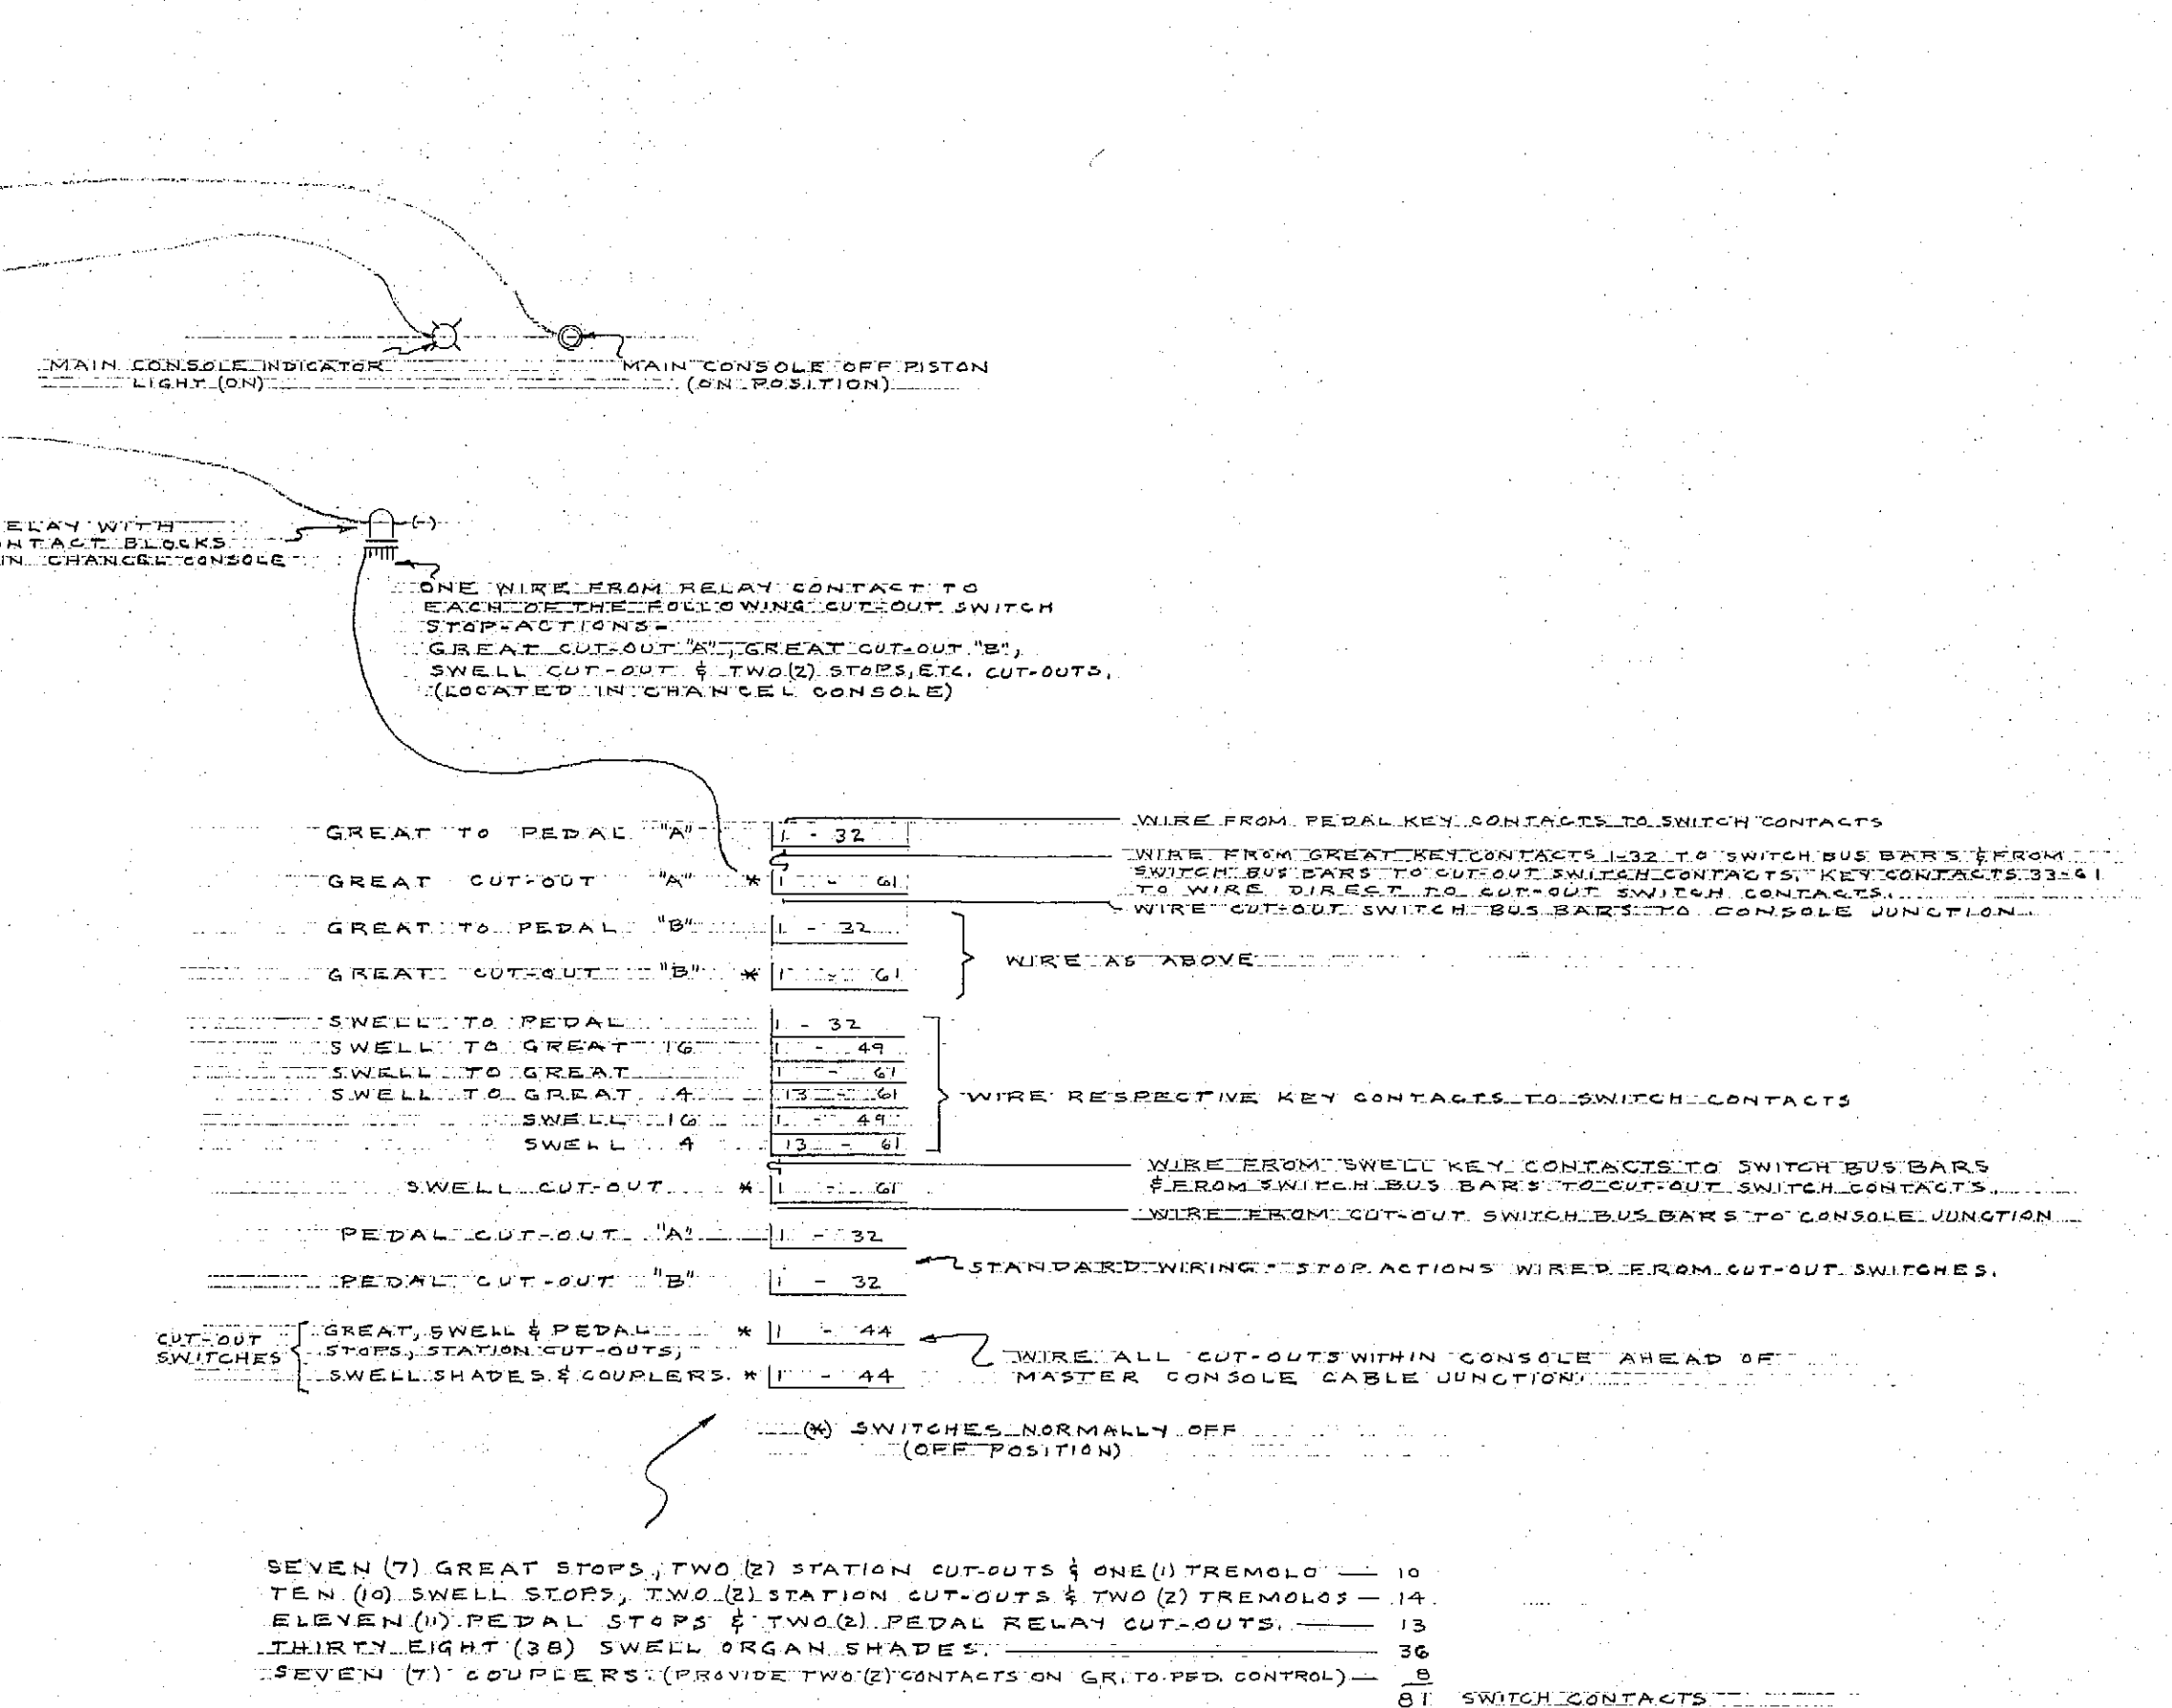

CONSOLES COUPLERS REQUIREMENTS & CONSOLE CUT-OUT SYSTEMS

10090
MIAMI SHORES PRESBYTERIAN CHURCH,
MIAMI SHORES, FLA.

12-18-67 DRAWING NO. 112
REV. 12-29-67

